

PO # 151499

ams

**CHANGE
ORDER****FORT BEND COUNTY
ENGINEERING**

Distribution:

- ☒ FBC Engineering
- ☒ FBC Judge
- ☒ FBC Purchasing
- ☒ Contractor
- ☒ Consultant

Address: 301 Jackson Street
Richmond, Texas 77469
Phone: 281-633-7500
Fax: 281-342-7366
Web site: www.FortBendCountyTx.gov

PROJECT:
Bellaire Blvd. from 1464 to San Pablo Drive Paving
and Drainage Improvements

CHANGE ORDER NUMBER 04
DATE 4/04/2018
PROJECT NUMBER 13202
CONTRACT FOR 3,772,635.08
CONTRACT DATE 3/28/2017
FBC PURCHASE ORDER NO 151499

CONTRACTOR:
Allgood Construction Co. Inc.
1702 Settegast Ranch Rd.
Richmond, Texas 77406

The contract is changed as follows: Add signage and stripping at San Pablo & Chickory Woods intersections per revised Sheet 52; add ramp revisions at San Pablo & Chickory Woods intersections per revised Sheet 22 & 27; add mow-strip at 8 guardrail locations and 8" crushed rock for maintenance access per revised sheet 27; extend pedestrian rail 10 lf at both locations on the west side of the San Pablo Bridge including concrete foundation revisions; add 60 lf of 24" CMP and inlet structure for drainage per revised Sheet 23; add Type A Inlet at Sta. 31+00; delete quantities not necessary to complete the work; and add 31 days to the project duration to complete the work.

Not valid until signed by Fort Bend County and Contractor.

The Original (Contract Sum) \$ 3,772,635.08 ✓
Net change by previously authorized Change Orders \$ 13,796.30 ✓
The (Contract Sum) Prior to this Change Order was \$ 3,786,431.38 ✓
The (Contract Sum) will be ☒ increased *or* ☐ decreased *or* ☐ unchanged
by this Change Order in the amount of \$ 33,799.16 ✓
The new (Contract Sum) including this Change Order will be \$ 3,820,230.54 ✓

The Contract Time will be ☒ increased *or* ☐ decreased *or* ☐ unchanged by 31 Days.
The Date of Substantial Completion as of this Change Order therefore is
☒ changed *or* ☐ unchanged to 3/29/2018.

Authorized:

Fort Bend County Engineering
J Stacy Slawinski, P.E.
301 Jackson
Richmond, Texas 77469

By: _____

(signature)

DATE: _____

04/09/18

CONTRACTOR
Allgood Construction Co. Inc.
1702 Settegast Ranch Rd
Richmond, TX 77406

By: _____

(signature)

DATE: _____

4-5-18

Fort Bend County Judge
Honorable Robert E. Hebert
301 Jackson St., #719
Richmond, Texas 77469

By: _____

(signature)

DATE: _____



PROJECT: Bellaire Blvd -

OWNER: Fort Bend County

CONTRACTOR: Allgood Construction

REQUEST: By request of Fort Bend County these items are to be added to complete the project.

CHANGE ORDER REQUEST #4

DATE: 04/04/2018
4
CHANGE ORDER NO. 13202
JOB NO.



Contract Amount	\$3,772,635.08
Previously approved CO 001	\$21,420.00
Previously Approved CO 002	\$2,873.00
Previously Approved CO 003	-\$10,496.70
Requested Chang Order Amount	\$33,799.16
New Contract Amount	\$3,820,230.54

Item No.	Item Description	Unit Measure	Bid Quantity	Bid Cost	Bid Total	New Quantity	Item Price	New Item Total	Total Change in Price
NEW BID ITEMS									
100	Remove Existing Ramps	EA	-	\$ -	\$ -	6.00	\$ 750.00	\$ 4,500.00	\$ 4,500.00
101	Install Flags on top of Stop Sign	EA	-	\$ -	\$ -	4.00	\$ 150.00	\$ 600.00	\$ 600.00
102	Install Continental CrossWalk	LF	-	\$ -	\$ -	824.00	\$ 6.14	\$ 5,059.36	\$ 5,059.36
103	Mow Strip for Guardrail	SY	-	\$ -	\$ -	93.34	\$ 65.18	\$ 6,083.90	\$ 6,083.90
104	24" CMP for Slope Intercept	LF	-	\$ -	\$ -	60.00	\$ 72.40	\$ 4,344.00	\$ 4,344.00
105	Maintance access Bullrock 8" depth with Geotextile Fabric	SY	-	\$ -	\$ -	380.00	\$ 17.75	\$ 6,745.00	\$ 6,745.00
106	Install Type A-Inlet	EA	-	\$ -	\$ -	1.00	\$ 2,500.00	\$ 2,500.00	\$ 2,500.00
107	PAINT 6" CURB YELLOW PER TRAFFIC DETAIL	EA	-	\$ -	\$ -	2,460.00	\$ 1.25	\$ 3,075.00	\$ 3,075.00
108	ADDED PEDESTRIAN RAIL FROM INSPECTION FOR SAN PABLO BRIDGE	LS	-	\$ -	\$ -	1.00	\$ 10,010.00	\$ 10,010.00	\$ 10,010.00
ADJUSTED QUANTITIES									
33	30" CMP Pipe	LF	170.00	\$ 81.90	\$ 13,923.00	(60.00)	\$ 81.90	\$ (4,914.00)	\$ 9,009.00
88	SWPPP Inspection & Maintenance	MO	12.00	\$ 7,020.00	\$ 84,240.00	(2.00)	\$ 7,020.00	\$ (14,040.00)	\$ 70,200.00
23	Wheelchair Ramps Complete in Place	EA	6	\$ 994.50	\$ 5,967.00	4	\$ 994.50	\$ 3,978.00	\$ 9,945.00
82	Aluminum Signs	EA	11	\$ 239.85	\$ 2,638.35	14	\$ 239.85	\$ 3,357.90	\$ 5,996.25
99	BACK SLOPE INTERCEPT STRUCTURE	EA	1	\$ 2,500.00	\$ 2,500.00	1	\$ 2,500.00	\$ 2,500.00	\$ 5,000.00
								-\$9,118.10	
								\$ 42,917.26	

TOTAL	\$33,799.16
--------------	--------------------

[illegible]

[illegible]

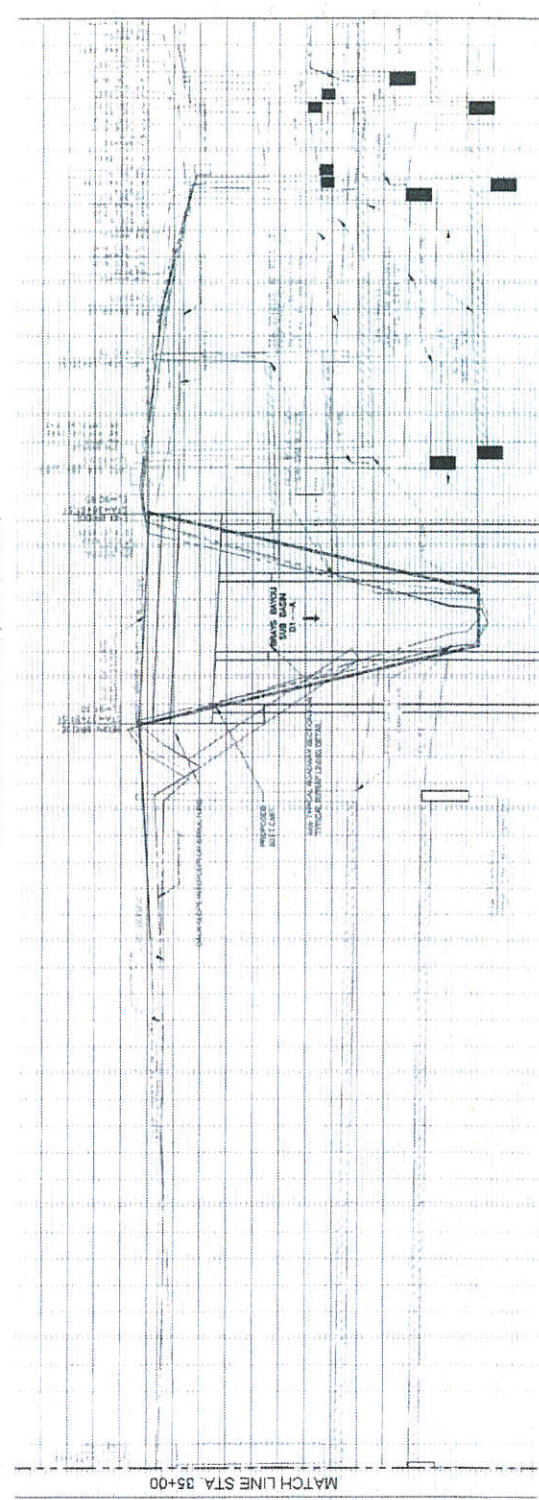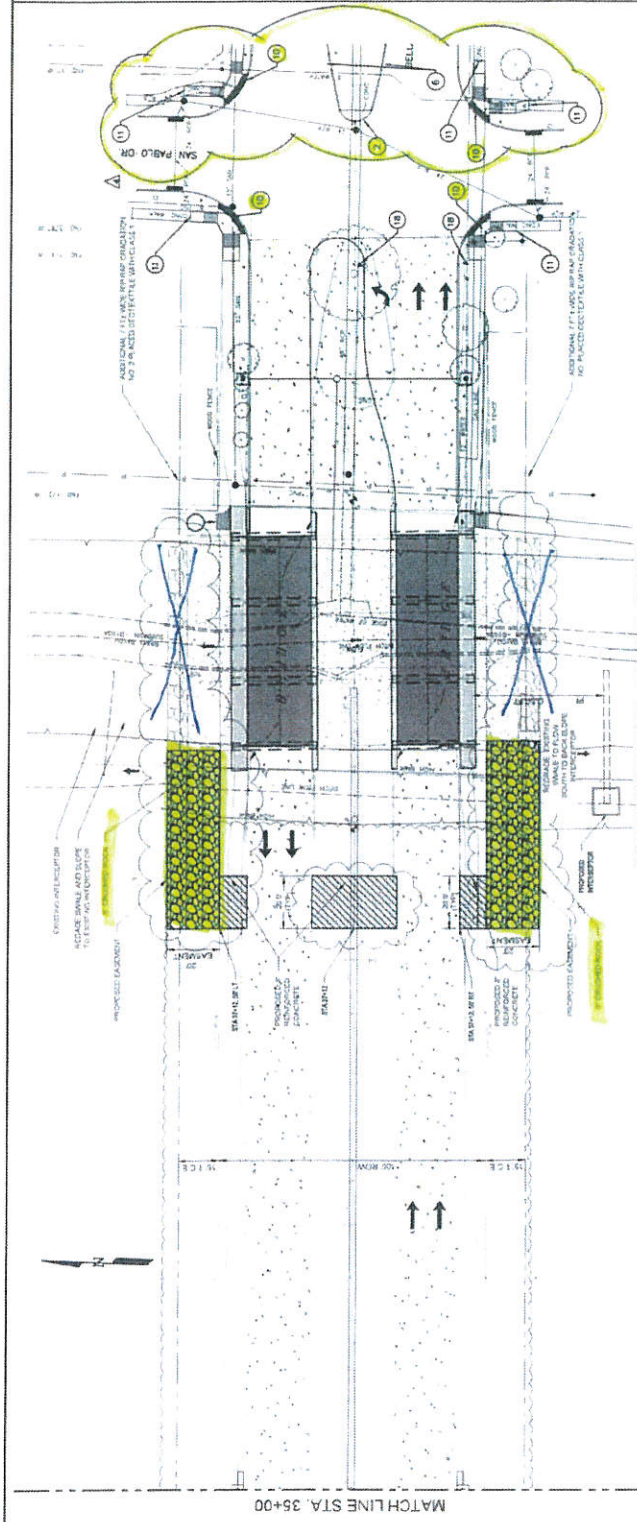

BELLAIRE BLVD FROM
FM 1464 TO
SAN PABLO DRIVE


BELLAIRE BLVD
PLAN AND PROFILE
STA 35+00 TO STA 40+00

FCM Engineers, P.C.
11111 Highway 400
Houston, Texas 77060
Tel: 281.410.1111
Fax: 281.410.1112
www.fcm-engineers.com




DATE: 12/12/11	DESIGNED BY: J. L. JONES
CHECKED BY: J. L. JONES	IN CHARGE: J. L. JONES
PROJECT NO. 12345	

SCOPE INTERCEPT 24" CMP

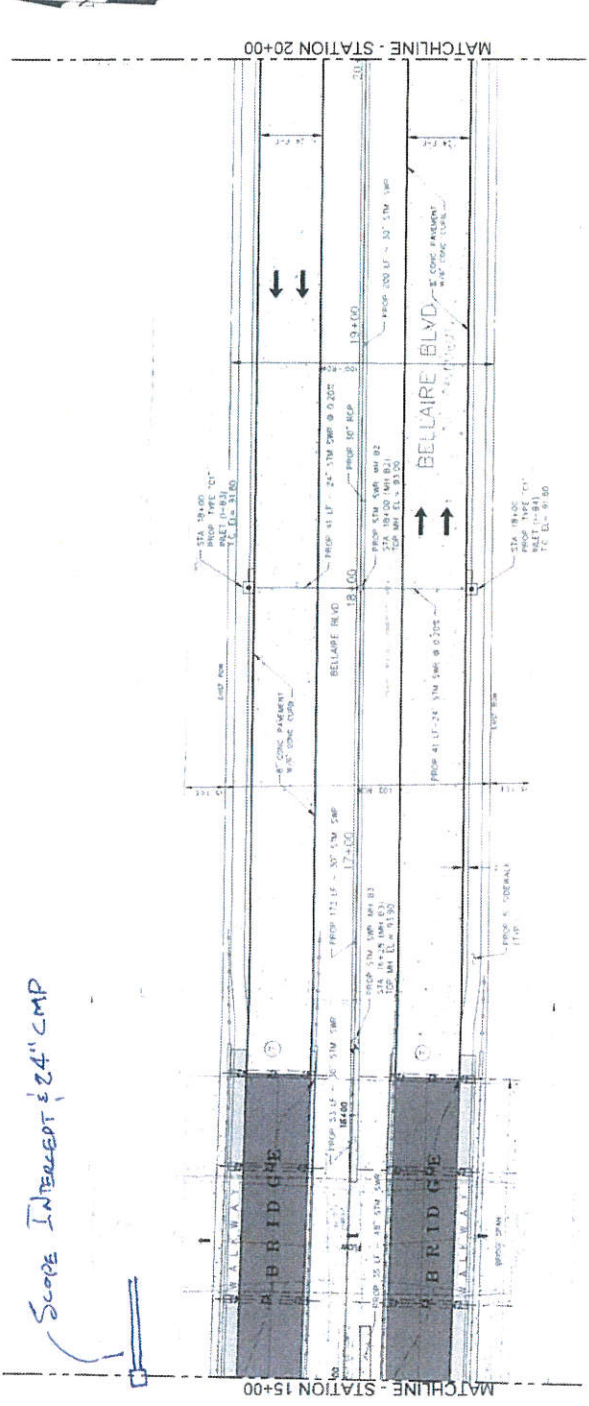

BELLAIRE BOULEVARD - (100' ROW)

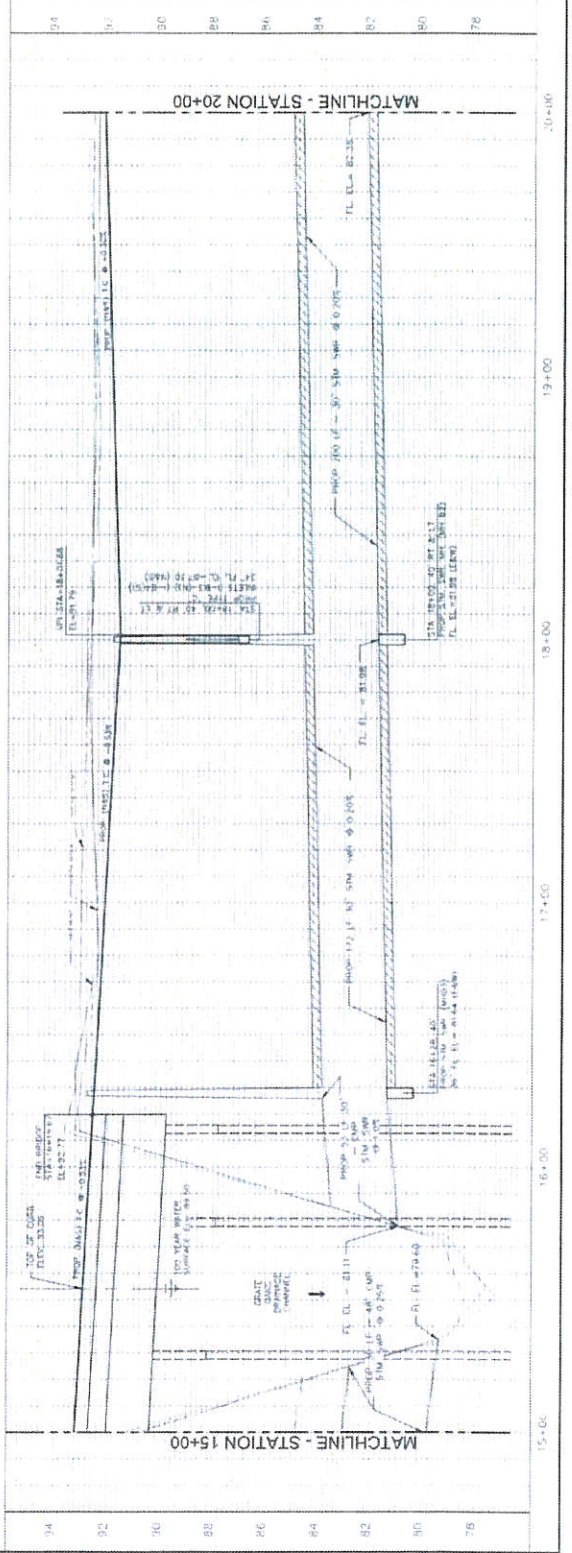

NOTES:

1. FURNISH AND INSTALL 24" CONCRETE PIPE (CMP) FOR INTERCEPT OF EXISTING PAVEMENT TO EXISTING CURBLINE. PAVEMENT TO BE REPAIRED TO EXISTING CONDITION.
2. EXISTING AND PROPOSED 24" CONCRETE PIPE (CMP) SHALL BE INSTALLED AT 10' SPACING.
3. EXISTING AND PROPOSED 24" CONCRETE PIPE (CMP) SHALL BE INSTALLED AT 10' SPACING.
4. EXISTING AND PROPOSED 24" CONCRETE PIPE (CMP) SHALL BE INSTALLED AT 10' SPACING.
5. EXISTING AND PROPOSED 24" CONCRETE PIPE (CMP) SHALL BE INSTALLED AT 10' SPACING.
6. EXISTING AND PROPOSED 24" CONCRETE PIPE (CMP) SHALL BE INSTALLED AT 10' SPACING.
7. EXISTING AND PROPOSED 24" CONCRETE PIPE (CMP) SHALL BE INSTALLED AT 10' SPACING.
8. EXISTING AND PROPOSED 24" CONCRETE PIPE (CMP) SHALL BE INSTALLED AT 10' SPACING.
9. EXISTING AND PROPOSED 24" CONCRETE PIPE (CMP) SHALL BE INSTALLED AT 10' SPACING.
10. EXISTING AND PROPOSED 24" CONCRETE PIPE (CMP) SHALL BE INSTALLED AT 10' SPACING.
11. EXISTING AND PROPOSED 24" CONCRETE PIPE (CMP) SHALL BE INSTALLED AT 10' SPACING.
12. EXISTING AND PROPOSED 24" CONCRETE PIPE (CMP) SHALL BE INSTALLED AT 10' SPACING.
13. EXISTING AND PROPOSED 24" CONCRETE PIPE (CMP) SHALL BE INSTALLED AT 10' SPACING.
14. EXISTING AND PROPOSED 24" CONCRETE PIPE (CMP) SHALL BE INSTALLED AT 10' SPACING.
15. EXISTING AND PROPOSED 24" CONCRETE PIPE (CMP) SHALL BE INSTALLED AT 10' SPACING.
16. EXISTING AND PROPOSED 24" CONCRETE PIPE (CMP) SHALL BE INSTALLED AT 10' SPACING.
17. EXISTING AND PROPOSED 24" CONCRETE PIPE (CMP) SHALL BE INSTALLED AT 10' SPACING.
18. EXISTING AND PROPOSED 24" CONCRETE PIPE (CMP) SHALL BE INSTALLED AT 10' SPACING.
19. EXISTING AND PROPOSED 24" CONCRETE PIPE (CMP) SHALL BE INSTALLED AT 10' SPACING.
20. EXISTING AND PROPOSED 24" CONCRETE PIPE (CMP) SHALL BE INSTALLED AT 10' SPACING.

LEGEND:

- EXISTING CURBLINE
- PROPOSED CURBLINE
- EXISTING 24" CONCRETE PIPE
- PROPOSED 24" CONCRETE PIPE

BELLAIRE BLVD FROM FM 1464 TO SAN PABLO DRIVE

BELLAIRE BLVD PLAN AND PROFILE

STA 15+00 TO STA 20+00

PREPARED BY: P.C.M. ENGINEERS, P.C.

DATE: 10/10/10

SCALE: 1" = 10' (PLAN), 1" = 10' (PROFILE)

PROJECT: 100' ROW

DATE: 10/10/10

PROJECT: 100' ROW

