



REVIEW BY FORT BEND COUNTY
COMMISSIONERS COURT

**Fort Bend County
Engineering Department**
301 Jackson Suite 401
Richmond, Texas 77469
281.633.7500
Permits@fortbendcountytexas.gov

☒	Right of Way Permit
☐	Commercial Driveway Permit

Permit No: 2018-19973

Applicant: G&A Boring Direccional

Job Location Site: FM 1464, Houston, TX 77083

Bond No.		Date of Bond:	5/8/2018	Amount:	\$50,000.00
-----------------	---	----------------------	-----------------	----------------	--------------------

The above applicant came to make use of certain Fort Bend County property subject to, "The Order Regulating the Laying, Construction, Maintenance, and Repair of Buried Cables, Conduits, and Pole Lines, In, Under, Across or Along Roads, Streets, Highways, and Drainage Ditches in Fort Bend County, Texas, Under the Jurisdiction of the Commissioners Court of Fort Bend County, Texas," as passed by the Commissioners Court of Fort Bend County, Texas, of the Minutes of the Commissioners Court of Fort Bend County, Texas, to the extent that such order is not inconsistent with Chapter 181, Vernon's Texas Statutes and Codes Annotated.

Notes:

1. Evidence of review by the Commissioners Court must be kept on the job site and failure to do so constitutes grounds for job shutdown.
2. Written notices are required:
 - a. 48 hours in advance of construction start up, and
 - b. When construction is completed and ready for final inspection, submit notification to Permit Administrator thru [MyGovernmentOnline.org](https://mygovernmentonline.org) portal.
3. This permit expires one (1) year from date of permit if construction has not commenced.

On this 24th day of April, 2018, Upon Motion of Commissioner _____, seconded by Commissioner _____, duly put and carried, it is ORDERED, ADJUDGED AND DECREED that said notice of said above purpose is hereby acknowledged by the Commissioners Court of Fort Bend County, Texas, and that said notice be placed on record according to the regulation order thereof.

Signature

Presented to Commissioners Court and approved.

By:

Rick J. Staigle, PE, PTOE
County Engineer

Date Recorded _____ Comm. Court No. _____

Clerk of Commissioners Court

N/A

By:

Drainage District Engineer/Manager

By:

Deputy



**PERMIT APPLICATION REVIEW FORM FOR
CABLE, CONDUIT, AND POLE LINE ACTIVITY
IN FORT BEND COUNTY**

**Fort Bend County
Engineering Department**
301 Jackson Suite 401
Richmond, Texas 77469
281.633.7500
Permits@fortbendcountytx.gov

- ☒ **Right of Way Permit**
☐ **Commercial Driveway Permit**

Permit No: 2018-19973

The following "Notice of Proposed Cable, Conduit, and/or Pole Line activity in Fort Bend County" and accompanying attachments have been reviewed and the notice conforms to appropriate regulations set by Commissioner's Court of Fort Bend County, Texas.

(1) COMPLETE APPLICATION FORM:

- ☒ a. Name of road, street, and/or drainage ditch affected.
☒ b. Vicinity map showing course of directions
☒ c. Plans and specifications

(2) BOND:

- ☐ County Attorney, approval when applicable.
- ☒ Perpetual bond currently posted. Bond No: Amount: \$50,000.00
- ☐ Performance bond submitted. Bond No: Amount:
- ☐ Cashier's Check Check No: Amount:

(3) DRAINAGE DISTRICT APPROVAL (WHEN APPLICABLE):

Drainage District Approval

Date

We have reviewed this project and agree it meets minimum requirements.

Rich J. Staigle, PE, PTOE
Permit Administrator

4/13/2018

Date

SHEET NO. 1 OF 12 SHEETS


GENERAL CONSTRUCTION NOTES: 1. CONTRACTOR SHALL MAINTAIN ADEQUATE DRAINAGE AT ALL TIMES DURING CONSTRUCTION... 2. CONTRACTOR SHALL OBTAIN ALL PERMITS REQUIRED BY THE CITY OF HOUSTON FOR CONSTRUCTION OF UTILITY LINES AND/OR OILWELLS WITHIN THE CITY... 3. CONTRACTOR TO OBTAIN ALL PERMITS REQUIRED BY REGULATION OF FORT BEND COUNTY FOR CONSTRUCTION OF FORT BEND COUNTY FLOOD PLAN MAINTENANCE.

 
WATER DISTRIBUTION NOTES: 1. WATER MAIN/SEWER CONSTRUCTION SHALL BE IN ACCORDANCE WITH CITY OF HOUSTON STANDARDS AND SPECIFICATIONS FOR WATER MAINS AND SEWERS... 2. ALL UTILITIES SHOWN ON THE DRAWINGS ARE SHOWN AT THE APPROXIMATE LOCATIONS BASED ON THE BEST AVAILABLE INFORMATION... 3. CONTRACTOR SHALL CONSTRUCT THE PROPOSED WATER MAINS WITH THE SPECIFICATIONS RELATING TO EXCAVATION, TRENCHING AND BACKFILL FOR WATER MAINS.


PIPELINE INFORMATION: HOUSTON PIPELINE CONTRACT: CARPENT 281-850-1417 (FIELD) CONTACT: KAREN DODD 632-688-1137 (PLANS) NETCO PIPELINE CONTRACT: ROBERT PILES 989-815-3184 (FIELD) MONUMENT PIPELINE CONTRACT: JOSE BOWLER 632-461-4288 (FIELD) KRODER MORGAN PIPELINE CONTRACT: MIKE LUNA 713-838-9646 (FIELD)

WATER DISTRIBUTION SYSTEM GENERAL CONSTRUCTION NOTES: 1. THE LOCATIONS OF WATERMAIN FACILITIES ARE SHOWN IN AN APPROPRIATE MANNER ONLY... 2. THE CONTRACTOR SHALL NOTIFY THE CITY OF HOUSTON OF ANY EXISTING UTILITIES... 3. WHEN EXCAVATING WITHIN EXISTING HOUSING (18") OF THE EXISTING WATERMAIN FACILITIES... 4. WHEN EXCAVATING WITHIN EXISTING HOUSING (18") OF THE EXISTING WATERMAIN FACILITIES... 5. WHEN EXCAVATING WITHIN EXISTING HOUSING (18") OF THE EXISTING WATERMAIN FACILITIES...

GENERAL NOTES: 1. ALL INTERSECTIONS UTILIZING TRAFFIC CONTROL MEASURES SHALL HAVE A.D.A. WHEEL CHAIR RAMP INSTALLED... 2. ALL INTERSECTIONS UTILIZING TRAFFIC CONTROL MEASURES SHALL HAVE A.D.A. WHEEL CHAIR RAMP INSTALLED... 3. ALL INTERSECTIONS UTILIZING TRAFFIC CONTROL MEASURES SHALL HAVE A.D.A. WHEEL CHAIR RAMP INSTALLED...

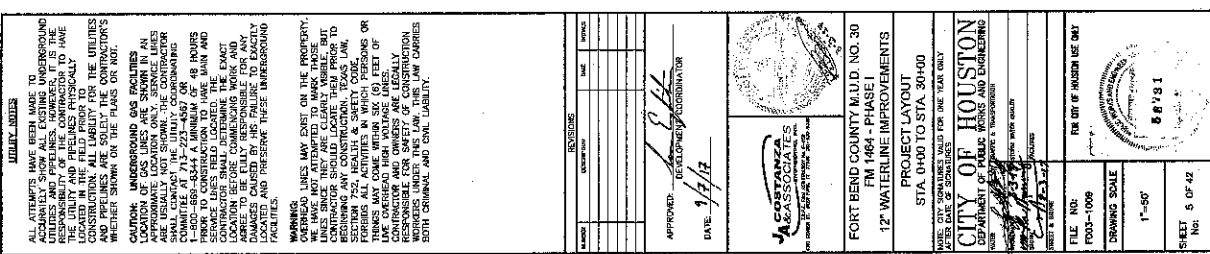




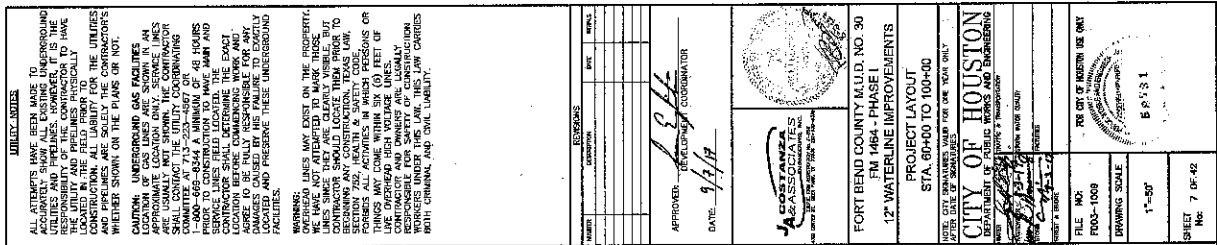

DATE: 10/15/2017
TIME: 10:00 AM
PROJECT: 1008-1009
SHEET: 1 OF 42

UTILITY NOTES

ALL UTILITIES SHOWN ARE BASED ON THE RECORD DRAWINGS AND FIELD SURVEY. THE CONTRACTOR SHALL VERIFY THE LOCATION AND DEPTH OF ALL UTILITIES PRIOR TO CONSTRUCTION. THE CITY OF HOUSTON SHALL NOT BE RESPONSIBLE FOR ANY DAMAGE TO UTILITIES OR PERSONS OR PROPERTY CAUSED BY THE CONSTRUCTION OF THIS PROJECT.

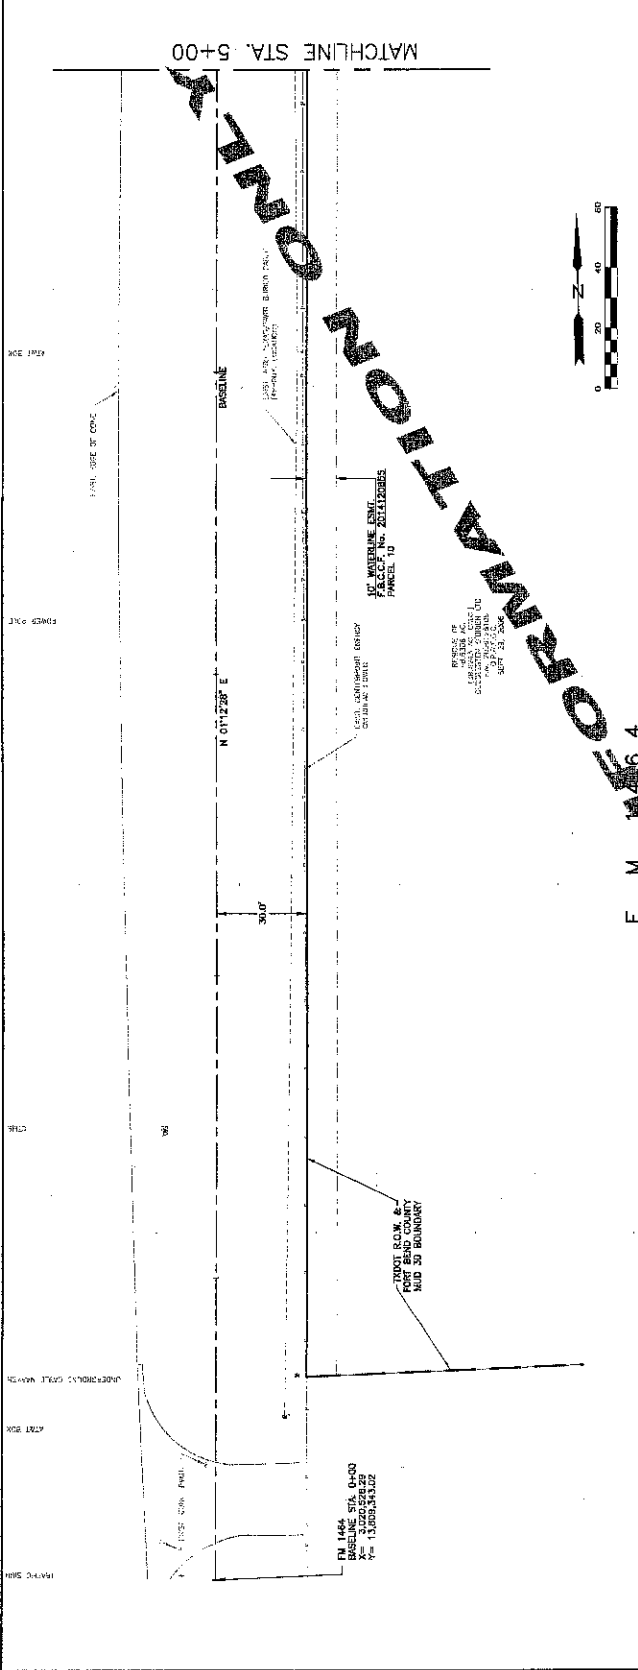

STATION	1+00	2+00	3+00	4+00	5+00
96					
94					
92					
90					
88					
86					
84					
82					
80					

FOR THE CITY OF HOUSTON
DEPARTMENT OF PUBLIC WORKS AND ENGINEERING
12" WATERLINE IMPROVEMENTS
PLAN & PROFILE
STA. 0+00 TO STA. 5+00
F. M. 1464 - PHASE I
FORT BEND COUNTY M.U.D. NO. 30

APPROVED: [Signature]
DATE: 10/15/2017

FOR THE CITY OF HOUSTON
DEPARTMENT OF PUBLIC WORKS AND ENGINEERING
12" WATERLINE IMPROVEMENTS
PLAN & PROFILE
STA. 0+00 TO STA. 5+00
F. M. 1464 - PHASE I
FORT BEND COUNTY M.U.D. NO. 30

ALL ATTEMPTS HAVE BEEN MADE TO ACCURATELY SHOW ALL EXISTING UNDERGROUND UTILITIES AND PIPELINES. HOWEVER, IT IS THE RESPONSIBILITY OF THE CONTRACTOR TO HAVE THE UTILITY AND PIPELINES PHYSICALLY LOCATED IN THE FIELD PRIOR TO CONSTRUCTION. ALL LIABILITY FOR THE UTILITIES AND PIPELINES ARE SOLELY THE CONTRACTOR'S WHETHER SHOWN ON THE PLANS OR NOT.

CAUTION: UNDERGROUND GAS FACILITIES
LOCATION OF GAS LINES ARE SHOWN ON
APPROPRIATE LOCATION ONLY. SERVICE LINES
ARE USUALLY NOT SHOWN. THE CONTRACTOR
SHALL CONTACT THE UTILITY COORDINATING
COMMITTEE AT 713-223-1567 OR
1-800-668-6344 A MINIMUM OF 48 HOURS
PRIOR TO CONSTRUCTION TO HAVE MAN AND
SERVICE LINES FIELD LOCATED. THE
CONTRACTOR SHALL DETERMINE THE EXACT
LOCATION BEFORE COMMENCING WORK AND
BEFORE ANY TRENCHING. ANY DAMAGE TO
GAS LINES CAUSED BY THE FAILURE TO EXACTLY
LOCATE AND PRESERVE THESE UNDERGROUND
FACILITIES.

WARNING: OVERHEAD LINES MAY EXIST ON THE PROPERTY. WE HAVE NOT ATTEMPTED TO MARK THOSE LINES SINCE WE DO NOT HAVE ACCESS TO THE RECORDS OF THE UTILITY COMPANIES. YOU SHOULD CONTACT THE UTILITY COMPANIES TO DETERMINE THE LOCATION OF ANY OVERHEAD LINES. CONSTRUCTION, TEXAS LAW, SECTION 752, HEALTH & SAFETY CODE, PROHIBITS ALL ACTIVITIES IN WHICH PERSONS OR THINGS ARE COME WITHIN SIX (6) FEET OF HIGH VOLTAGE LINES. CONTRACTOR AND OWNERS ARE LEGALLY RESPONSIBLE FOR SAFETY OF CONSTRUCTION WORKERS UNDER THIS LAW. THIS LAW CARRIES BOTH CRIMINAL AND CIVIL LIABILITY.

[illegible]

APPROVED: Sean L. [Signature]
DEVELOPMENT COORDINATOR

DATE: 9/2/17



FORT BEND COUNTY M.U.D. NO. 30
FM 1484 - PHASE I
12" WATERLINE IMPROVEMENTS

PLAN & PROFILE
STA 5+00 TO STA 10+00

NOTE: CITY SIGNATURES VALID FOR ONE YEAR ONLY
 IF DATE OF SIGNATURE

CITY OF HOUSTON
DEPARTMENT OF PUBLIC WORKS AND ENGINEERING

ALTIMO KERN, MOORE
DAVID
MAY 1962

16-3-17
16-3-17
16-3-17


FILE NO:	FOR CITY OF HOUSTON USE ONLY
DATE:	

DRAWING SCALE


HORIZ.: 1"=20'
VERT.: 1"=2'

100

No:	9 OF-42
-----	---------

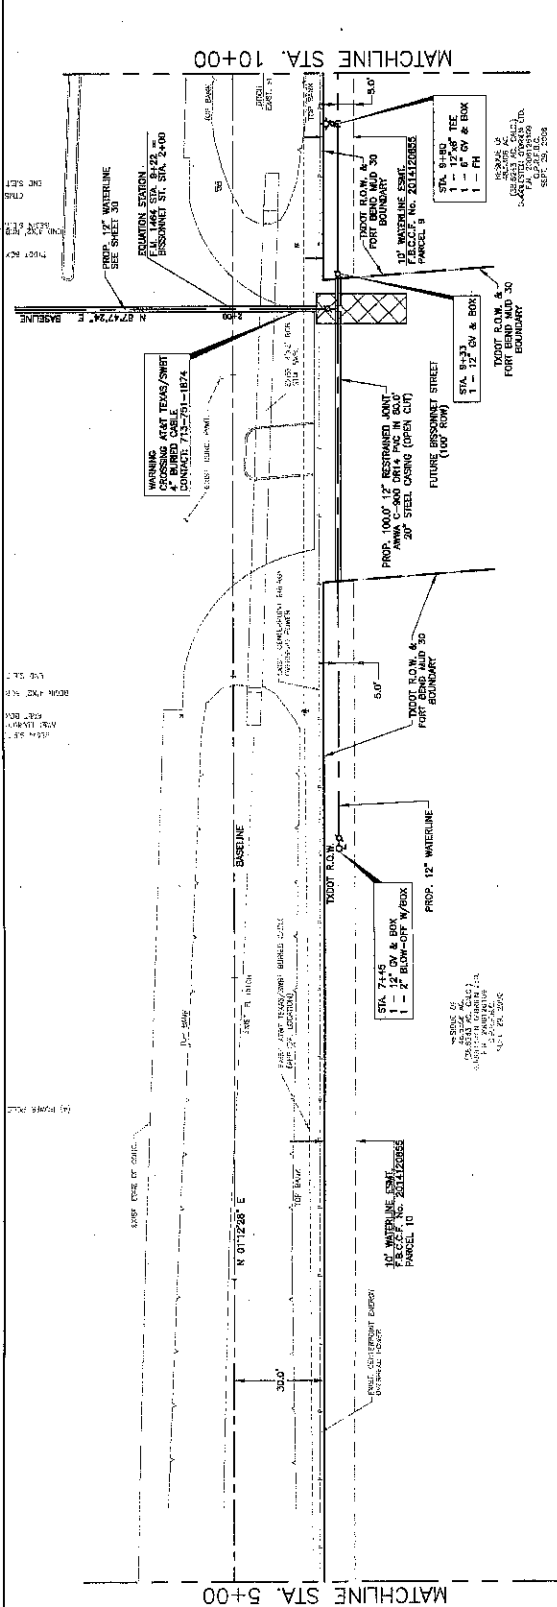

F. M. 1464

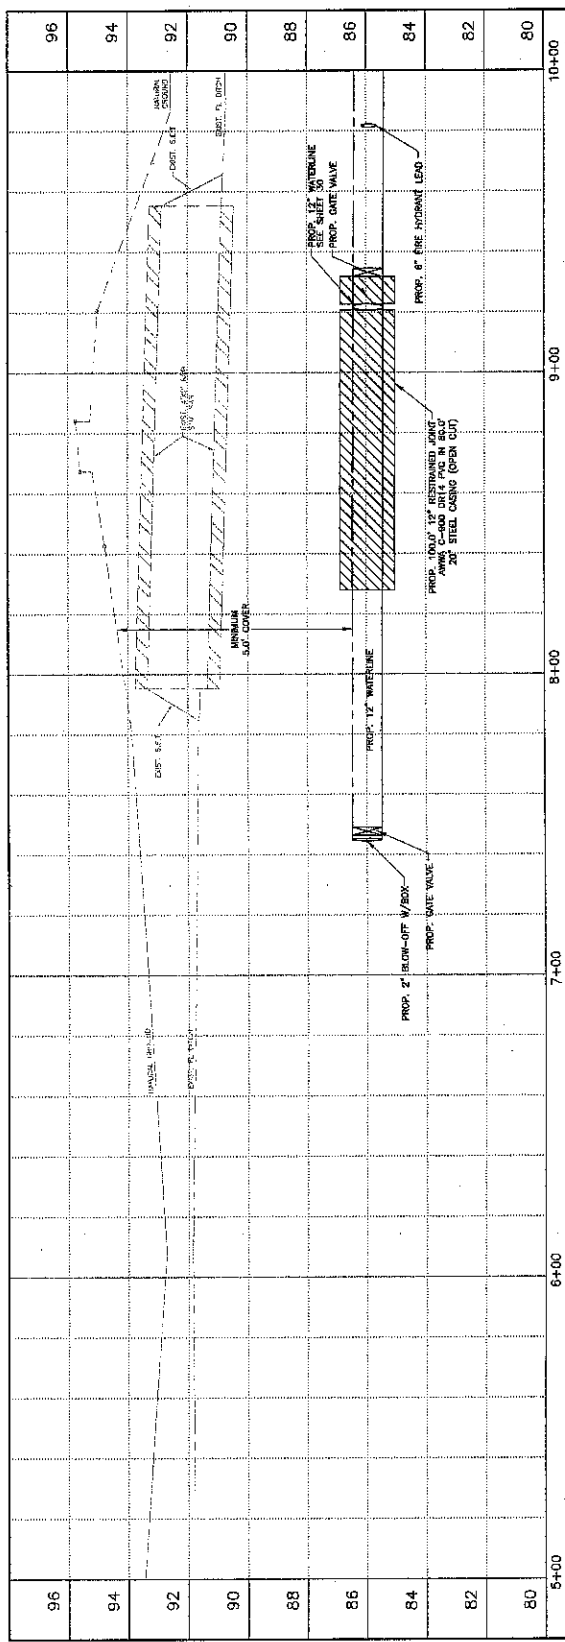

UTILITY NOTES

ALL UTILITIES HAVE BEEN MAINTAINED TO ACCORDANCE WITH ALL EXISTING UNDERGROUND UTILITIES AND PRELIMINARY CONSTRUCTION. THE UTILITY AND PRELIMINARY CONSTRUCTION OF THE UNDERGROUND UTILITIES SHALL BE THE RESPONSIBILITY OF THE CONTRACTOR. ALL UTILITIES FOR THE UTILITIES AND PRELIMINARY CONSTRUCTION OF THE UNDERGROUND UTILITIES SHALL BE THE RESPONSIBILITY OF THE CONTRACTOR. ALL UTILITIES FOR THE UTILITIES AND PRELIMINARY CONSTRUCTION OF THE UNDERGROUND UTILITIES SHALL BE THE RESPONSIBILITY OF THE CONTRACTOR.

WARNING: LINES MAY EXIST ON THE PROPERTY. WE HAVE NOT ATTEMPTED TO MARK THESE LINES. THE CONTRACTOR SHALL BE RESPONSIBLE FOR MARKING THESE LINES. THE CONTRACTOR SHALL BE RESPONSIBLE FOR MARKING THESE LINES. THE CONTRACTOR SHALL BE RESPONSIBLE FOR MARKING THESE LINES.


APPROVED: *[Signature]*
DATE: 9/17/17


FOR CITY OF HOUSTON USE ONLY

FILE NO: 1000-1000
DRAWING SCALE: 1"=20'
SHEET NO: 10 OF 42

COSTANZA & ASSOCIATES
10000 WEST 15TH STREET, SUITE 100
HOUSTON, TEXAS 77058

FORT BEND COUNTY M.U.D. NO. 30
FM 1464 - PHASE I
12" WATERLINE IMPROVEMENTS
PLAN & PROFILE
STA. 10+00 TO STA. 15+00

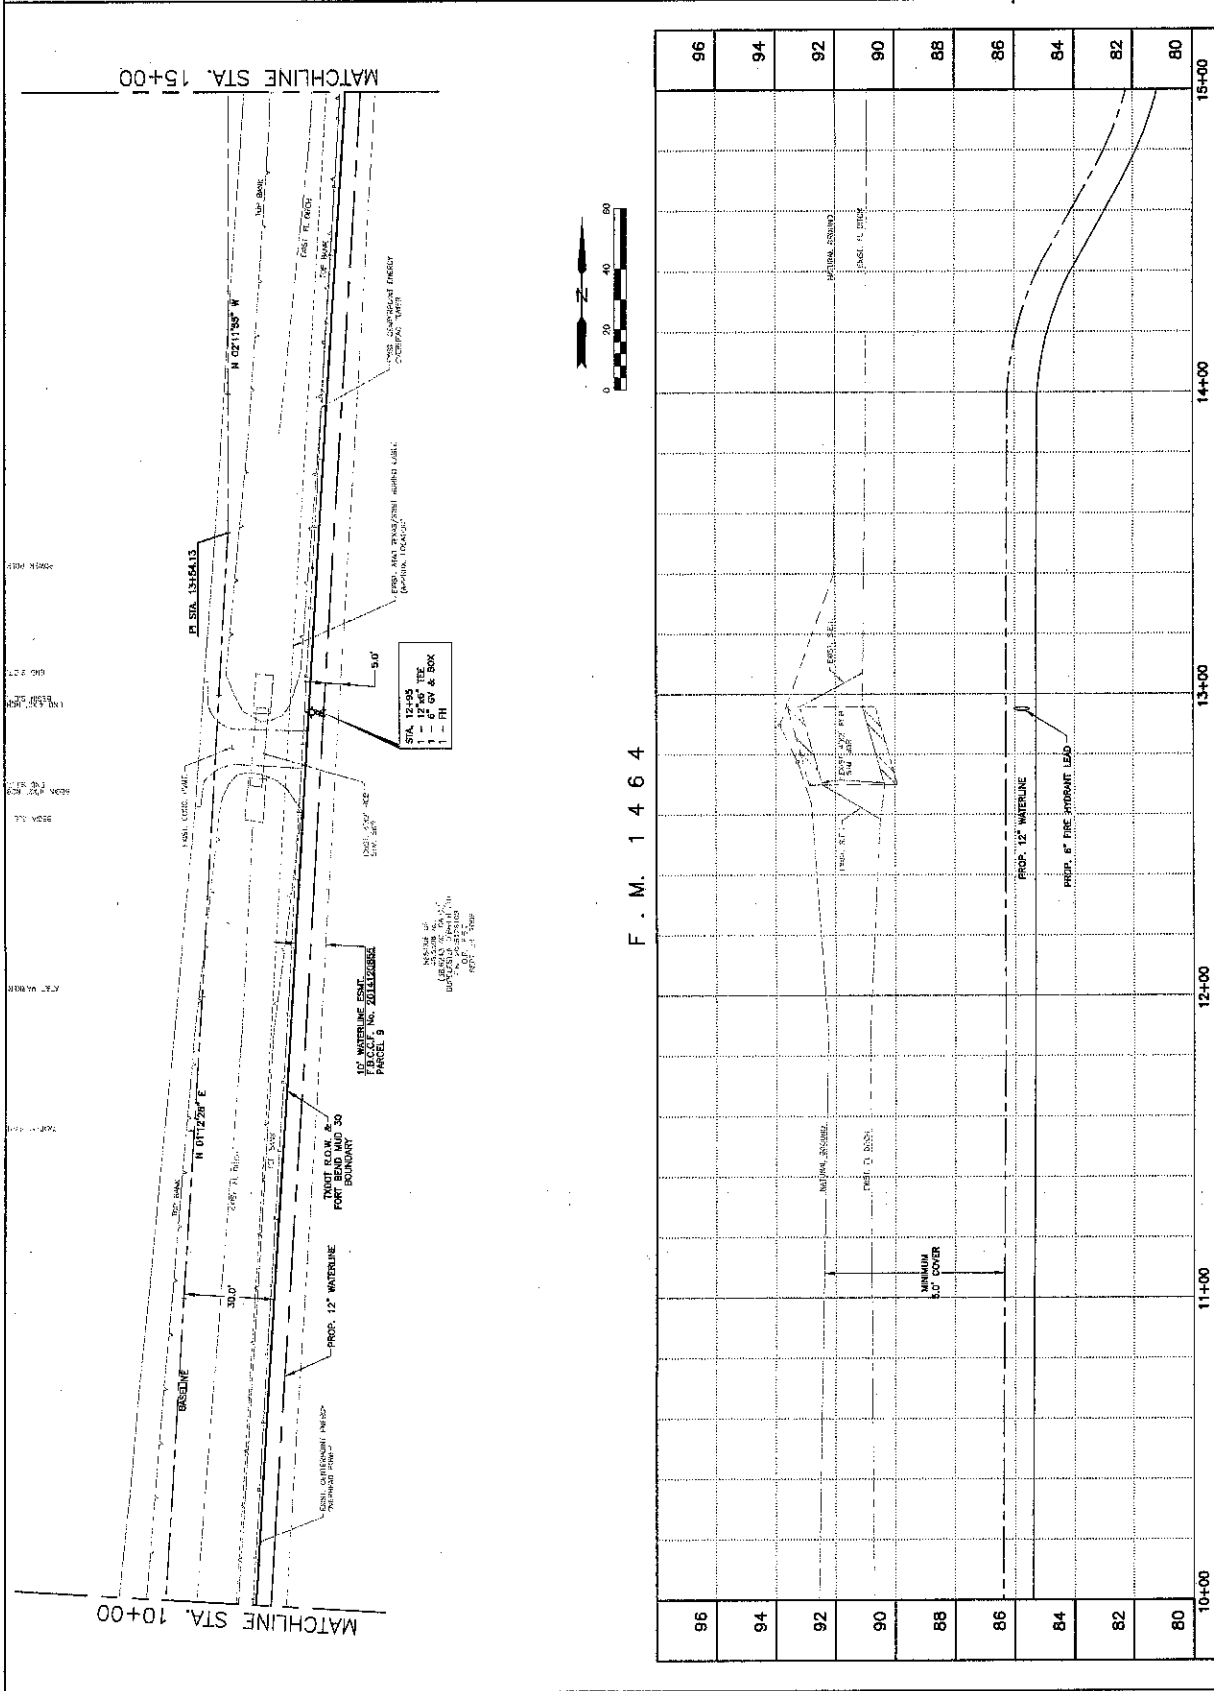

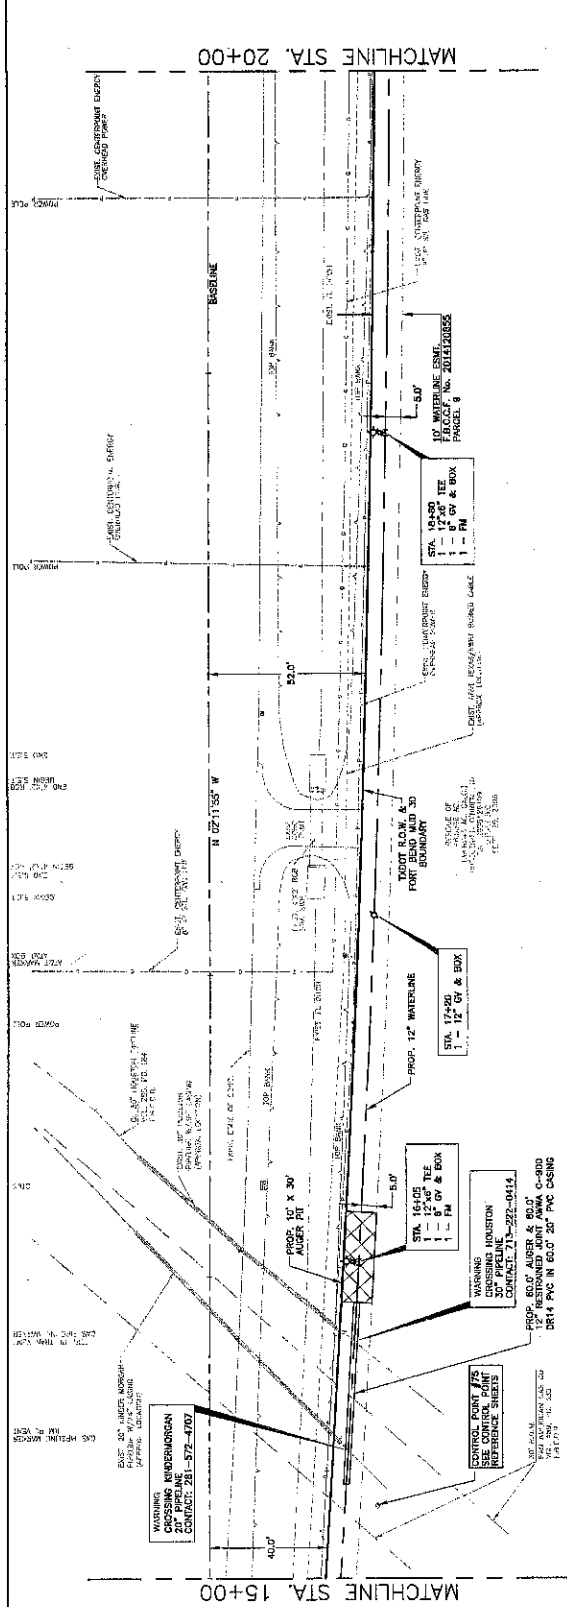

96	96	15+00	18+00	17+00	19+00	20+00
94	94					
92	92					
90	90					
88	88					
86	86					
84	84					
82	82					
80	80					

UTILITY NOTES

ALL ATTEMPTS HAVE BEEN MADE TO ACCURATELY SHOW ALL EXISTING UNDERGROUND UTILITIES AND PIPELINES. HOWEVER, IT IS THE RESPONSIBILITY OF THE CONTRACTOR TO HAVE THE UTILITY AND PIPELINES PHYSICALLY LOCATED IN THE FIELD PRIOR TO CONSTRUCTION. ALL LIABILITY FOR THE UTILITIES AND PIPELINES ARE SOLELY THE CONTRACTOR'S WHETHER SHOWN ON THE PLANS OR NOT.

CAUTION: UNDERGROUND GAS FACILITIES. LOCATION OF GAS LINES ARE SHOWN BY AN INDICATED SYMBOL. THESE UNDERGROUND LINES ARE USUALLY NOT SHOWN. THE CONTRACTOR SHALL CONTRACT THE UTILITY COORDINATING COMMITTEE AT 713-223-4367 OR 1-800-569-8344, A MINIMUM OF 48 HOURS PRIOR TO CONSTRUCTION TO HAVE MAIN SERVICE LINES FIELD LOCATED. THE CONTRACTOR SHALL BE RESPONSIBLE FOR ANY DAMAGE CAUSED BY HIS FAILURE TO EXACTLY LOCATE AND PRESERVE THESE UNDERGROUND FACILITIES.

WARNINGS: OVERHEAD LINES MAY EXIST ON THE PROPERTY. WE HAVE NOT ATTEMPTED TO MARK THESE LINES SINCE THEY ARE CLEARLY VISIBLE, BUT THE CONTRACTOR SHOULD LOOK FOR THEM TO AVOID ANY DISTURBANCE. ITEMS: LAW, SECTION 752, LEADERS & SAFETY CODES FORBIDS ALL ACTIVITIES IN WHICH PERSONS OR THINGS MAY COME WITHIN 6' (6') FEET OF HIGH-VOLTAGE ELECTRICAL LINES.

THE CONTRACTOR AND OWNER ARE LEGALLY RESPONSIBLE FOR SAFETY OF CONSTRUCTION WORKERS UNDER THIS LAW. THIS LAW CARRIES BOTH CRIMINAL AND CIVIL LIABILITY.

[illegible]

APPROVED: [Signature] DEVELOPMENT COORDINATOR
DATE: 9/7/8



FORT BEND COUNTY M.U.D. NO. 30
FM 1464 - PHASE I -
12" WATERLINE IMPROVEMENTS

PLAN & PROFILE
STA. 15+00 TO STA. 20+00


[illegible]

FILE NO: F003-1009	DRAWING SCALE
-----------------------	---------------

FOR CITY OF HOUSTON USE ONLY

58731

100

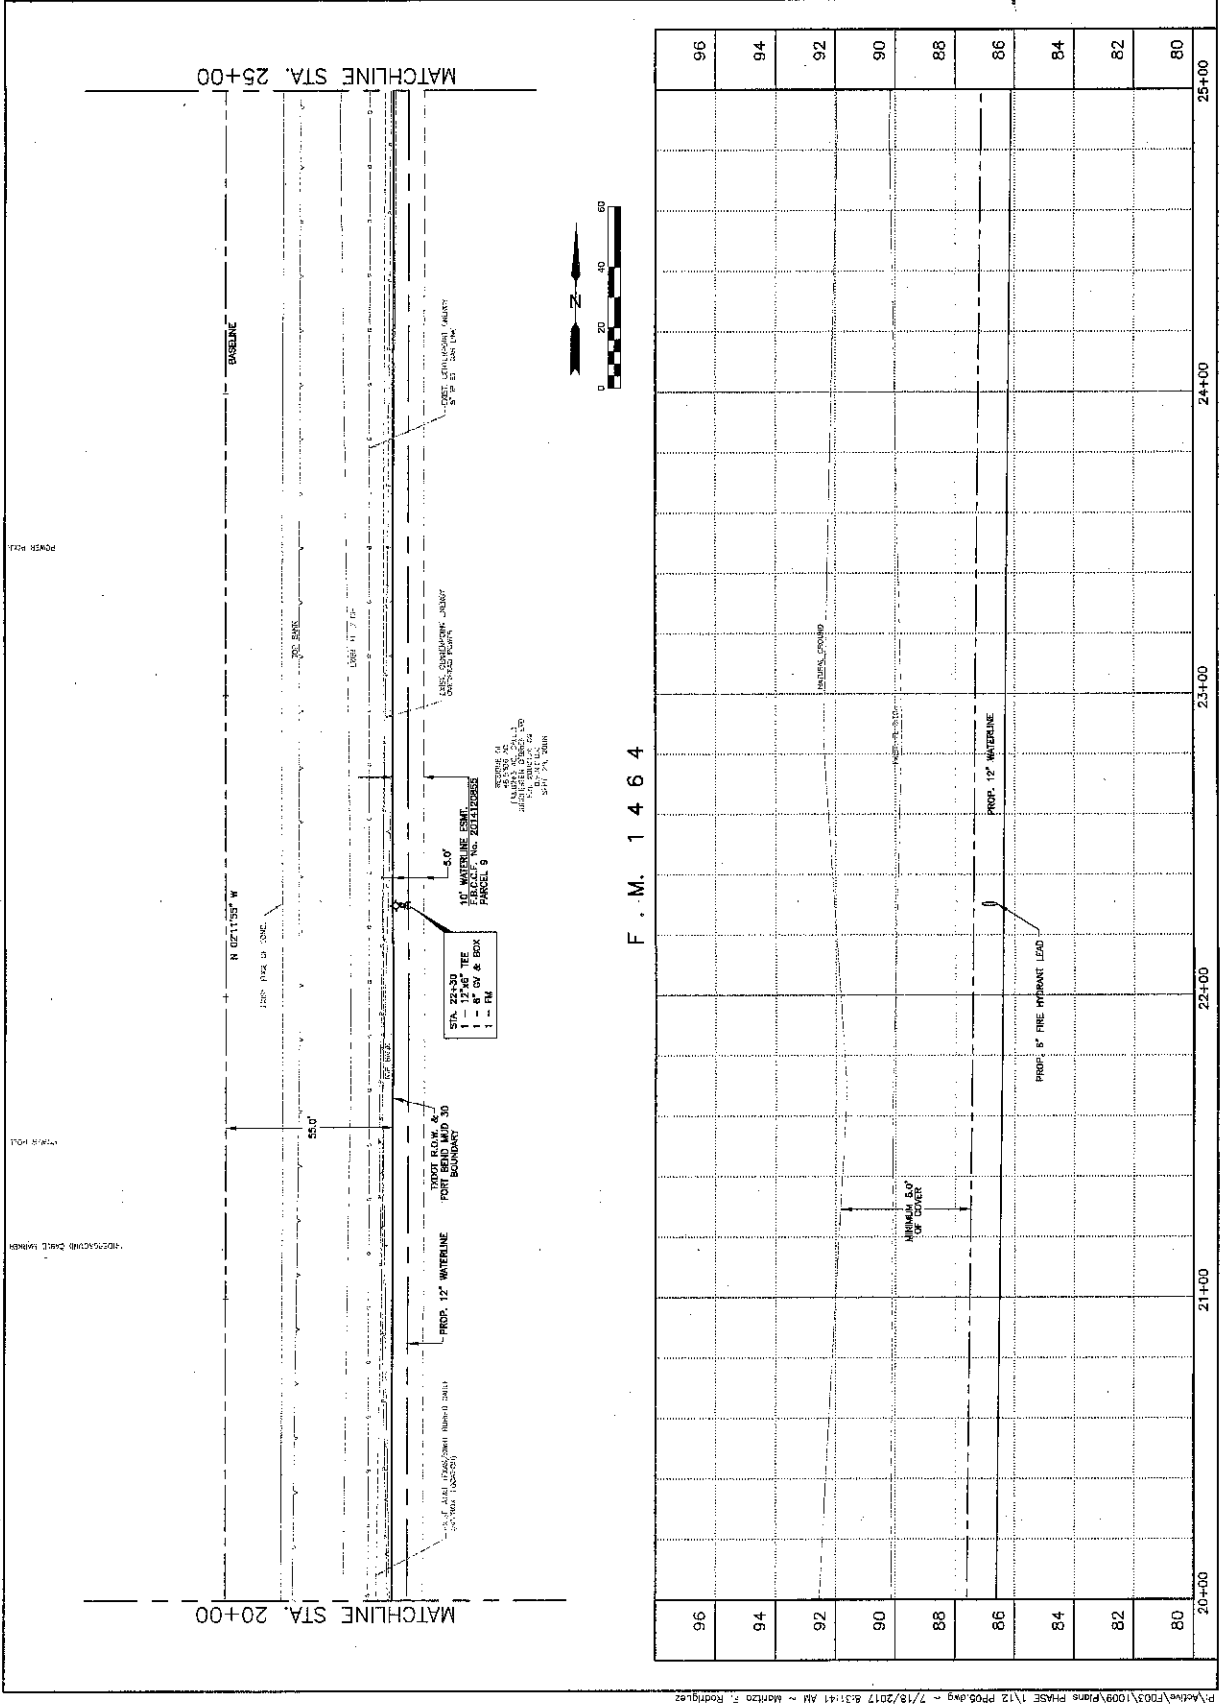[illegible]

UTILITY NOTES

ALL UTILITIES HAVE BEEN MADE TO ACCURATELY SHOW ALL EXISTING UNDERGROUND UTILITIES AND PRELIMINARIES. HOWEVER, IT IS THE RESPONSIBILITY OF THE USER TO VERIFY THE LOCATION AND DEPTH OF ALL UTILITIES PRIOR TO ANY CONSTRUCTION. THE USER SHALL BE RESPONSIBLE FOR THE SAFETY OF THE UTILITIES AND PIPELINES ARE SALES BY THE CONTRACTORS WHETHER SHOWN ON THE PLANS OR NOT.

CAUTION: UNDERGROUND GAS FACILITIES ARE NOT SHOWN ON THESE PLANS. THE CONTRACTOR SHALL BE RESPONSIBLE FOR THE SAFETY OF THE UTILITIES AND PIPELINES ARE SALES BY THE CONTRACTORS WHETHER SHOWN ON THE PLANS OR NOT.

UNDERGROUND GAS FACILITIES ARE NOT SHOWN ON THESE PLANS. THE CONTRACTOR SHALL BE RESPONSIBLE FOR THE SAFETY OF THE UTILITIES AND PIPELINES ARE SALES BY THE CONTRACTORS WHETHER SHOWN ON THE PLANS OR NOT.

WARNING: LINES MAY BE BURIED ON THE PROPERTY. LINES SHOULD BE CLEARLY MARKED, BUT WE HAVE NOT ATTEMPTED TO MARK THOSE BEGINNING ANY CONSTRUCTION. TEXAS LAW, SECTION 702, HEALTH & SAFETY CODES OR THINGS MAY COME WITHIN SIX (6) FEET OF THE OPERATOR OR VOLUNTARILY. THE USER SHALL BE RESPONSIBLE FOR THE SAFETY OF CONSTRUCTION. THE USER SHALL BE RESPONSIBLE FOR THE SAFETY OF CONSTRUCTION. THE USER SHALL BE RESPONSIBLE FOR THE SAFETY OF CONSTRUCTION.

APPROVED: *[Signature]*
DATE: 9/4/18


COSTANZA & ASSOCIATES
REGISTERED PROFESSIONAL ENGINEER
NO. 12547
STATE OF TEXAS

FORT BEND COUNTY MUD. NO. 30
FM 1464 - PHASE I
12" WATERLINE IMPROVEMENTS


PLAN & PROFILE
STA. 25+00 TO STA. 30+00

FILE NO. FMOO-1009
DRAWING SCALE
MODEL: 1"=20'
VERT: 1"=2'

IN CITY OF HOUSTON USE ONLY
58731
SHEET 13 OF 42

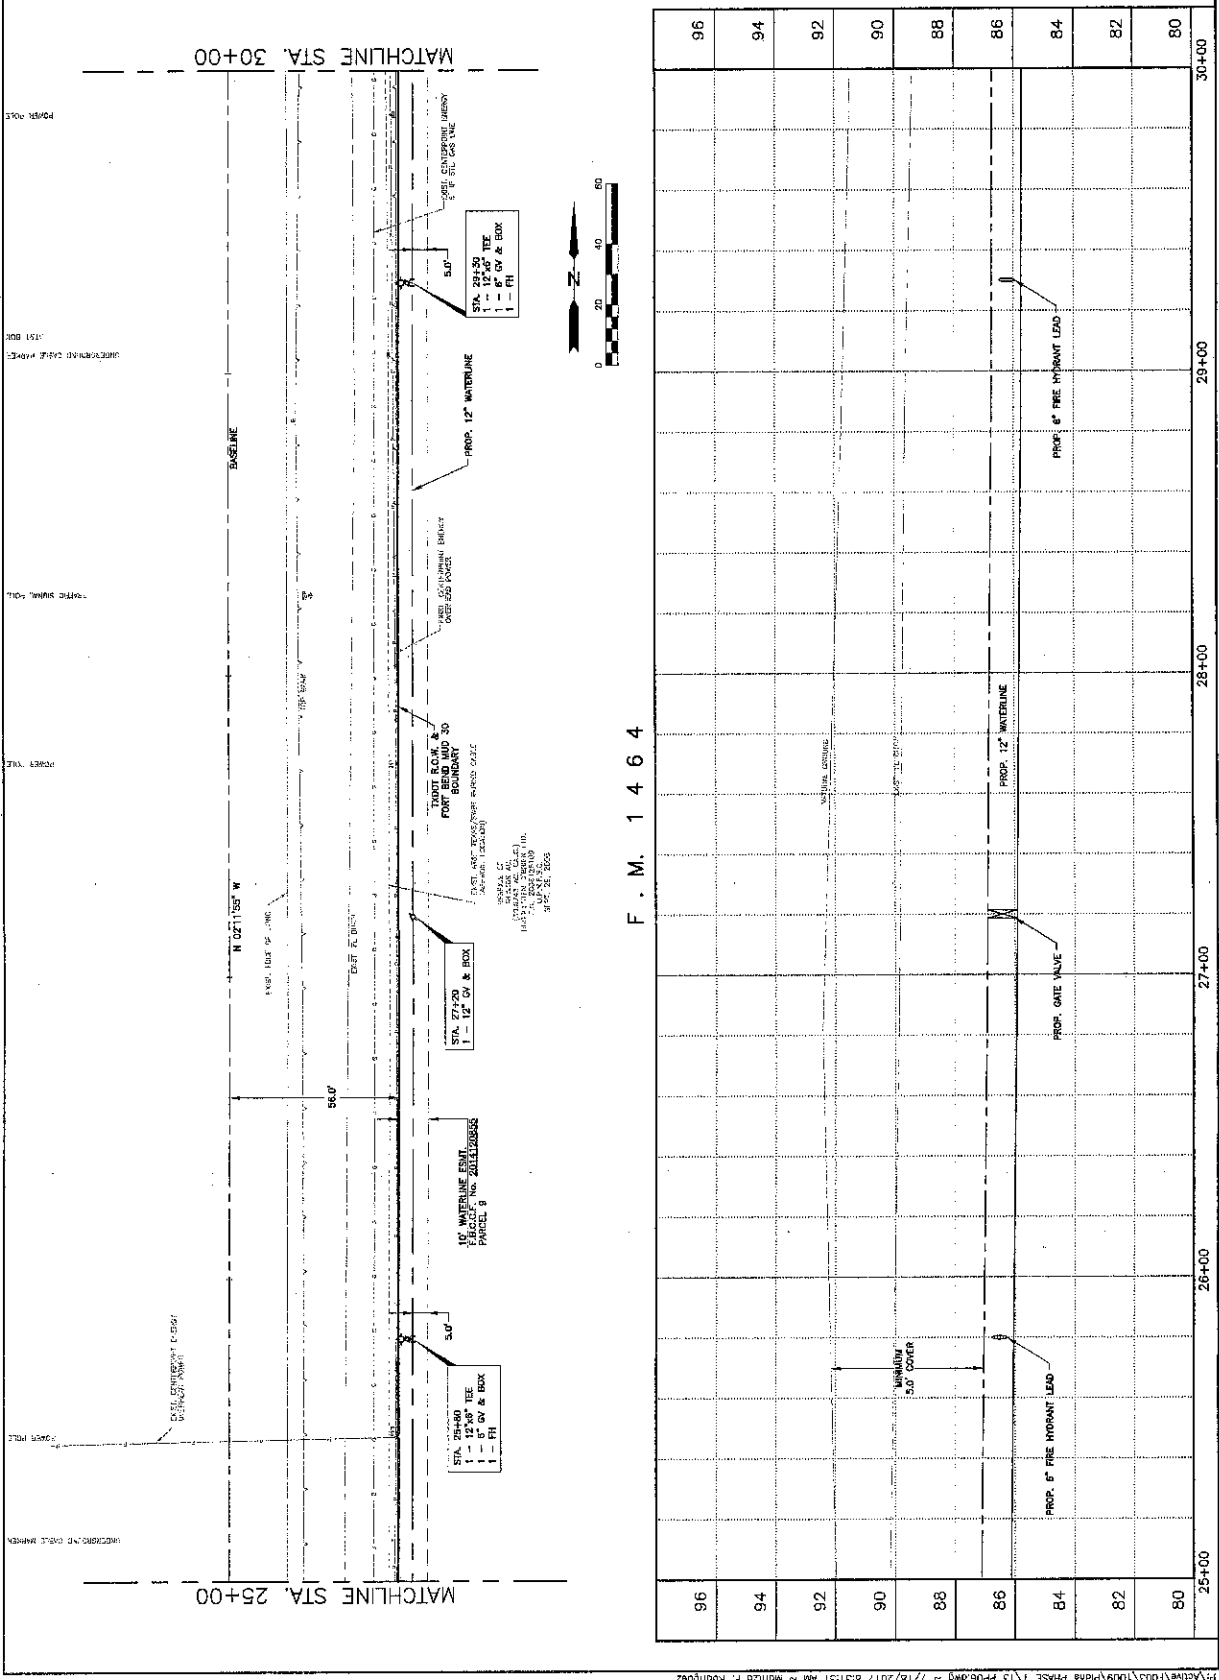

F. M. 1 4 6 4

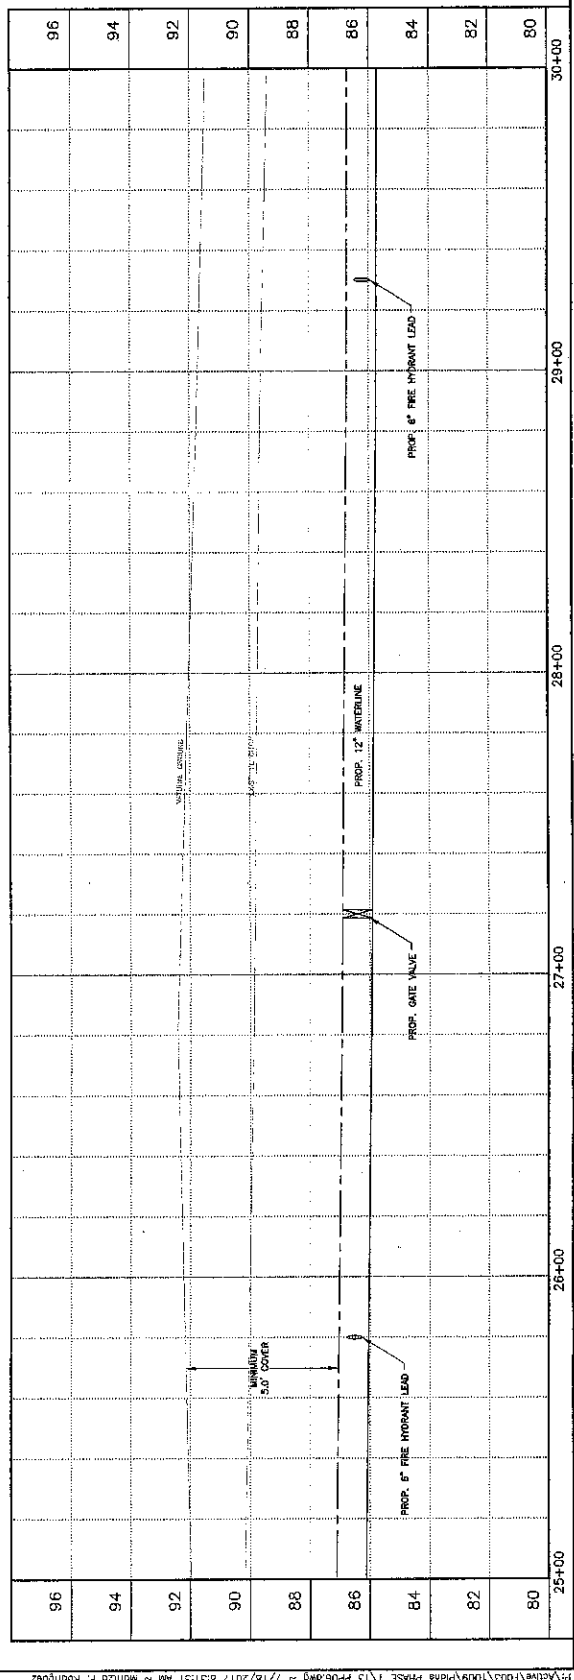

UTILITY NOTES

ALL ATTEMPTS HAVE BEEN MADE TO ACCURATELY SHOW ALL EXISTING UNDERGROUND UTILITIES. THE CONTRACTOR SHALL BE RESPONSIBLE FOR VERIFYING THE LOCATION AND DEPTH OF ALL UTILITIES PRIOR TO CONSTRUCTION. THE CONTRACTOR SHALL BE RESPONSIBLE FOR OBTAINING ALL NECESSARY PERMITS AND FOR PROTECTING ALL UTILITIES. THE CONTRACTOR SHALL BE RESPONSIBLE FOR OBTAINING ALL NECESSARY PERMITS AND FOR PROTECTING ALL UTILITIES. THE CONTRACTOR SHALL BE RESPONSIBLE FOR OBTAINING ALL NECESSARY PERMITS AND FOR PROTECTING ALL UTILITIES.


APPROVED: *[Signature]*
DATE: 1/17/17

COSTANZA ASSOCIATES, P.C.
1400 WEST 17TH STREET, SUITE 100
HOUSTON, TEXAS 77058

FORT BEND COUNTY M.U.D. NO. 30
FM 1464 - PHASE I
12" WATERLINE IMPROVEMENTS
PLAN & PROFILE
STA. 30+00 TO STA. 35+00

CITY OF HOUSTON
DEPARTMENT OF PUBLIC WORKS AND ENGINEERING
1000 WEST 17TH STREET, SUITE 100
HOUSTON, TEXAS 77058

FILE NO: 1000-1000
DRAWING SCALE: 1"=20'
SHEET 14 OF 42

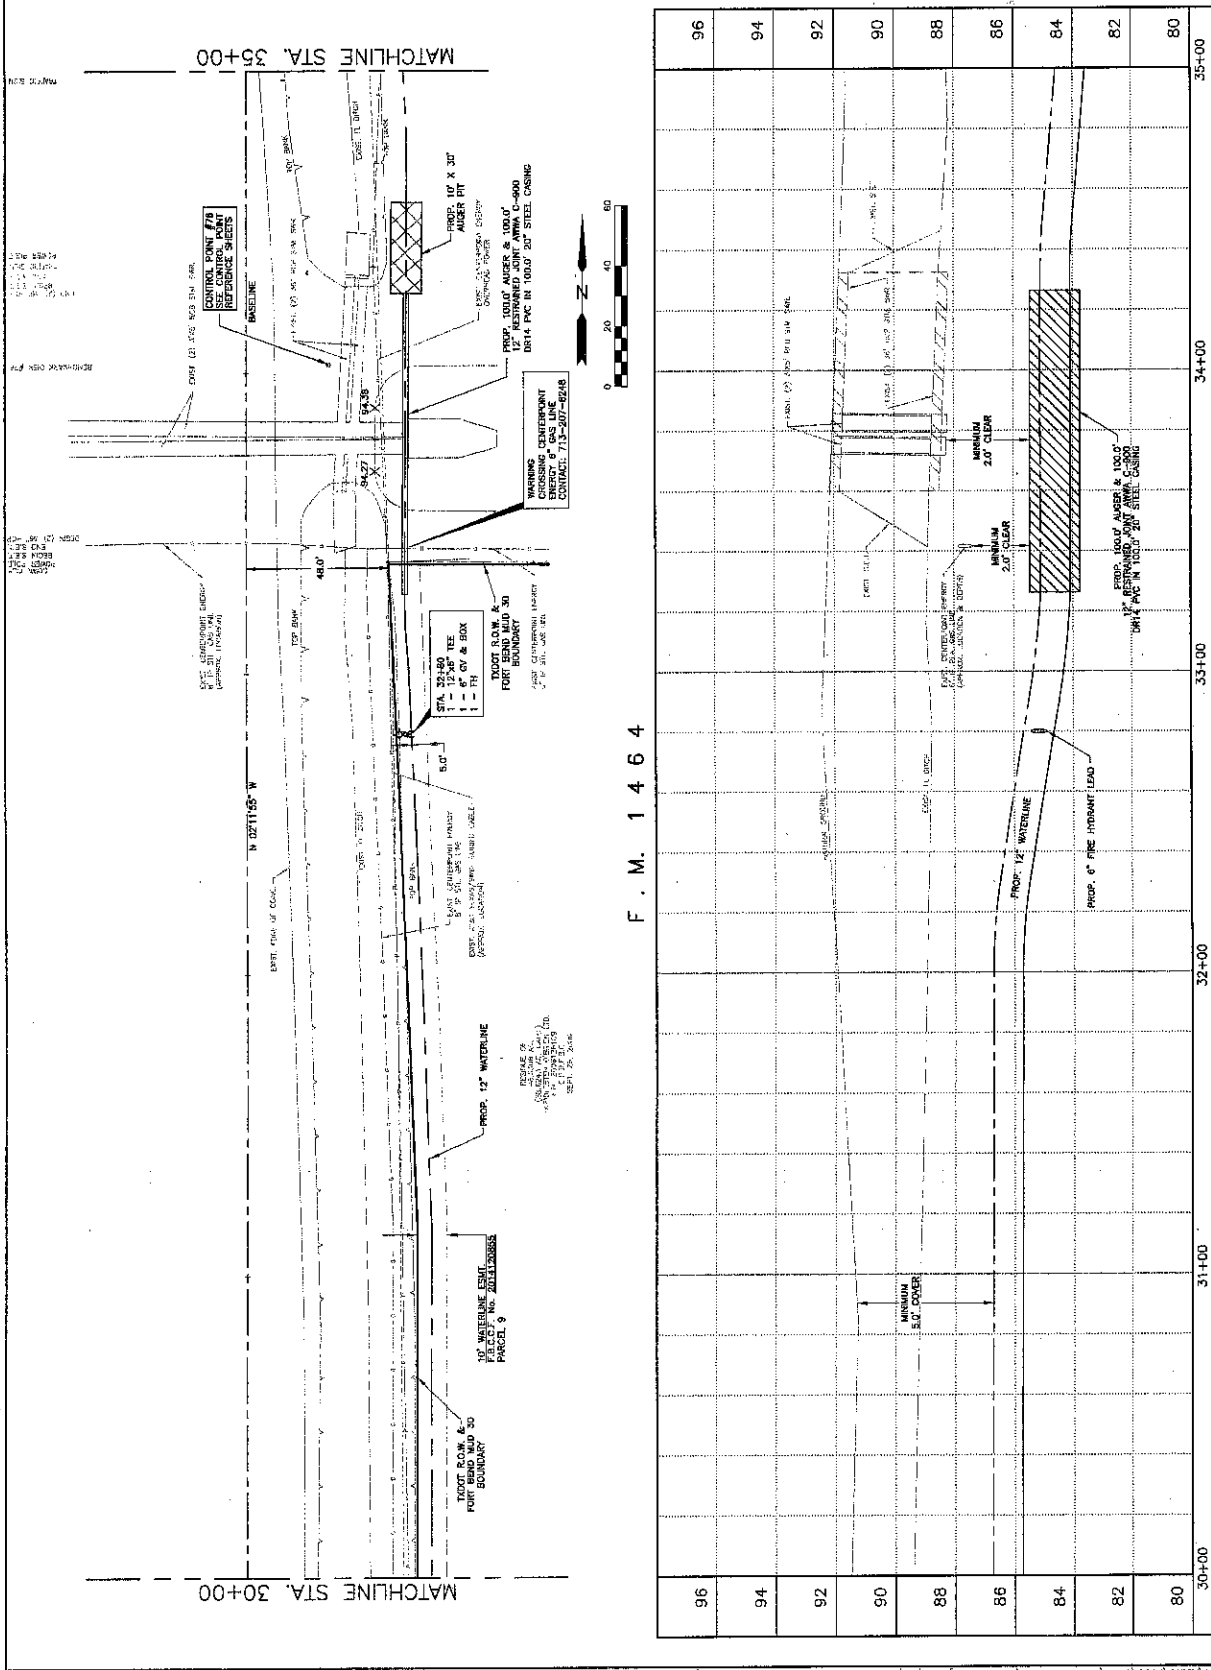

UTILITY NOTES

ALL ATTEMPTS HAVE BEEN MADE TO ACCURATELY SHOW ALL EXISTING UNDERGROUND UTILITIES AND STRUCTURES. THE CONTRACTOR SHALL BE RESPONSIBLE FOR THE UTILITY AND PRELIMS PHYSICALLY LOCATED IN THE FIELD PRIOR TO CONSTRUCTION. ALL LIABILITY FOR THE UTILITIES AND PRELIMS ARE SOLELY THE CONTRACTOR'S WHETHER SHOWN ON THE PLANS OR NOT.

CAUTION - UNDERGROUND GAS FACILITIES

UNDERGROUND GAS FACILITIES ARE AN APPROPRIATE LOCATION ONLY. SERVICE LINES SHALL BE LOCATED BY THE UTILITY COORDINATING COMMITTEE AT 713-223-4847 OR 48 HOURS PRIOR TO CONSTRUCTION TO HAVE MAIN AND SERVICE LINES EXPOSED. THE EXACT LOCATION BEFORE COMMENCING WORK AND CONSTRUCTION SHALL BE THE RESPONSIBILITY OF THE CONTRACTOR. THE CONTRACTOR SHALL BE RESPONSIBLE FOR THE FAILURE TO EXACTLY LOCATE AND PRESERVE THESE UNDERGROUND FACILITIES.

OWNED LINES MAY EXIST ON THE PROPERTY.

WE HAVE NOT ATTEMPTED TO MARK THESE LINES. THE CONTRACTOR SHALL BE RESPONSIBLE FOR LOCATING ANY CONSTRUCTION TEXAS LAW, FORBIDS ALL ACTIVITIES IN WHICH PERSONS OR THINGS MAY COME WITHIN 500 (500) FEET OF ANY EXISTING OR PROPOSED UNDERGROUND FACILITIES. CONTRACTOR AND OWNERS ARE LEGALLY RESPONSIBLE FOR ANY DAMAGE TO UNDERGROUND FACILITIES. THE CONTRACTOR SHALL BE RESPONSIBLE FOR BOTH CRIMINAL AND CIVIL LIABILITY.

APPROVED: *[Signature]*

DATE: 1/17/17

COSTANZA & ASSOCIATES

REGISTERED PROFESSIONAL ENGINEER


NO. 0001234567


FORT BEND COUNTY MUD. NO. 30
FM 1464 - PHASE 1
12" WATERLINE IMPROVEMENTS
PLAN & PROFILE
STA. 35+00 TO STA. 40+00

NOTE: CITY SHOWN HEREIN WAS FOR ONE YEAR ONLY AFTER DATE OF SUBMITTAL

CITY OF HOUSTON
DEPARTMENT OF PUBLIC WORKS AND ENGINEERING

FILE NO. 1000-1000
DRAWING SCALE: 1"=40'
POSTED: 1-17-17
SHEET NO. 19 OF 42

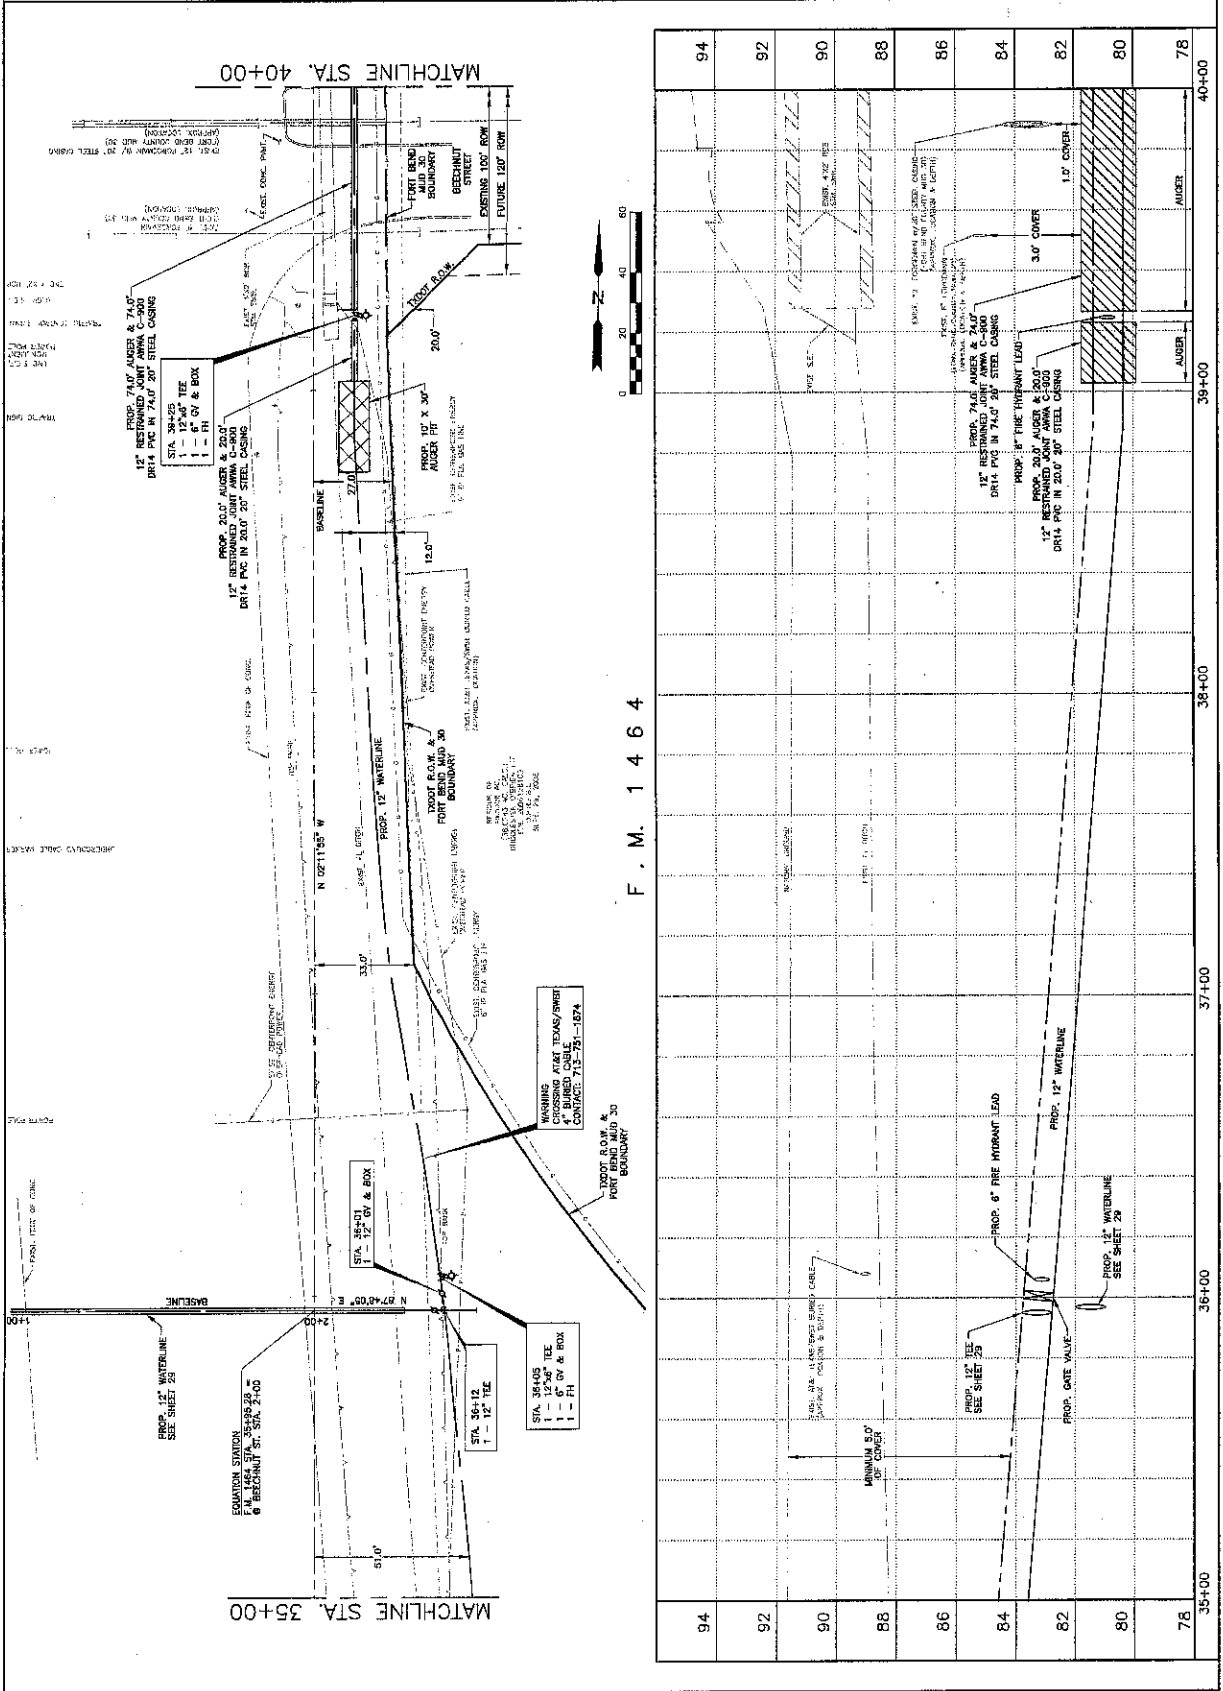

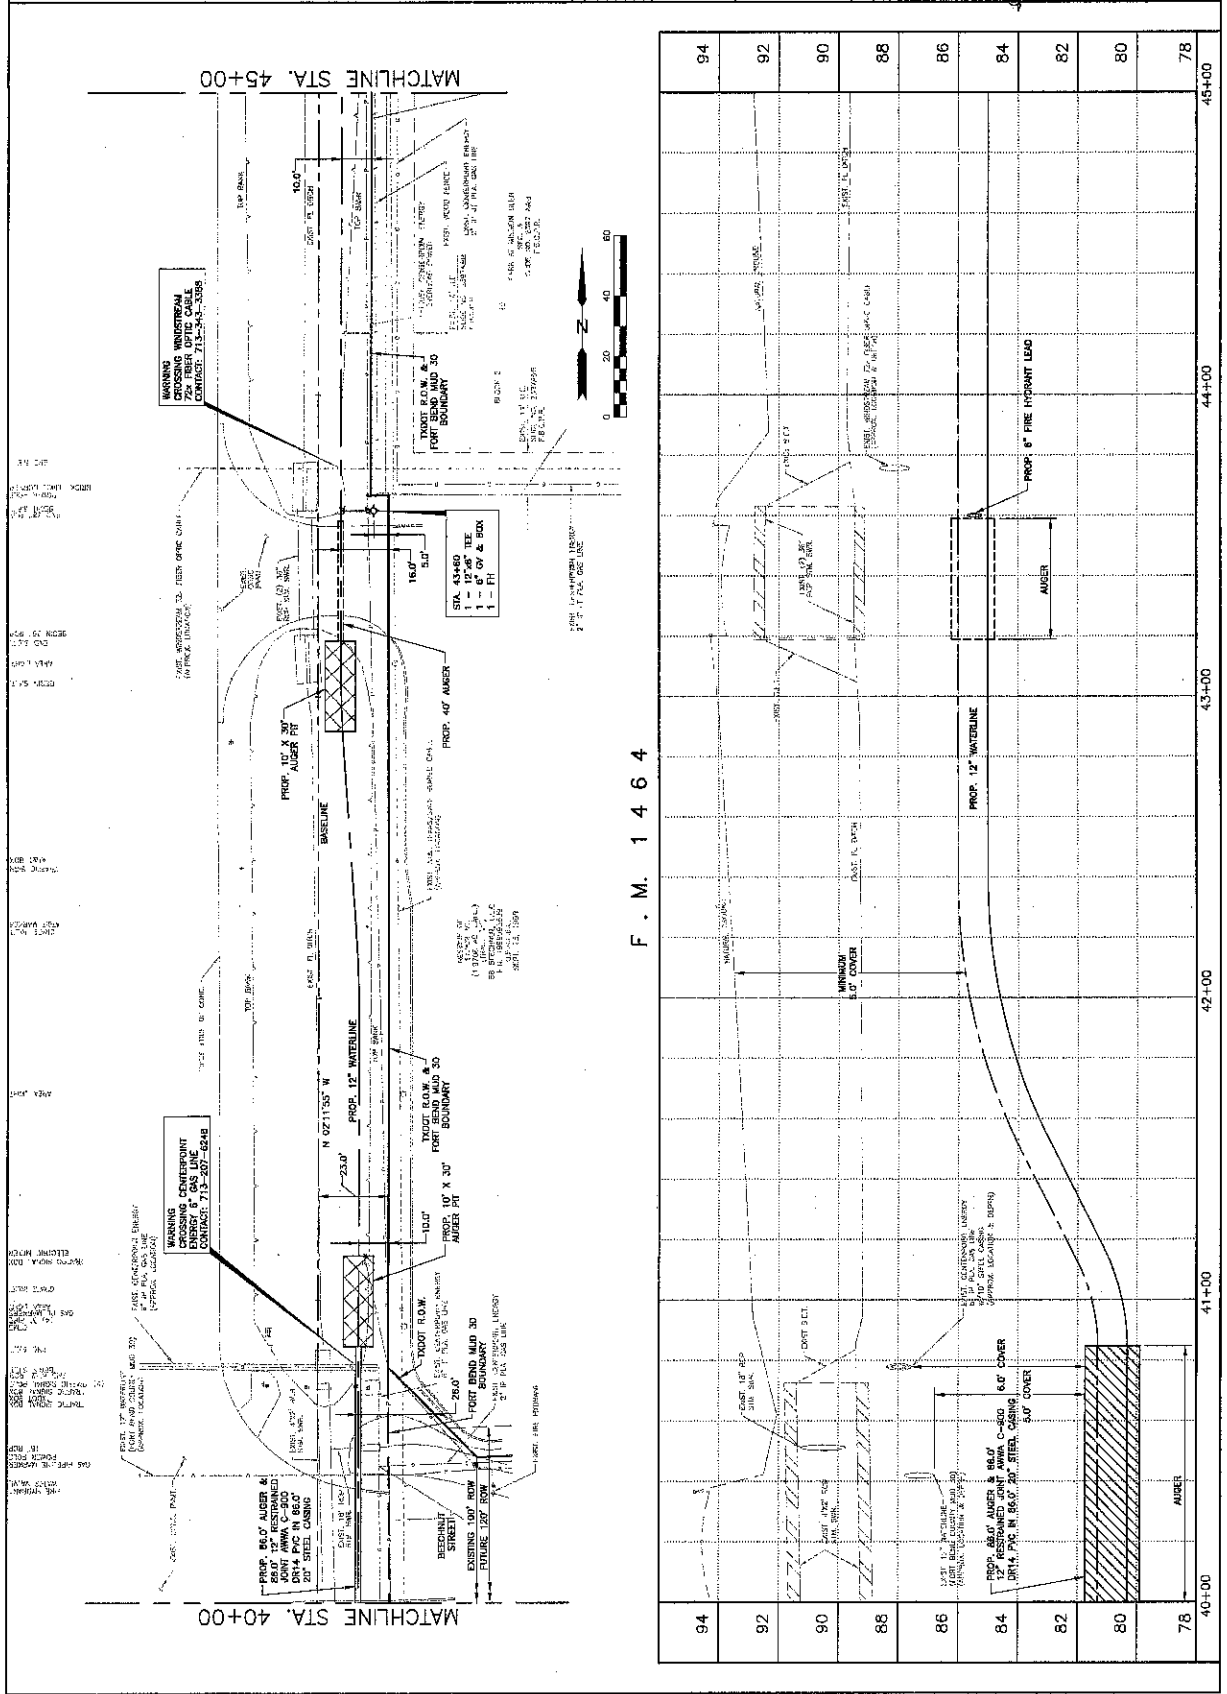

UTILITY NOTES

ALL UTILITIES HAVE BEEN MADE TO ACCURATELY SHOW ALL EXISTING UNDERGROUND UTILITIES AND PRELINES. HOWEVER, IT IS THE RESPONSIBILITY OF THE CONTRACTOR TO VERIFY THE LOCATION AND DEPTH OF ALL UTILITIES PRIOR TO ANY CONSTRUCTION. THE UTILITY AND PRELINES PHYSICALLY LOCATED IN THE FIELD PRIOR TO THE UTILITIES AND PRELINES ARE SOLELY THE CONTRACTOR'S RESPONSIBILITY. THE CONTRACTOR SHALL BE RESPONSIBLE FOR ANY UTILITIES NOT SHOWN ON THE PLANS OR NOT LOCATED IN THE FIELD PRIOR TO CONSTRUCTION.

CAUTION: UNDERGROUND GAS FACILITIES

THE CONTRACTOR SHALL BE RESPONSIBLE FOR THE LOCATION AND DEPTH OF ALL GAS FACILITIES. THE CONTRACTOR SHALL BE RESPONSIBLE FOR THE LOCATION AND DEPTH OF ALL GAS FACILITIES. THE CONTRACTOR SHALL BE RESPONSIBLE FOR THE LOCATION AND DEPTH OF ALL GAS FACILITIES.

WARNING: THE CONTRACTOR SHALL BE RESPONSIBLE FOR THE LOCATION AND DEPTH OF ALL GAS FACILITIES.

THE CONTRACTOR SHALL BE RESPONSIBLE FOR THE LOCATION AND DEPTH OF ALL GAS FACILITIES. THE CONTRACTOR SHALL BE RESPONSIBLE FOR THE LOCATION AND DEPTH OF ALL GAS FACILITIES. THE CONTRACTOR SHALL BE RESPONSIBLE FOR THE LOCATION AND DEPTH OF ALL GAS FACILITIES.

APPROVED: *[Signature]*

DATE: 9/1/18

COSTANZA ASSOCIATES

12" WATERLINE IMPROVEMENTS

PLAN & PROFILE

STA. 45+00 TO STA. 50+00

FORT BEND COUNTY M.U.D. NO. 30


FM 1464 - PHASE I

FILE NO: 1000-1009

DRAWING SCALE: 1"=40'

WORK: 1"=40'

SHEET: 17 OF 48

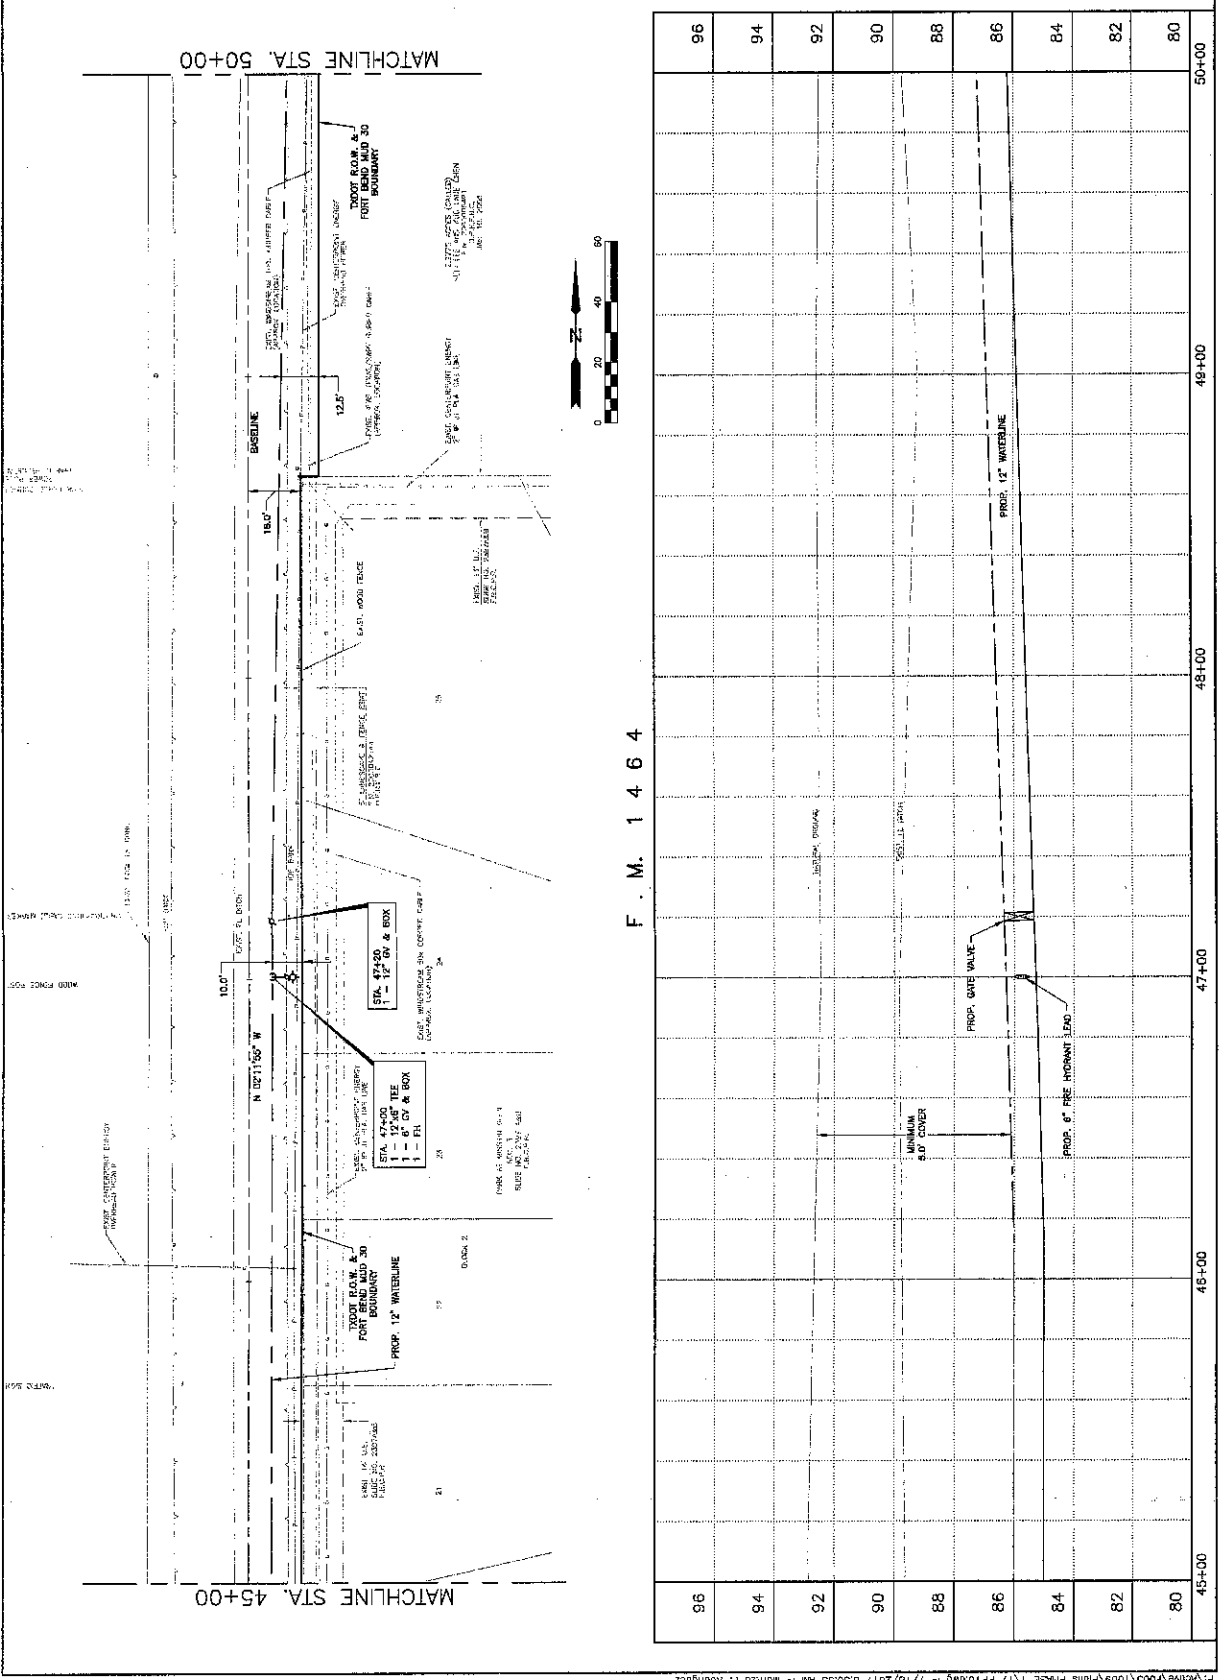

F. M. 1 4 6 4

ALL ATTEMPTS HAVE BEEN MADE TO ACCURATELY SHOW ALL EXISTING UNDERGROUND UTILITIES AND PIPELINES. HOWEVER, IT IS THE RESPONSIBILITY OF THE CONTRACTOR TO HAVE THE UTILITY AND PIPELINES PHYSICALLY LOCATED IN THE FIELD PRIOR TO CONSTRUCTION. ALL LIABILITY FOR THE UTILITIES AND PIPELINES ARE SOLELY THE CONTRACTOR'S WHETHER SHOWN ON THE PLANS OR NOT.

CAUTION: UNDERGROUND GAS FACILITIES
 LOCATION OF GAS LINES ARE SHOWN IN AN
 APPROPRIATE LOCATION ONLY. SERVICE LINES
 ARE USUALLY NOT SHOWN BY THE CONTRACTOR
 AND ARE NOT BEING GUARANTEED. THE CONTRACTING
 COMPANY AT 713-233-4507 OR
 1-800-869-8344 A MINIMUM OF 48 HOURS
 PRIOR TO CONSTRUCTION TO HAVE MAN
 SERVICE LINES FIELD LOCATED. THE
 CONTRACTOR SHALL DETERMINE THE EXACT
 LOCATION BEFORE COMMENCING WORK AND
 AGREE TO BE FULLY RESPONSIBLE FOR ANY
 DAMAGE TO GAS LINES OR TO ANY OTHER
 LOCATED AND PRESERVE THESE UNDERGROUND
 FACILITIES.

WARNING: OVERHEAD LINES MAY EXIST ON THE PROPERTY. THE CONTRACTOR SHALL BE RESPONSIBLE FOR LOCATING ALL UTILITIES SINCE THEY ARE NOT CLEARLY VISIBLE. BUT CONTRACTOR SHOULD LOCATE THEM PRIOR TO BEGINNING ANY CONSTRUCTION. TEXAS LAW, SECTION 752, HEALTH & SAFETY CODE, FORBIDS ALL ACTIVITIES IN WHICH PERSONS OR THINGS MAY COME WITHIN SIX (6) FEET OF LIVE OVERHEAD HIGH VOLTAGE LINES. CONTRACTOR SHALL BE RESPONSIBLE FOR LOCATING ALL UTILITIES PRIOR TO ANY CONSTRUCTION. CONTRACTOR SHALL BE RESPONSIBLE FOR OBTAINING ALL NECESSARY PERMITS UNDER THIS LAW. THIS LAW COVERS BOTH CRIMINAL AND CIVIL LIABILITY.

[illegible][illegible]

APPROVED: [Signature] DEVELOPMENT COORDINATOR
DATE: 9/7/17

**J. COSTANZA
J & ASSOCIATES**
1000 W. 10TH AVE. SUITE 100
DENVER CO 80202-1000
TEL: 303.733.1111 FAX: 303.733.1112

FORT BEND COUNTY M.U.D. NO. 30
FM 1464 - PHASE I
12" WATERLINE IMPROVEMENTS

PLAN & PROFILE
STA. 50+00 TO STA. 55+00

NOTE: CITY SIGNATURES VALID FOR ONE YEAR ONLY
DATE OF SIGNATURES

CITY OF HOUSTON
DEPARTMENT OF PUBLIC WORKS AND ENGINEERING



WATER / SEWER / TRAFFIC / TRANSPORTATION


STREET & AVENUE
42-8-8
FAMILY
SUNSHINE MARKET QUALITY


FILE NO: FD03--1009	R/R CITY OF HOUSTON USE ONLY
------------------------	------------------------------

DRAWING SCALE
 HORIZ: 1"=20'
 VERT: 1"=2'
 58331

SHEET 18 OF 42
NUT

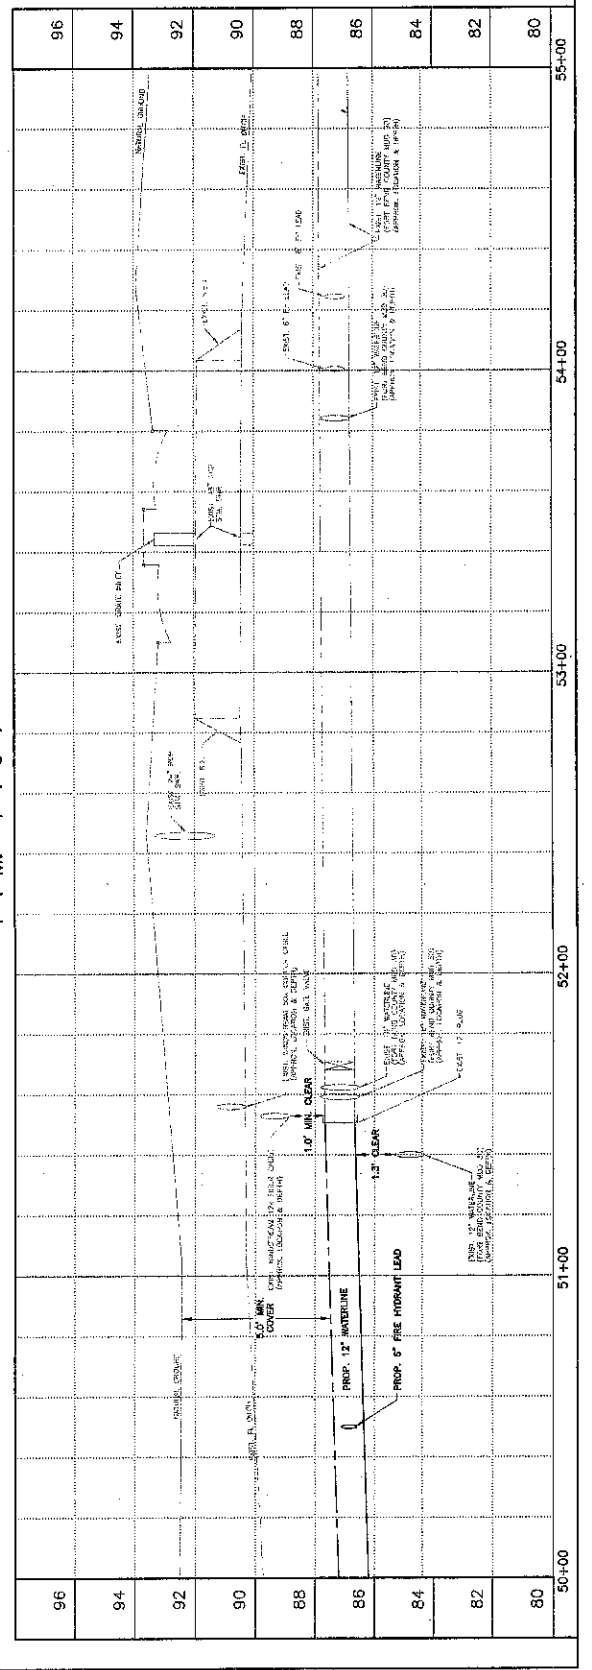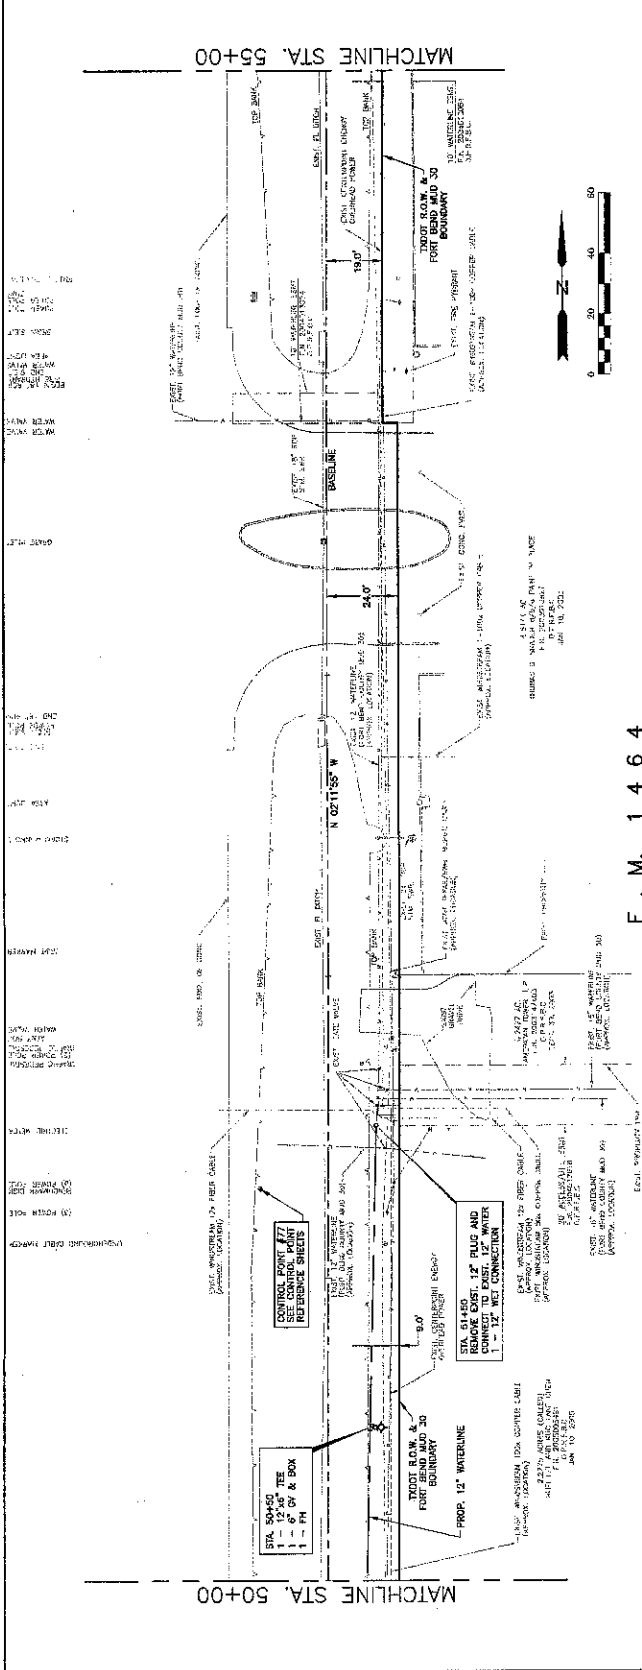[illegible]

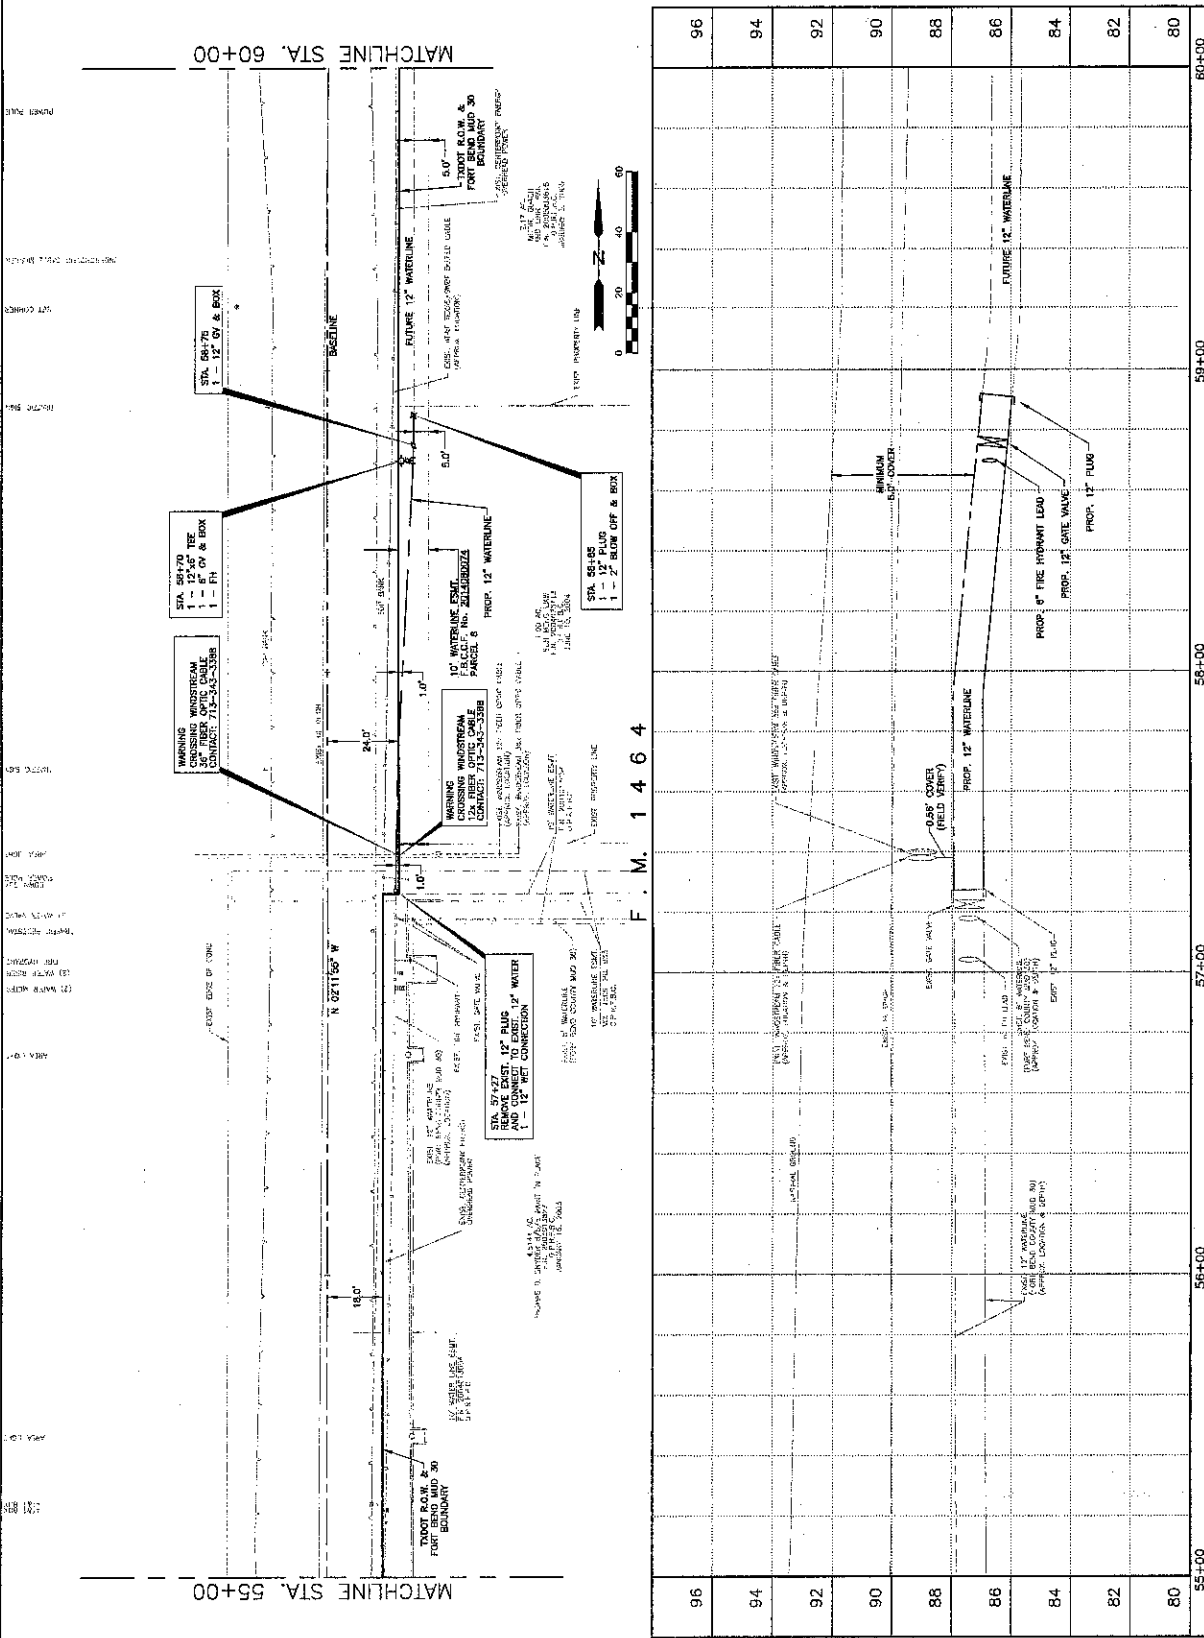

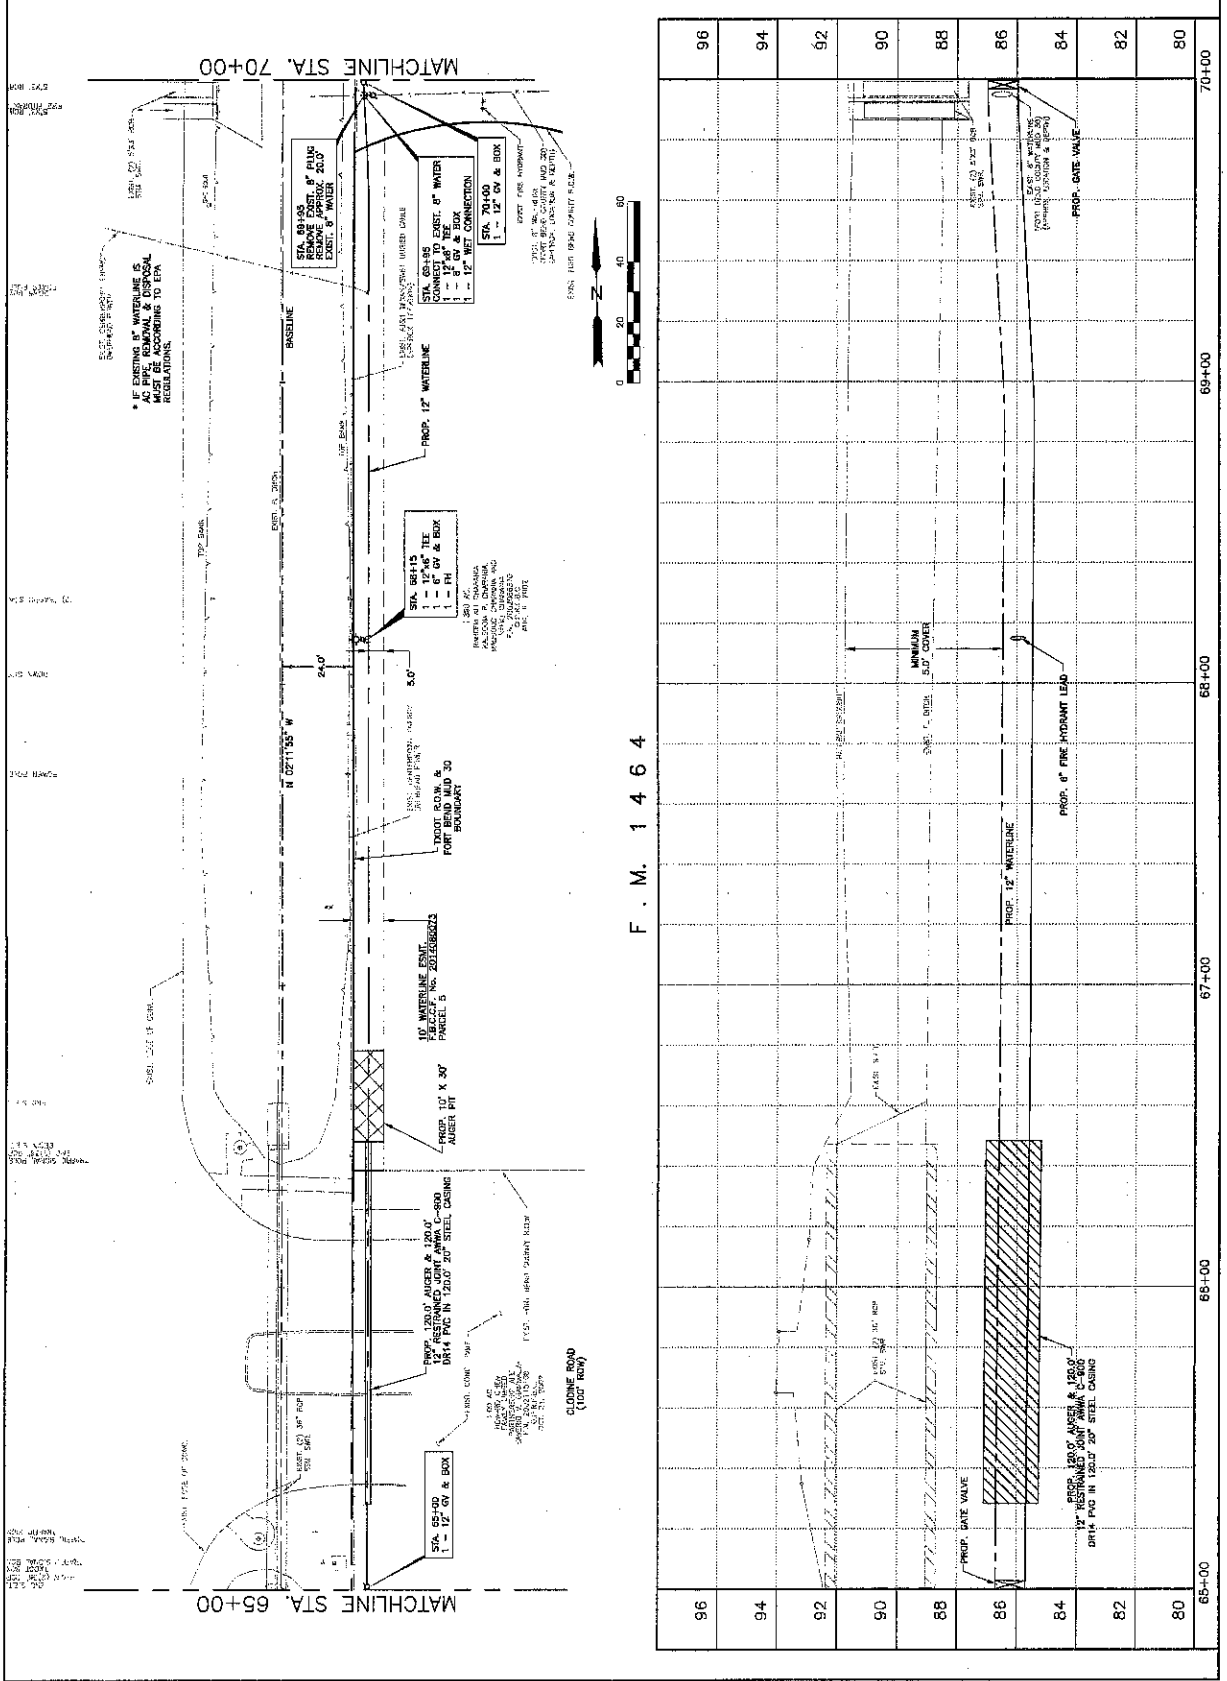[illegible]

UTILITY NOTES

ALL UTILITIES SHOWN ARE BASED ON RECORD DRAWINGS AND FIELD SURVEY. THE CONTRACTOR SHALL VERIFY THE LOCATION AND DEPTH OF ALL UTILITIES PRIOR TO CONSTRUCTION. THE CITY OF HOUSTON SHALL NOT BE RESPONSIBLE FOR THE LOCATION AND DEPTH OF UTILITIES NOT SHOWN ON THE PLANS OR PROFILE.

CAUTION: UNDERGROUND GAS FACILITIES


THE CONTRACTOR SHALL BE RESPONSIBLE FOR THE LOCATION AND DEPTH OF ALL UNDERGROUND GAS FACILITIES. THE CONTRACTOR SHALL BE RESPONSIBLE FOR THE LOCATION AND DEPTH OF ALL UNDERGROUND GAS FACILITIES. THE CONTRACTOR SHALL BE RESPONSIBLE FOR THE LOCATION AND DEPTH OF ALL UNDERGROUND GAS FACILITIES.


APPROVED: *[Signature]*
DATE: 9/3/14

FOR FORT BEND COUNTY M.I.D. NO. 30
FM 1464 - PHASE I
12" WATERLINE IMPROVEMENTS

PLAN & PROFILE
STA 70+00 TO STA 75+00

FILE NO.: F003-1009
DRAWING SCALE: HORIZONTAL 1"=40' VERTICAL 1"=4' SHEET 22 OF 43

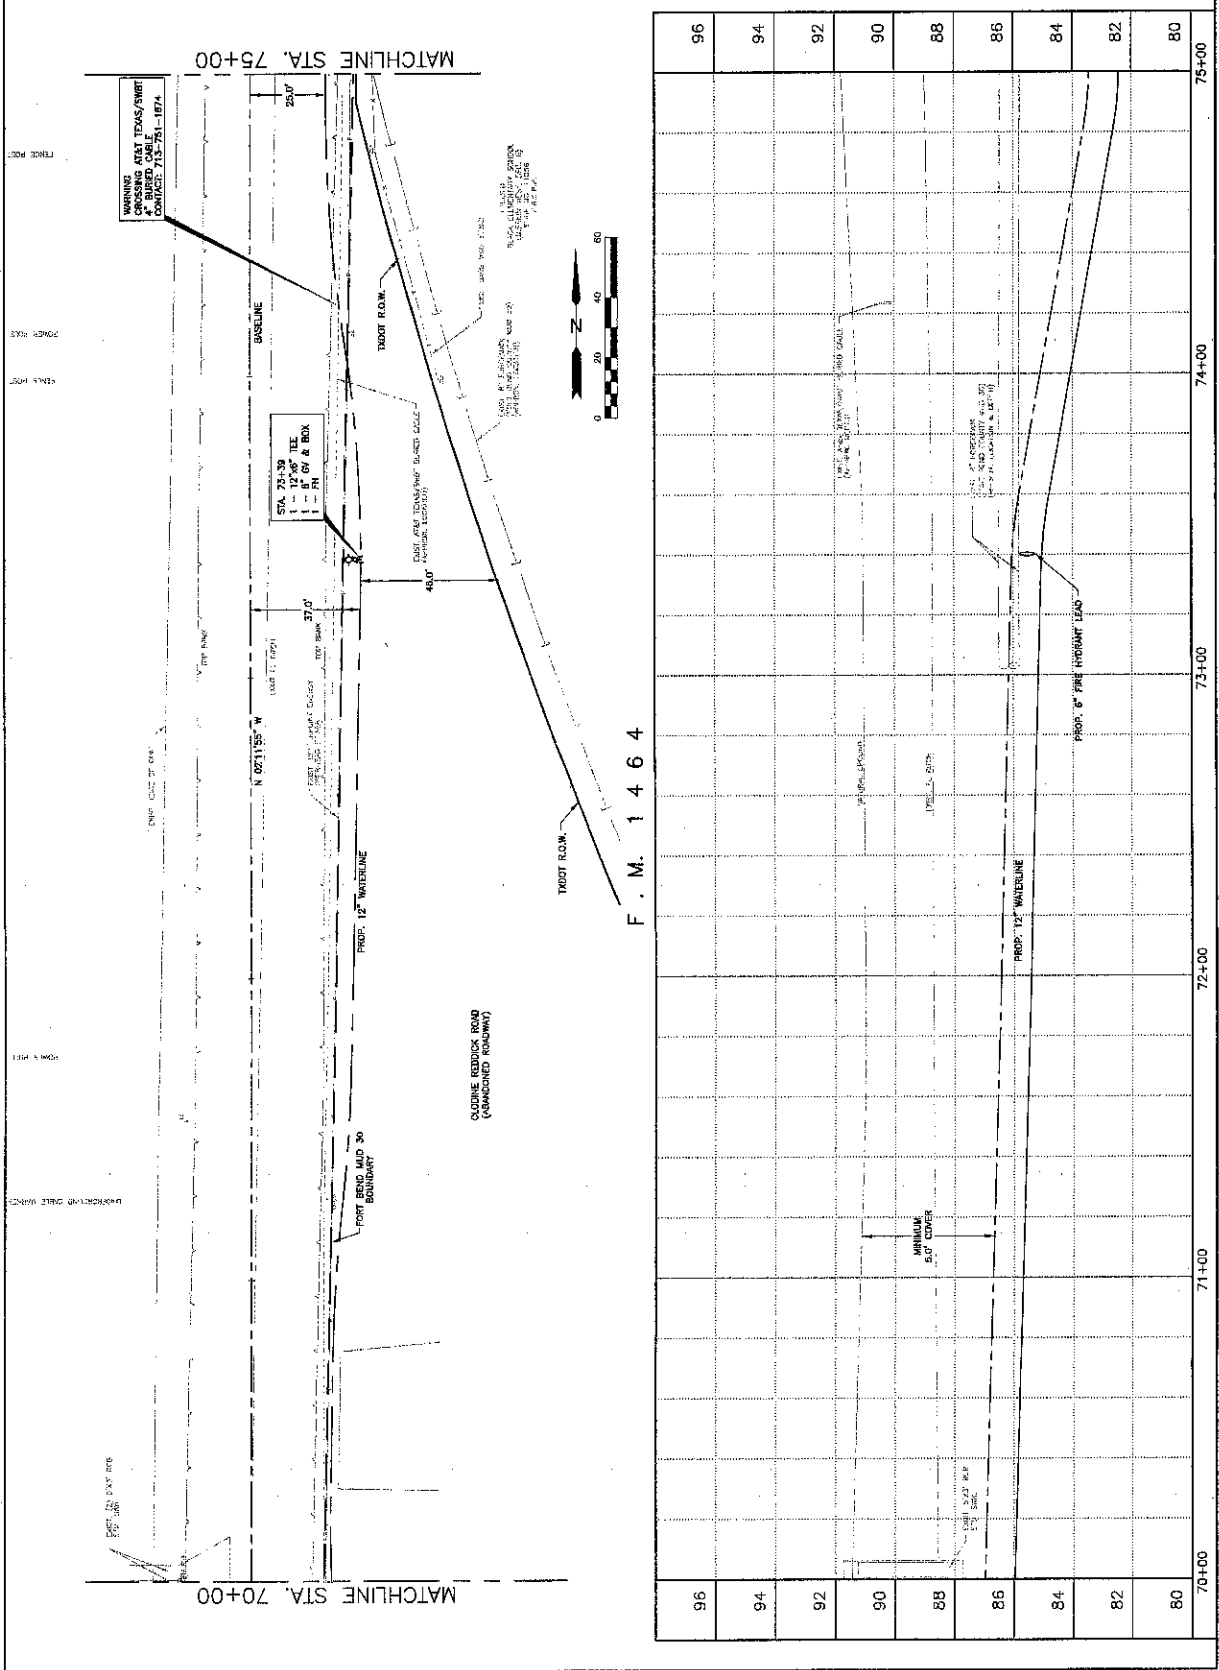

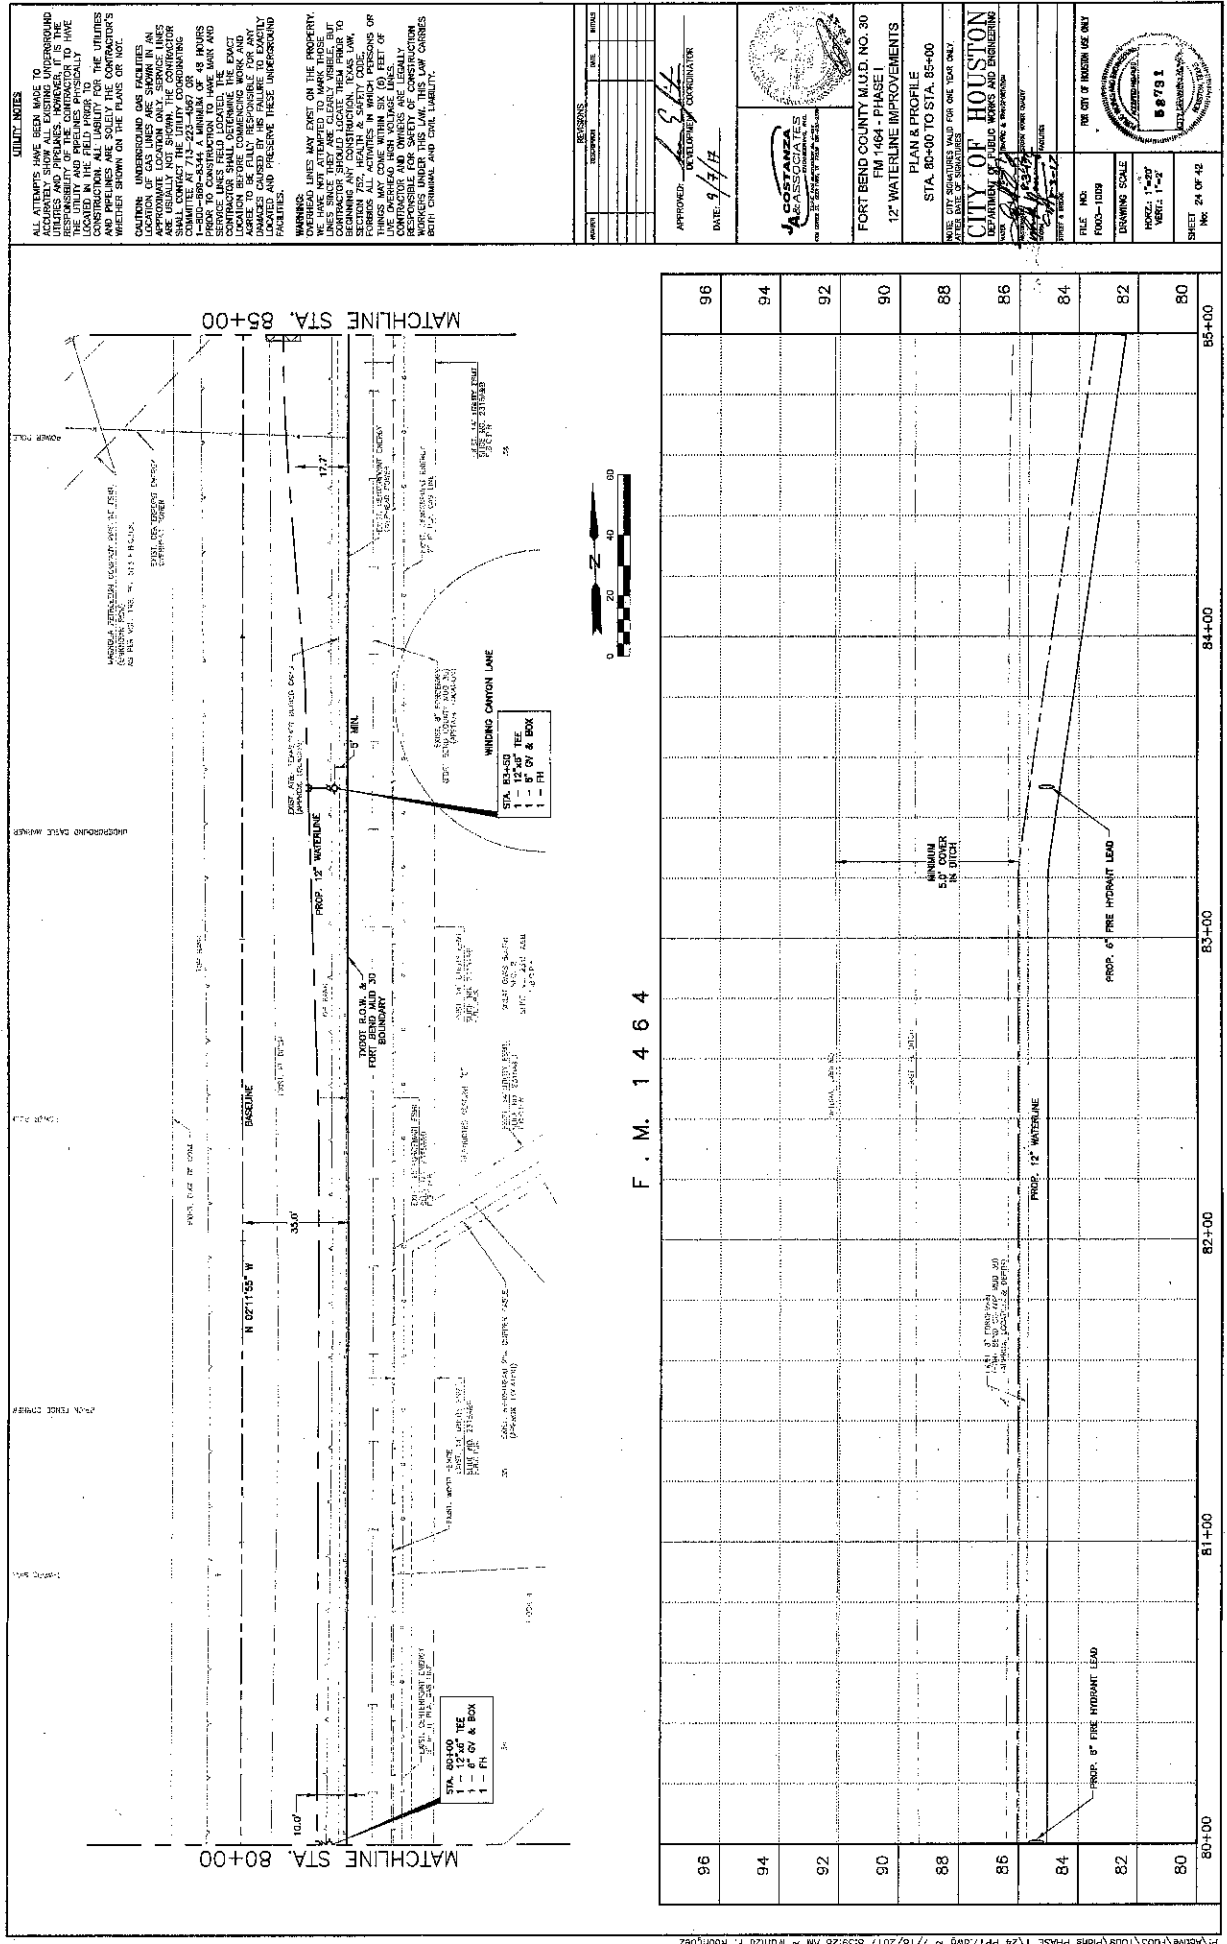

UTILITY NOTES

ALL UTILITIES HAVE BEEN MADE TO ACCURATELY SHOW ALL EXISTING UNDERGROUND UTILITIES AND PRELIMINARIES. HOWEVER, IT IS THE RESPONSIBILITY OF THE USER TO VERIFY THE LOCATION AND DEPTH OF ALL UTILITIES PRIOR TO CONSTRUCTION. THE UTILITY AND PRELIMINARIES SHOWN ON THIS DRAWING ARE BASED ON THE BEST AVAILABLE INFORMATION AND ARE NOT A GUARANTEE OF THE LOCATION OR DEPTH OF ANY UTILITIES. THE USER SHALL BE RESPONSIBLE FOR ANY DAMAGE TO OR INTERFERENCE WITH ANY UTILITIES DURING THE CONSTRUCTION OF THIS PROJECT.

CAUTION: UNDERGROUND GAS FACILITIES ARE NOT SHOWN ON THIS DRAWING. THE CONTRACTOR SHALL BE RESPONSIBLE FOR IDENTIFYING AND PROTECTING ALL GAS FACILITIES PRIOR TO CONSTRUCTION. THE CONTRACTOR SHALL BE RESPONSIBLE FOR OBTAINING ALL NECESSARY PERMITS AND APPROVALS FROM THE APPROPRIATE AGENCIES PRIOR TO CONSTRUCTION.

WARNING: THE USER SHALL BE RESPONSIBLE FOR OBTAINING ALL NECESSARY PERMITS AND APPROVALS FROM THE APPROPRIATE AGENCIES PRIOR TO CONSTRUCTION. THE USER SHALL BE RESPONSIBLE FOR OBTAINING ALL NECESSARY PERMITS AND APPROVALS FROM THE APPROPRIATE AGENCIES PRIOR TO CONSTRUCTION.

APPROVED: [Signature]
DATE: 9/4/17

COSTANZA ASSOCIATES
10000 WEST 10TH STREET, SUITE 200
HOUSTON, TEXAS 77036
TEL: 281-410-1000
WWW.COSTANZAASSOCIATES.COM

FORT BEND COUNTY M.U.D. NO. 30
FM 1464 - PHASE I
12" WATERLINE IMPROVEMENTS
PLAN & PROFILE
STA. 80+00 TO STA. 85+00
THIS CITY SEWERS MAINTAINED FOR ONE YEAR ONLY
AFTER DATE OF COMPLETION

CITY OF HOUSTON
DEPARTMENT OF PUBLIC WORKS AND ENGINEERING
1000 RICE AVENUE, SUITE 1000
HOUSTON, TEXAS 77001
TEL: 713-858-2000
WWW.CITYOFHOUSTON.ORG

FILE NO: FWD-1009
DRAWING SCALE:
HORIZ: 1"=40'
VERT: 1"=4'
SHEET: 24 OF 42

F. M. 1464

UTILITY NOTES

ALL UTILITIES SHOWN ARE BASED ON THE RECORD DRAWINGS AND FIELD SURVEY. THE CONTRACTOR SHALL VERIFY THE LOCATION AND DEPTH OF ALL UTILITIES PRIOR TO CONSTRUCTION. THE CONTRACTOR SHALL BE RESPONSIBLE FOR THE SAFETY OF ALL UTILITIES AND SHALL TAKE ALL NECESSARY PRECAUTIONS TO AVOID DAMAGE TO UTILITIES. THE CONTRACTOR SHALL BE RESPONSIBLE FOR THE SAFETY OF ALL UTILITIES AND SHALL TAKE ALL NECESSARY PRECAUTIONS TO AVOID DAMAGE TO UTILITIES.

CAUTION: UNDERGROUND GAS FACILITIES

UNDERGROUND GAS FACILITIES ARE USUALLY NOT SHOWN. THE CONTRACTOR SHALL BE RESPONSIBLE FOR THE SAFETY OF ALL UTILITIES AND SHALL TAKE ALL NECESSARY PRECAUTIONS TO AVOID DAMAGE TO UTILITIES.

WARNING:

THE CONTRACTOR SHALL BE RESPONSIBLE FOR THE SAFETY OF ALL UTILITIES AND SHALL TAKE ALL NECESSARY PRECAUTIONS TO AVOID DAMAGE TO UTILITIES.


APPROVED: *[Signature]*

DATE: 9/1/17

FOR FORT BEND COUNTY M.U.D. NO. 30
FM 1464 - PHASE I
12" WATERLINE IMPROVEMENTS

PLAN & PROFILE
STA. 86+00 TO STA. 100+00

FILE NO: PDD-1009
DRAWING SCALE: HORIZ. 1"=50' VERT. 1"=2'
SHEET NO. 27 OF 42

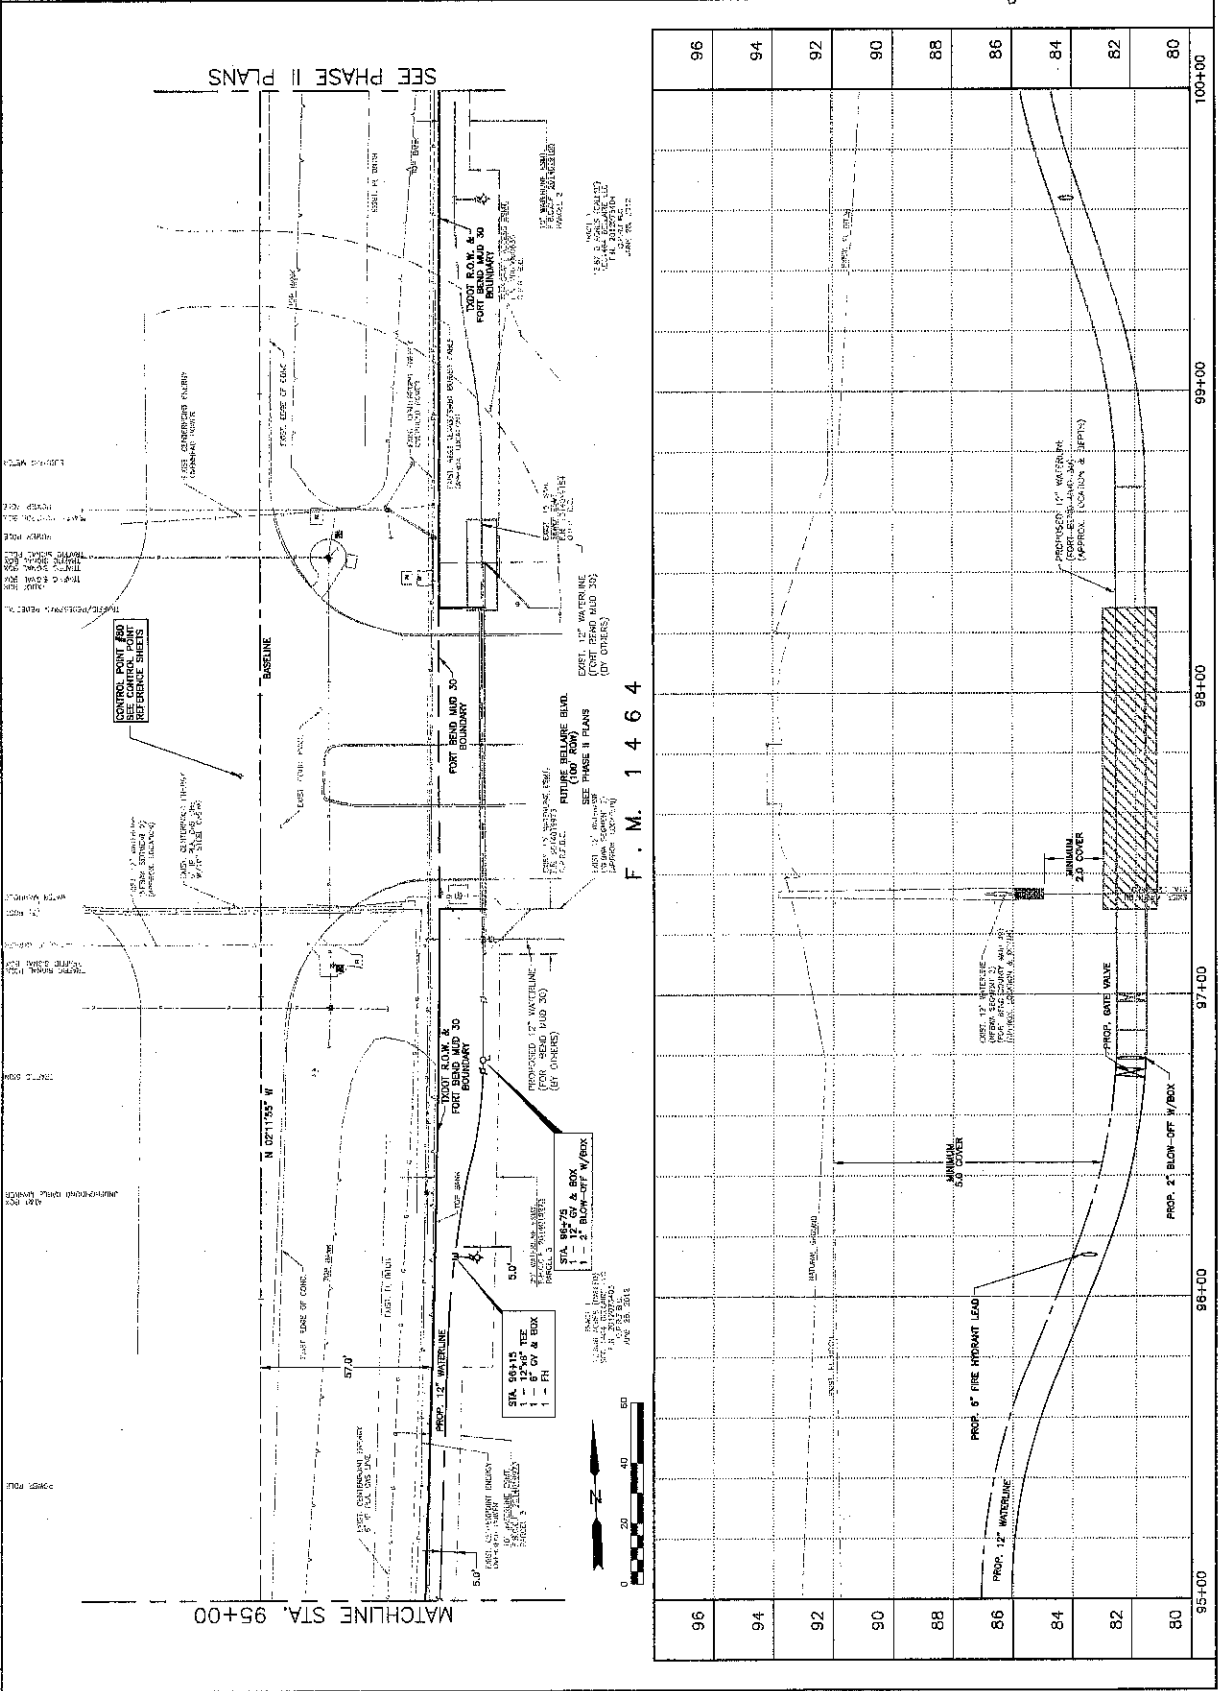

ALL ATTEMPTS HAVE BEEN MADE TO ACCURATELY SHOW ALL EXISTING UNDERGROUND UTILITIES AND PIPELINES. HOWEVER, IT IS THE RESPONSIBILITY OF THE CONTRACTOR TO HAVE THE UTILITY AND PIPELINES PHYSICALLY LOCATED IN THE FIELD PRIOR TO CONSTRUCTION. ALL LIABILITY FOR THE UTILITIES AND PIPELINES ARE SOLELY THE CONTRACTOR'S WHETHER SHOWN ON THE PLANS OR NOT.

CAUTION: UNDERGROUND GAS FACILITIES
LOCATION OF GAS LINES ARE SHOWN IN AN
ADJACENT LOCATION ON THE CONSTRUCTION LINES
DRAWING. CONTRACTOR SHALL BE RESPONSIBLE FOR
SHALL CONTACT THE UTILITY COORDINATING
COMMITTEE AT 713-223-4667 OR
1-800-869-8344 A MINIMUM OF 48 HOURS
PRIOR TO CONSTRUCTION TO HAVE MAIN AND
SERVICE LINES FIELD LOCATED. THE
CONTRACTOR SHALL DETERMINE THE EXACT
LOCATION OF GAS LINES AND BE RESPONSIBLE FOR ANY
AGREES TO BE BEYOND RESPONSIBLE FOR ANY
DAMAGES CAUSED BY HIS FAILURE TO EXACTLY
LOCATED AND PRESERVE THESE UNDERGROUND
FACILITIES.

WARNING: OVERHEAD LINES MAY EXIST ON THE PROPERTY. WE HAVE NOT ATTEMPTED TO MARK THOSE LINES SINCE THEY ARE CLOSELY VISIBLE, BUT CONTRACTOR SHOULD LOCATE THEM PRIOR TO BEGINNING ANY CONSTRUCTION. EXOS LAW, 42 U.S.C. § 1982, IN WHICH PERSONS, OR PERSONS ENGAGED IN SUCH ACTIVITIES, OR THINGS MAY COME WITHIN SIX (6) FEET OF THE OVERHEAD HIGH VOLTAGE LINES. CONTRACTOR AND OWNERS ARE LEGALLY RESPONSIBLE FOR SAFETY OF CONSTRUCTION WORKERS UNDER THIS LAW. THIS LAW CARRIES BOTH CRIMINAL AND CIVIL LIABILITY.

[illegible]

APPROVED: [Signature] DEVELOPMENT COORDINATOR
DATE: 9/3/17

**COSTANZA
& ASSOCIATES**
ARCHITECTS
1000 W. BROADWAY, SUITE 1000
NEW YORK, NY 10018
TEL: 212-512-1000 FAX: 212-512-1001

FORT BEND COUNTY M.U.D. NO. 30
FM 1464 - PHASE I
12" WATERLINE IMPROVEMENTS
PLAN & PROFILE

FM 1484 CROSSING
SOUTH OF BEECHNUT ST.



NOTE: CITY SIGNATURES VALID FOR ONE YEAR ONLY
 AFTER DATE OF SIGNATURES

CITY OF HOUSTON

NAME: [Signature] DATE: 8-3-12
 TITLE: SA OFFICE: SA
 DIVISION: SA SECTION: SA
 REPORTING OFFICER: SA SUPERVISOR: SA
 REVIEWER: SA APPROVER: SA

FILE NO:	FOR CITY OF HOUSTON USE ONLY
FO03-1009	APPROPRIATELY CLASSIFIED AND RELEASED

DRAWING SCALE
 HORIZ. 1"=20'
 VERT. 1"=2'
 SHEET 29 OF 42

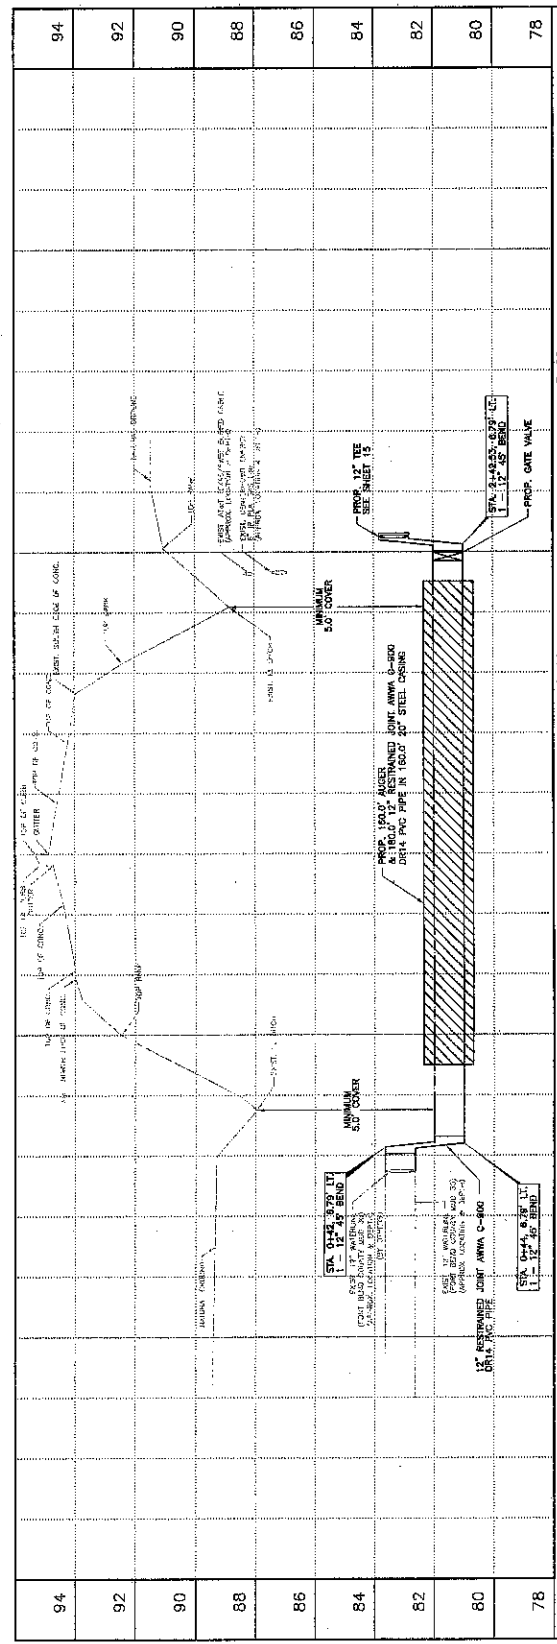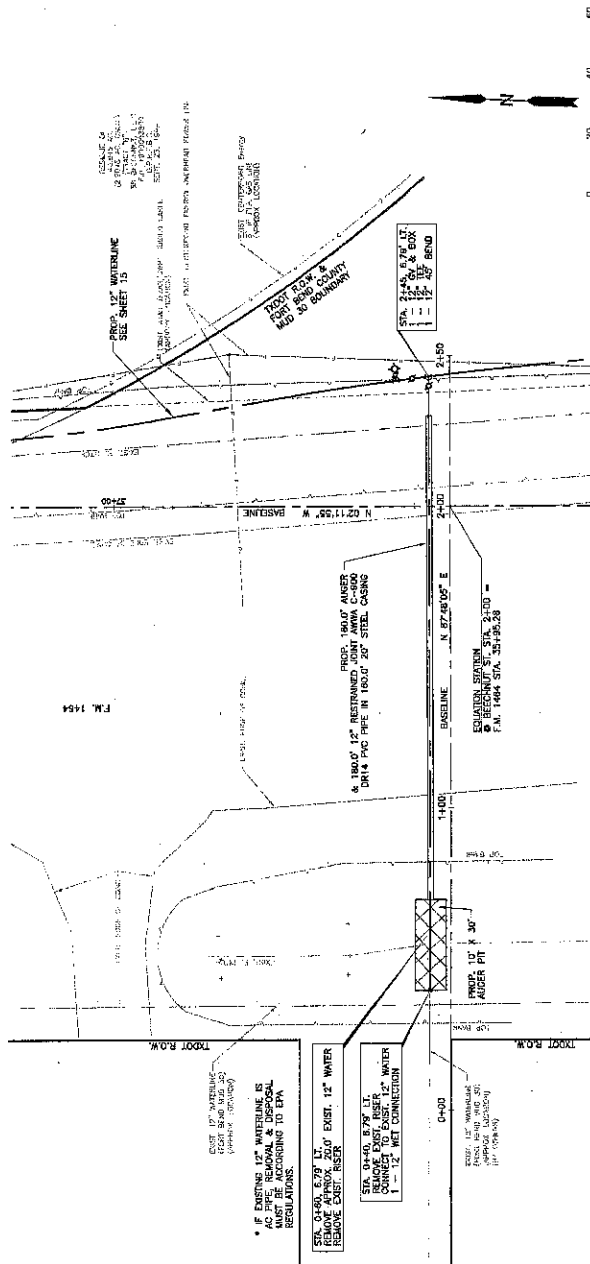

UTILITY NOTES

ALL UTILITIES SHOWN ARE BASED ON RECORD DRAWINGS AND FIELD SURVEY. THE CONTRACTOR SHALL BE RESPONSIBLE FOR VERIFYING THE LOCATION AND DEPTH OF ALL UTILITIES PRIOR TO CONSTRUCTION. THE UTILITY AND PRELINES PHYSICALLY LOCATED IN THE FIELD PRIOR TO CONSTRUCTION SHALL BE SHOWN ON THE DRAWING. THE CONTRACTOR SHALL BE RESPONSIBLE FOR PROTECTING ALL UTILITIES AND PRELINES FROM DAMAGE DURING CONSTRUCTION. THE CONTRACTOR SHALL BE RESPONSIBLE FOR REPLACING OR REPAIRING ALL UTILITIES AND PRELINES DAMAGED DURING CONSTRUCTION. THE CONTRACTOR SHALL BE RESPONSIBLE FOR OBTAINING ALL NECESSARY PERMITS FROM THE APPROPRIATE AGENCIES PRIOR TO CONSTRUCTION. THE CONTRACTOR SHALL BE RESPONSIBLE FOR OBTAINING ALL NECESSARY PERMITS FROM THE APPROPRIATE AGENCIES PRIOR TO CONSTRUCTION. THE CONTRACTOR SHALL BE RESPONSIBLE FOR OBTAINING ALL NECESSARY PERMITS FROM THE APPROPRIATE AGENCIES PRIOR TO CONSTRUCTION.

CAUTION: UNDERGROUND GAS FACILITIES

UNDERGROUND GAS FACILITIES ARE SHOWN ON THE DRAWING. THE CONTRACTOR SHALL BE RESPONSIBLE FOR VERIFYING THE LOCATION AND DEPTH OF ALL GAS FACILITIES PRIOR TO CONSTRUCTION. THE CONTRACTOR SHALL BE RESPONSIBLE FOR PROTECTING ALL GAS FACILITIES FROM DAMAGE DURING CONSTRUCTION. THE CONTRACTOR SHALL BE RESPONSIBLE FOR REPLACING OR REPAIRING ALL GAS FACILITIES DAMAGED DURING CONSTRUCTION. THE CONTRACTOR SHALL BE RESPONSIBLE FOR OBTAINING ALL NECESSARY PERMITS FROM THE APPROPRIATE AGENCIES PRIOR TO CONSTRUCTION. THE CONTRACTOR SHALL BE RESPONSIBLE FOR OBTAINING ALL NECESSARY PERMITS FROM THE APPROPRIATE AGENCIES PRIOR TO CONSTRUCTION. THE CONTRACTOR SHALL BE RESPONSIBLE FOR OBTAINING ALL NECESSARY PERMITS FROM THE APPROPRIATE AGENCIES PRIOR TO CONSTRUCTION.

WARNING: OVERHEAD LINES MAY EXIST ON THE PROPERTY.

OVERHEAD LINES MAY EXIST ON THE PROPERTY. THE CONTRACTOR SHALL BE RESPONSIBLE FOR VERIFYING THE LOCATION AND DEPTH OF ALL OVERHEAD LINES PRIOR TO CONSTRUCTION. THE CONTRACTOR SHALL BE RESPONSIBLE FOR PROTECTING ALL OVERHEAD LINES FROM DAMAGE DURING CONSTRUCTION. THE CONTRACTOR SHALL BE RESPONSIBLE FOR REPLACING OR REPAIRING ALL OVERHEAD LINES DAMAGED DURING CONSTRUCTION. THE CONTRACTOR SHALL BE RESPONSIBLE FOR OBTAINING ALL NECESSARY PERMITS FROM THE APPROPRIATE AGENCIES PRIOR TO CONSTRUCTION. THE CONTRACTOR SHALL BE RESPONSIBLE FOR OBTAINING ALL NECESSARY PERMITS FROM THE APPROPRIATE AGENCIES PRIOR TO CONSTRUCTION. THE CONTRACTOR SHALL BE RESPONSIBLE FOR OBTAINING ALL NECESSARY PERMITS FROM THE APPROPRIATE AGENCIES PRIOR TO CONSTRUCTION.

APPROVED: *[Signature]*

DATE: 9/1/17

FOR THE CITY OF HOUSTON

FILE NO. 1003-1006

DRAWING SCALE: HORIZ. 1"=40' VERT. 1"=20'

SHEET 30 OF 42

CITY OF HOUSTON

DEPARTMENT OF PUBLIC WORKS AND ENGINEERING

12" WATERLINE IMPROVEMENTS

PLAN & PROFILE

FM 1464 AND BISSONNET ST.


INTERSECTION

FOR THE CITY OF HOUSTON

FILE NO. 1003-1006

DRAWING SCALE: HORIZ. 1"=40' VERT. 1"=20'


SHEET 30 OF 42

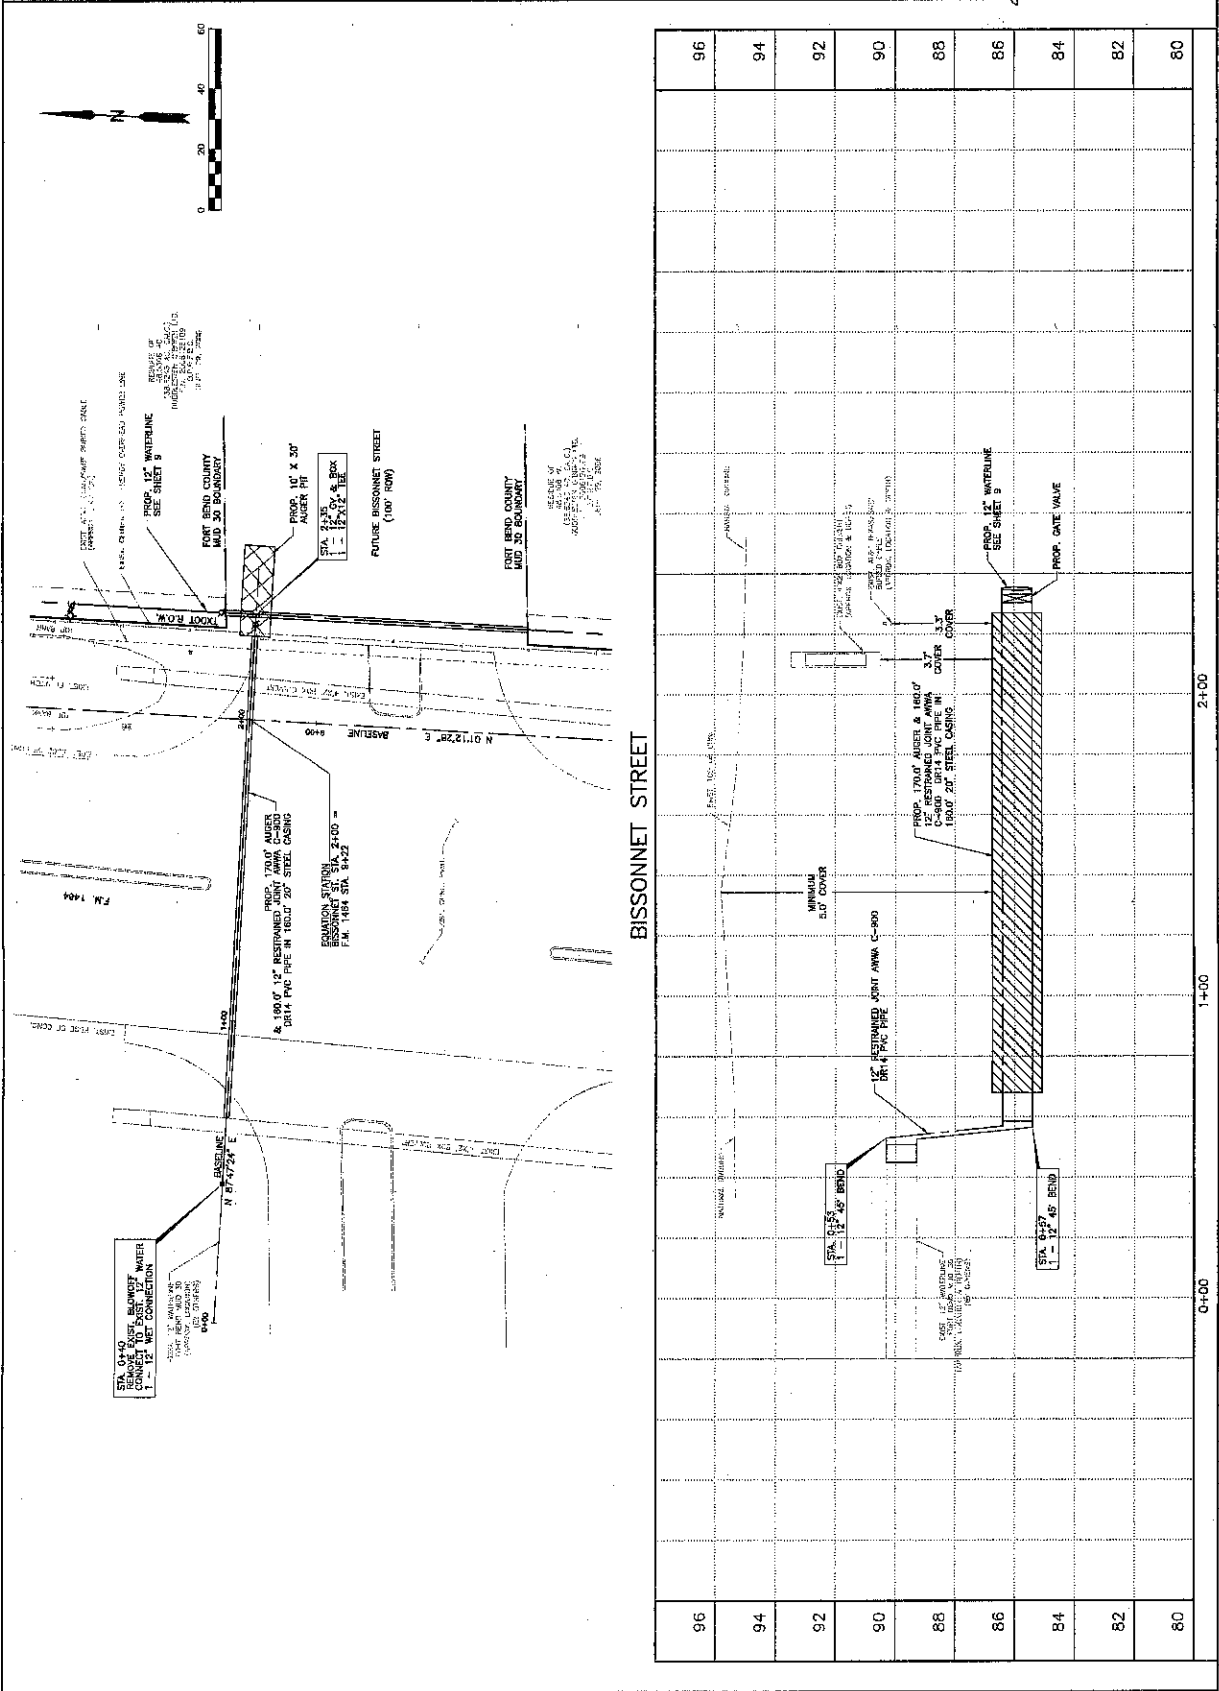

ALL ATTEMPTS HAVE BEEN MADE TO ACCURATELY SHOW ALL EXISTING UNDERGROUND UTILITIES AND PIPELINES. HOWEVER, IT IS THE RESPONSIBILITY OF THE CONTRACTOR TO HAVE THE UTILITY AND PIPELINES PHYSICALLY LOCATED IN THE FIELD PRIOR TO CONSTRUCTION. ALL LIABILITY FOR THE UTILITIES AND PIPELINES ARE SOLELY THE CONTRACTOR'S WHETHER SHOWN ON THE PLANS OR NOT.

CAUTION: UNDERGROUND GAS FACILITIES
LOCATION OF GAS LINES ARE SHOWN IN AN
APPROXIMATE LOCATION ONLY. SERVICE LINES
SHALL CONTACT THE UTILITY COORDINATING
COMMITTEE AT 713-213-4567 OR
1-800-658-5344 A MINIMUM OF 48 HOURS
PRIOR TO CONSTRUCTION TO HAVE MAIN AND
SERVICE LINES FIELD LOCATED. THE EXACT
CONTRACTOR SHALL DETERMINE. THE EXACT
CONTRACTOR SHALL BE FULLY RESPONSIBLE FOR ANY
DAMAGES CAUSED BY HIS FAILURE TO EXACTLY
LOCATE AND PRESERVE THESE UNDERGROUND
FACILITIES.

 WARNING: OVERHEAD LINES MAY EXIST ON THE PROPERTY. WE HAVE NOT ATTEMPTED TO MARK THOSE LINES SINCE THEY ARE CLEARLY VISIBLE. BUT CONTRACTOR SHOULD LOCATE THEM PRIOR TO BEGINNING ANY CONSTRUCTION. TEXAS LAW, SECTION 722, HEALTH & SAFETY CODE, FORBIDS ANY CLIMBING IN WHICH PERSONS OR THINGS ARE COME WITHIN 6' OF LINES CARRYING HIGH-VOLTAGE (5) KILTS OF LINE TENSION. CONTRACTOR AND OWNER ARE LEGALLY RESPONSIBLE FOR SAFETY OF CONSTRUCTION WORKERS UNDER THIS LAW. THIS LAW CARRIES BOTH CRIMINAL AND CIVIL LIABILITY.

[illegible]

FORT BEND COUNTY M.U.D. NO. 30
FM 1464 - PHASE I
12" WATERLINE IMPROVEMENTS
STORMWATER POLLUTION
PREVENTION PLAN
STA. 0+00 TO 30+00


NOTE: CITY SEALS ARE VALID FOR ONE YEAR ONLY
AFTER DATE OF ISSUANCE

CITY OF HOUSTON
DEPARTMENT OF PUBLIC WORKS AND ENGINEERING

SEAL:  OFFICE: TRANSPORTATION

NAME:  TITLE:  DIVISION:  SAFETY

	THIS CITY OF HOUSTON USE ONLY	
	FILE NO: F0003-1009	SHEET 31 OF 42
DRAWING SCALE 1"=50'		

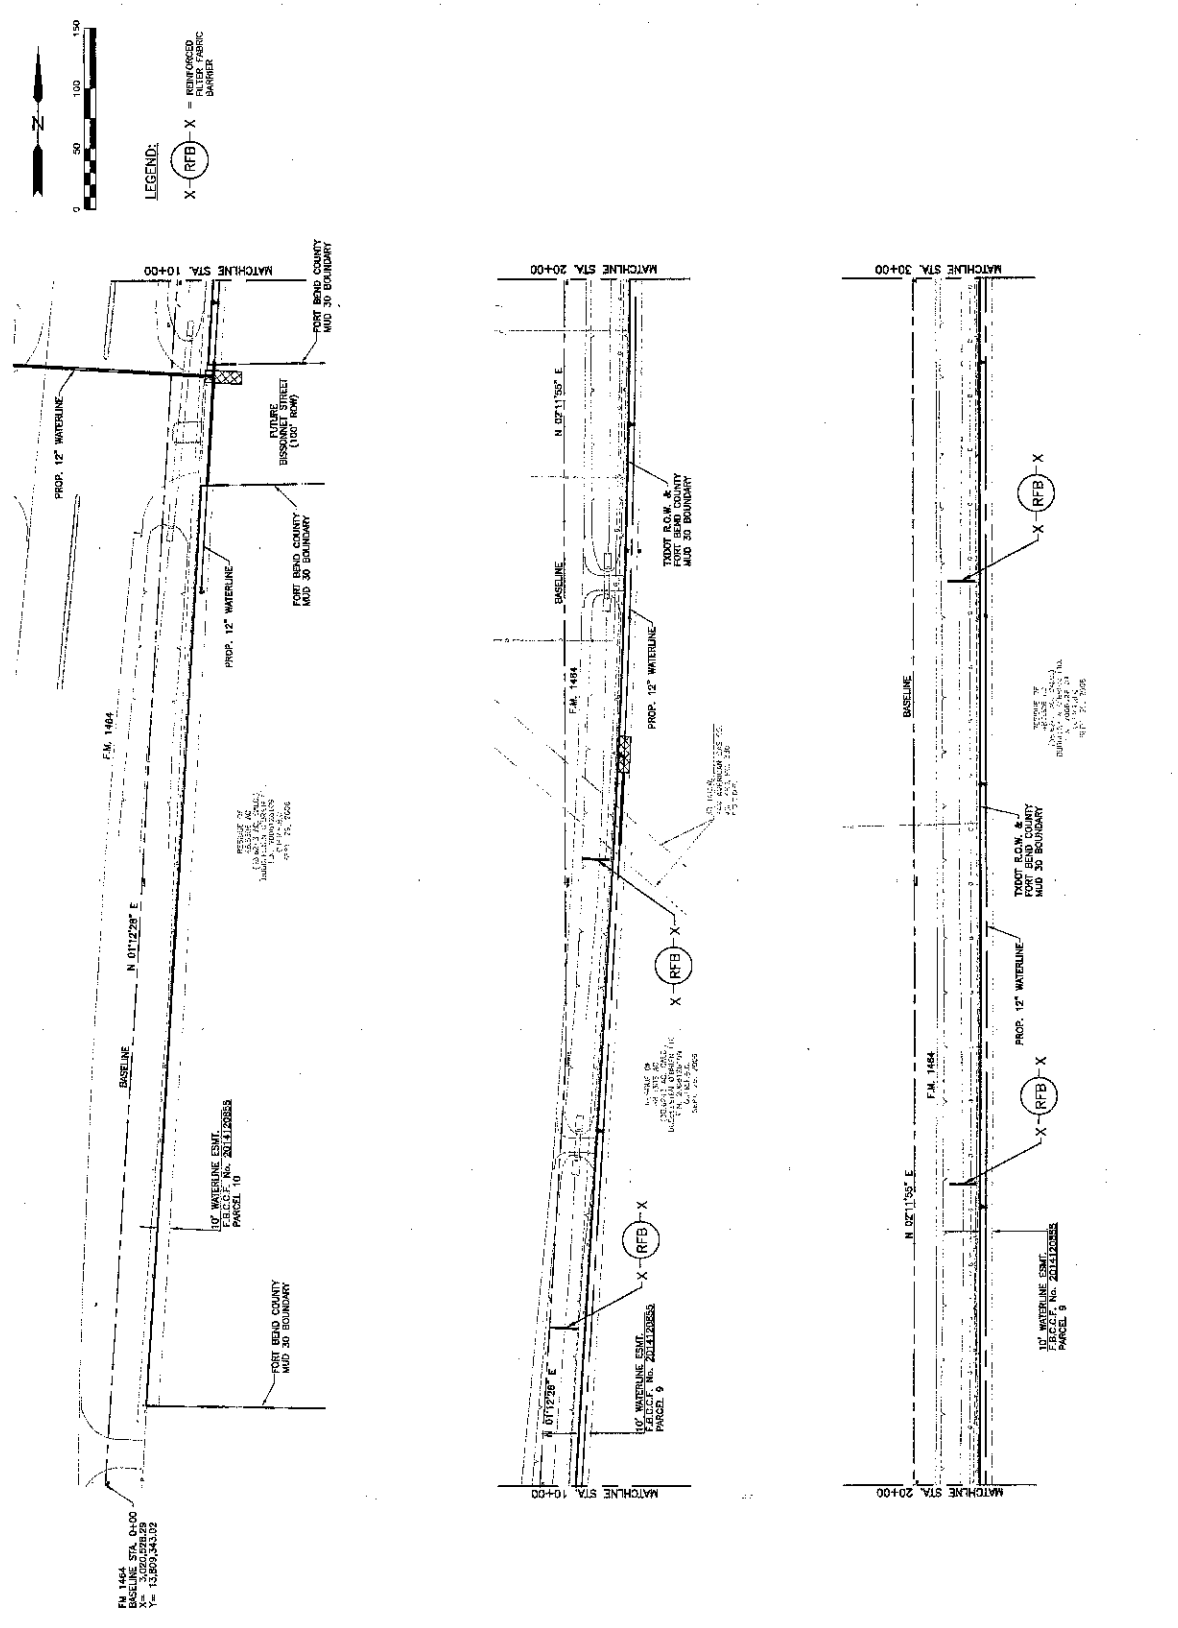

LIABILITY NOTES

ALL ATTEMPTS HAVE BEEN MADE TO ACCURATELY SHOW ALL EXISTING UNDERGROUND UTILITIES AND PIPELINES. HOWEVER, IT IS THE RESPONSIBILITY OF THE USER OF THIS PLAN TO VERIFY THE LOCATION AND DEPTH OF ALL UTILITIES AND PIPELINES. THE USER OF THIS PLAN SHALL BE RESPONSIBLE FOR ANY DAMAGE TO EXISTING UTILITIES AND PIPELINES. THE USER OF THIS PLAN SHALL BE RESPONSIBLE FOR ANY DAMAGE TO EXISTING UTILITIES AND PIPELINES. THE USER OF THIS PLAN SHALL BE RESPONSIBLE FOR ANY DAMAGE TO EXISTING UTILITIES AND PIPELINES.

CAUTION: UNDERGROUND GAS FACILITIES

UNDERGROUND GAS FACILITIES ARE LOCATED AT APPROXIMATE LOCATIONS ONLY. SERVICE LINES ARE USUALLY NOT SHOWN. THE CONTRACTOR SHALL BE RESPONSIBLE FOR VERIFYING THE LOCATION AND DEPTH OF ALL UNDERGROUND GAS FACILITIES. THE CONTRACTOR SHALL BE RESPONSIBLE FOR ANY DAMAGE TO EXISTING UNDERGROUND GAS FACILITIES. THE CONTRACTOR SHALL BE RESPONSIBLE FOR ANY DAMAGE TO EXISTING UNDERGROUND GAS FACILITIES.

WARNING:

UNDERGROUND GAS FACILITIES ARE LOCATED AT APPROXIMATE LOCATIONS ONLY. SERVICE LINES ARE USUALLY NOT SHOWN. THE CONTRACTOR SHALL BE RESPONSIBLE FOR VERIFYING THE LOCATION AND DEPTH OF ALL UNDERGROUND GAS FACILITIES. THE CONTRACTOR SHALL BE RESPONSIBLE FOR ANY DAMAGE TO EXISTING UNDERGROUND GAS FACILITIES. THE CONTRACTOR SHALL BE RESPONSIBLE FOR ANY DAMAGE TO EXISTING UNDERGROUND GAS FACILITIES.

APPROVED: *[Signature]*

DATE: 9/14/17

FOR CITY OF HOUSTON USE ONLY

FILE NO: P003-1009

DRAWING SCALE: 1"=50'

SHEET: 38 OF 42

CITY OF HOUSTON


DEPARTMENT OF PUBLIC WORKS AND ENGINEERING

 
STATIONING: STA 30+00 TO STA 60+00

PROJECT: 12" WATERLINE IMPROVEMENTS

PREVENTION PLAN

STATIONING: STA 30+00 TO STA 60+00

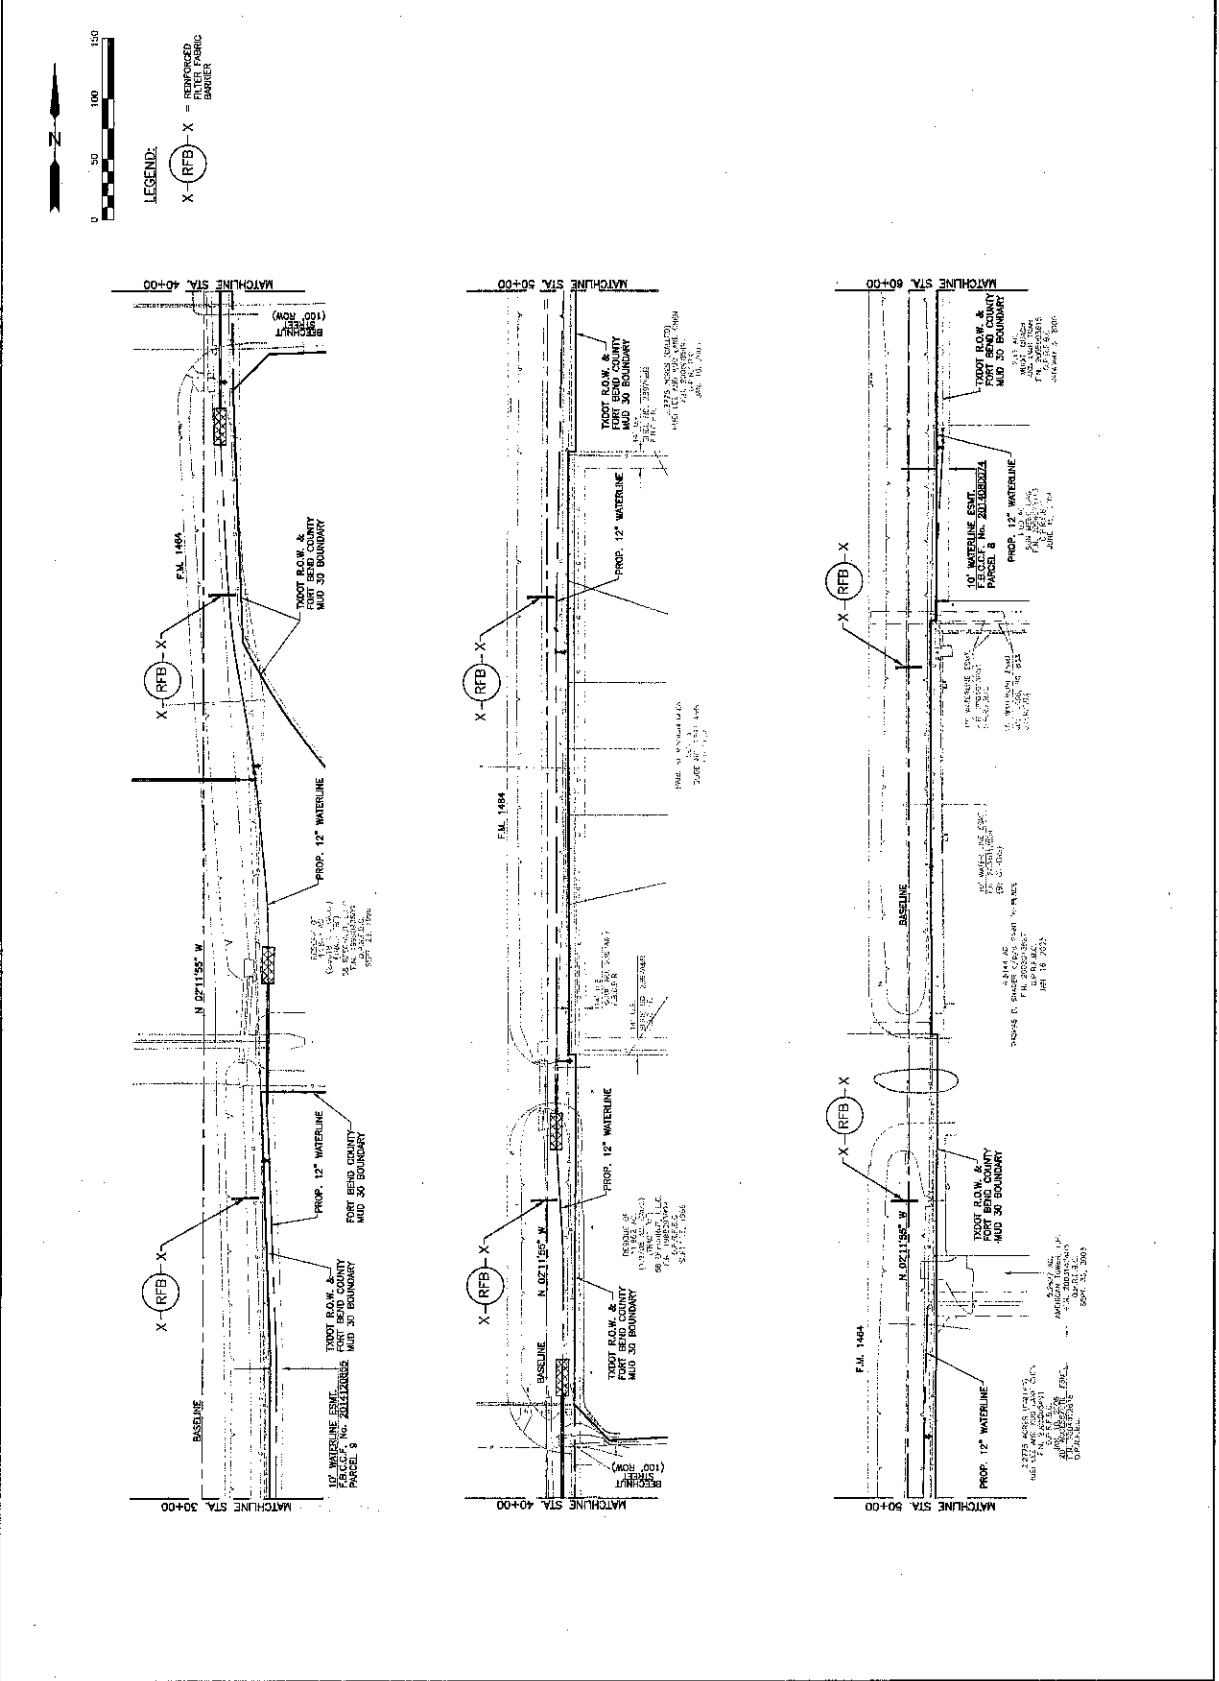



ALL ATTEMPTS HAVE BEEN MADE TO ACCURATELY SHOW ALL EXISTING UNDERGROUND UTILITIES AND PIPELINES. HOWEVER, IT IS THE RESPONSIBILITY OF THE CONTRACTOR TO HAVE THE UTILITY AND PIPELINES PHYSICALLY LOCATED IN THE FIELD PRIOR TO CONSTRUCTION. ALL LIABILITY FOR THE UTILITIES AND PIPELINES ARE SOLELY THE CONTRACTOR'S WHETHER SHOWN ON THE PLANS OR NOT.

CAUTION: UNDERGROUND GAS FACILITIES

 
THE LOCATION OF GAS LINES ARE SHOWN IN AN ATTACHED MAP. THE ONLY SERVICE LINES LOCATED AT THIS SITE ARE FOR WATER AND SEWER. CONTRACTORS MUST CONTACT THE UTILITY COORDINATING COMMITTEE AT 713-223-1867 OR 1-800-668-8344 A MINIMUM OF 48 HOURS PRIOR TO CONSTRUCTION TO HAVE MAN AND SERVICE LINES FIELD LOCATED. THE CONTRACTOR SHALL DETERMINE THE EXACT LOCATION OF ALL UTILITIES. IT IS THE CONTRACTOR'S RESPONSIBILITY TO EXACTLY LOCATE AND PRESERVE THESE UNDERGROUND FACILITIES.

WARNINGS: OVERHEAD LINES MAY EXIST ON THE PROPERTY. CONTRACTOR HAS NOT ATTEMPTED TO MARK THOSE LINES SINCE THEY ARE CLEARLY VISIBLE, BUT CONTRACTOR SHOULD LOCATE THEM PRIOR TO BEGINNING ANY CONSTRUCTION. TEXAS LAW, INCLUDING SECTION 752, RELATES TO SWEET CONTRACTORS' LIABILITY FOR THE ACTS OF THEIR EMPLOYEES AND TO THE LIABILITY OF THE CONTRACTOR AND OWNERS ARE LEGALLY LIABLE FOR THE ACTS OF THEIR EMPLOYEES. CONTRACTOR AND OWNERS ARE LEGALLY RESPONSIBLE FOR SAFETY OF CONSTRUCTION WORKERS UNDER THIS LAW. THIS LAW CARRIES BOTH CRIMINAL AND CIVIL LIABILITY.

[illegible]

APPROVED: *[Signature]*
DEVELOPMENT COORDINATOR

DATE: 9/3/19



FORT BEND COUNTY M.U.D. NO. 30
FM 1464 - PHASE I

12" WATERLINE IMPROVEMENTS
TRAFFIC CONTROL PLANTRAFFIC CONTROL PLAN
STA. 0+00 TO STA. 30+00

CITY OF HOUSTON

DEPARTMENT OF PUBLIC WORKS AND ENGINEERING
INFORME & TRANSPORTATION

FACTORY	
STORAGE WATER QUALITY	


SECRET & DIS
61081301407

FILE NO: 2003-1009

READING SCALE

1-50
68731

34 OF 42



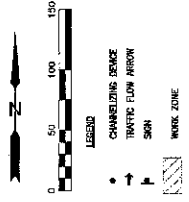
[illegible]

1000

1. ALL WORK SHALL BE DONE WITHIN TxDOT R.O.W. OR PROPOSED EASEMENT LIMITS. NO PARKING OF VEHICLES SHALL BE ALLOWED ON SHOULDER. REFER TO TxDOT STANDARD TOPS (1-1)-12.
2. SIDEWALK CLOSURES SHALL BE TEMPORARY AND ONLY DURING BUSINESS HOURS.

SEQUENCE OF CONSTRUCTION:

- RE-STAKE LIMITS OF RIGHT-OF-WAY, CLEARING & GRUBBING, THEN STAKING OF ALIGNMENT. SET UP ADVANCED WARNING SIGNS AND CHANNELIZING DEVICES FROM BEGINNING TO END OF PROJECT AND AT SIDE STREETS, AS NEEDED. PLACE STORM WATER POLLUTION PREVENTION PLAN. SET CONSTRUCTION ENTRANCE NEAR BELLAIRE BLVD. ENSURE SWMP IS INSPECTED PROPERLY AND MAINTAINED. CONSTRUCT AND INSTALL SWMP TO PROTECT STORM SEWERS AND RIGHPS ON F.M. 1404. BORE UNDER SIGNAGE AND PRELIMES AND CONSTRUCT WATERLINE. REMOVE TOP DEVICES, SIGNING, SWMP, SALT FENCE

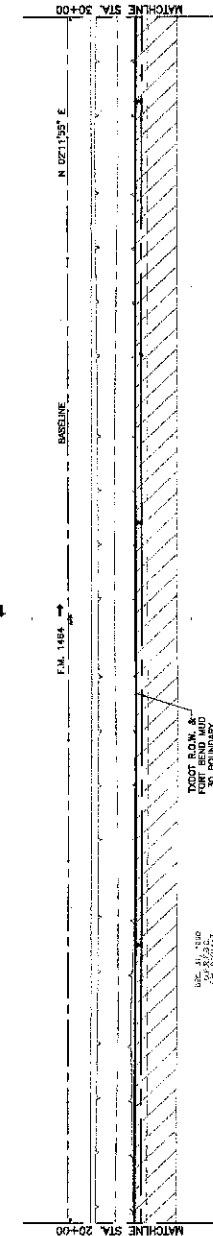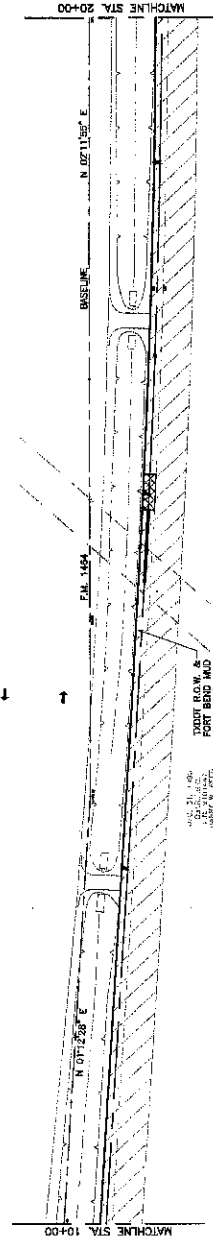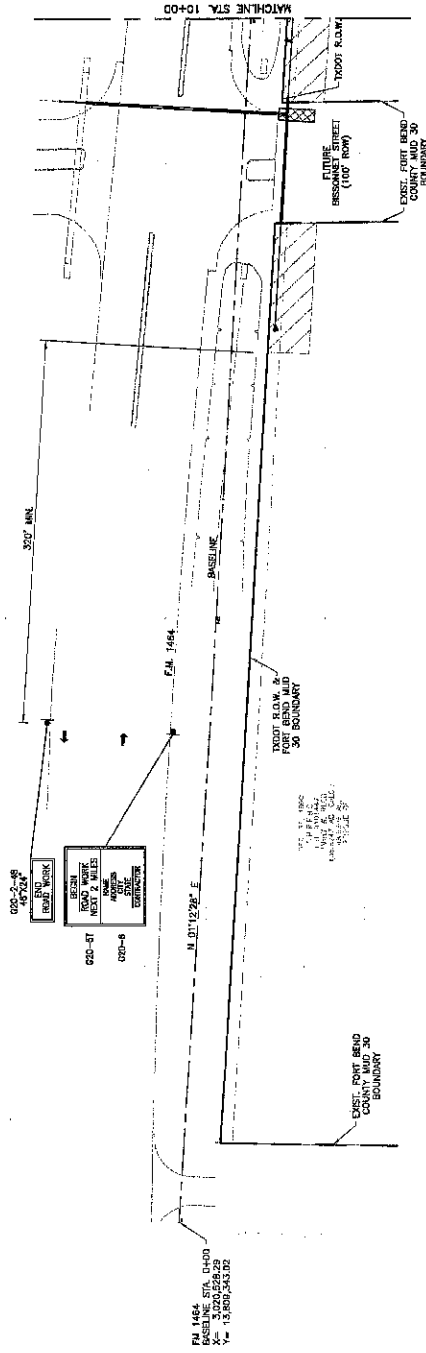

UTILITY NOTES

ALL ATTEMPTS HAVE BEEN MADE TO LOCATE ALL UTILITIES AND PRELINES. HOWEVER, IT IS THE RESPONSIBILITY OF THE CONTRACTOR TO VERIFY THE LOCATION OF ALL UTILITIES AND PRELINES IN THE FIELD PRIOR TO ANY CONSTRUCTION. THE CONTRACTOR SHALL BE RESPONSIBLE FOR THE LOCATION OF ALL UTILITIES AND PRELINES AND SHALL BE SOLELY RESPONSIBLE FOR THE LOCATION OF ALL UTILITIES AND PRELINES.

CAUTION: UNDERGROUND GAS FACILITIES LOCATION OF GAS LINES ARE SHOWN IN AN UNUSUAL MANNER. THE CONTRACTOR SHALL BE RESPONSIBLE FOR THE LOCATION OF ALL UTILITIES AND PRELINES AND SHALL BE SOLELY RESPONSIBLE FOR THE LOCATION OF ALL UTILITIES AND PRELINES.

CAUTION: UNDERGROUND GAS FACILITIES LOCATION OF GAS LINES ARE SHOWN IN AN UNUSUAL MANNER. THE CONTRACTOR SHALL BE RESPONSIBLE FOR THE LOCATION OF ALL UTILITIES AND PRELINES AND SHALL BE SOLELY RESPONSIBLE FOR THE LOCATION OF ALL UTILITIES AND PRELINES.

 


- CHANNELIZING DEVICE
- TRAFFIC FLOW ARROW
- SON
- WORK ZONE

NOTES

1. ALL WORK SHALL BE DONE WITHIN TYPICAL R.O.W. OR PROPOSED EASEMENT LIMITS. UNLESS OTHERWISE NOTED, ALL WORK SHALL BE DONE WITHIN THE TYPICAL R.O.W. OR PROPOSED EASEMENT LIMITS.
2. ALL WORK SHALL BE DONE WITHIN TYPICAL R.O.W. OR PROPOSED EASEMENT LIMITS. UNLESS OTHERWISE NOTED, ALL WORK SHALL BE DONE WITHIN THE TYPICAL R.O.W. OR PROPOSED EASEMENT LIMITS.

SEQUENCE OF CONSTRUCTION

1. RE-STAKE LIMITS OF RIGHT-OF-WAY, CLEARING & GRUBBING, THEN STAKING OF ALIGNMENT.
2. CHANNELIZING DEVICES FROM BEGINNING TO END OF PROJECT AND AT SIDE STREETS AS NEEDED. PLAN AND PROFILE SHALL BE USED TO DETERMINE LOCATION OF CHANNELIZING DEVICES.
3. SET FENCES. FENCES SHALL BE INSTALLED BEFORE ANY OTHER CONSTRUCTION.
4. ERECTION OF ALL SIGNS IS NEEDED BEFORE ANY OTHER CONSTRUCTION.
5. ERECTION OF ALL SIGNS IS NEEDED BEFORE ANY OTHER CONSTRUCTION.
6. ERECTION OF ALL SIGNS IS NEEDED BEFORE ANY OTHER CONSTRUCTION.
7. ERECTION OF ALL SIGNS IS NEEDED BEFORE ANY OTHER CONSTRUCTION.
8. ERECTION OF ALL SIGNS IS NEEDED BEFORE ANY OTHER CONSTRUCTION.
9. ERECTION OF ALL SIGNS IS NEEDED BEFORE ANY OTHER CONSTRUCTION.

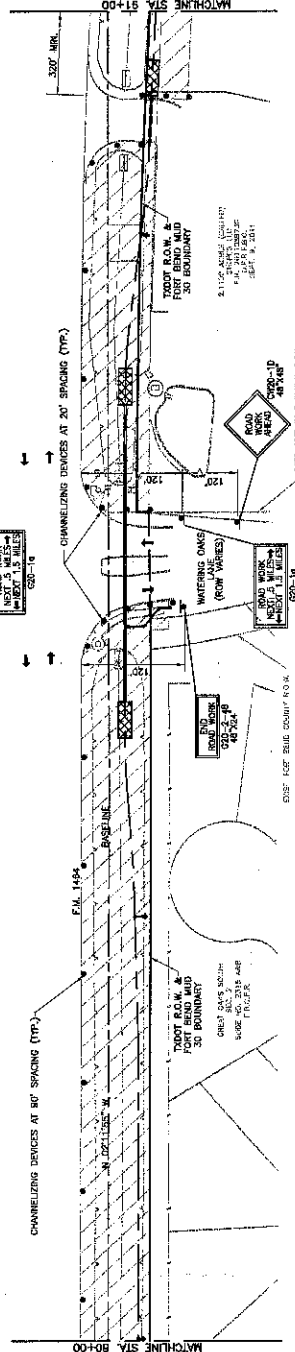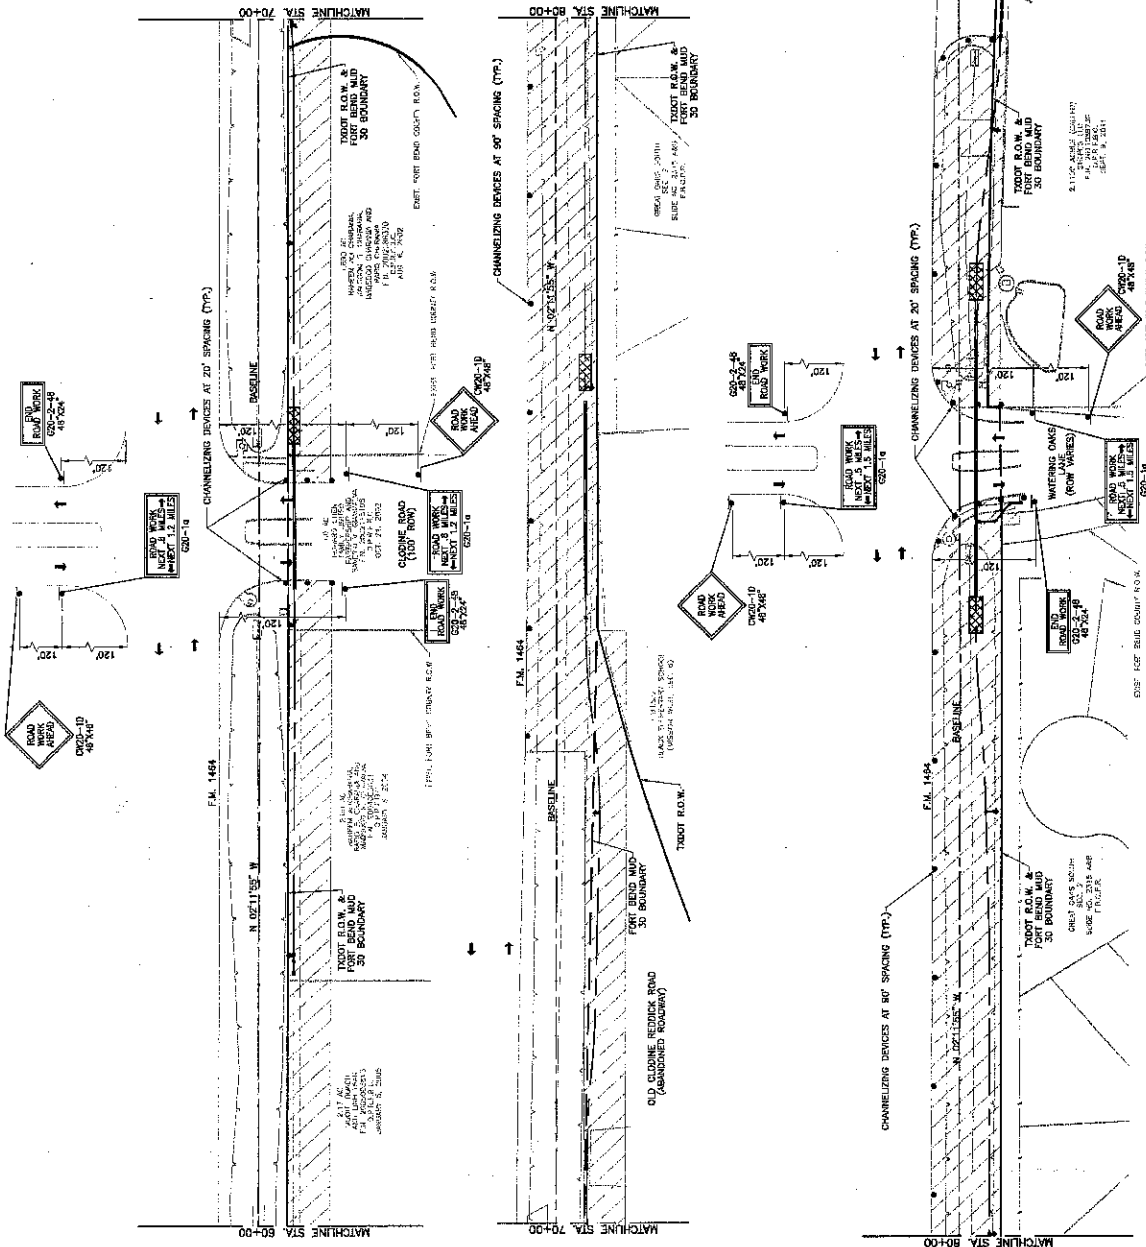

APPROVED: *[Signature]*
DATE: 9/17/12

FOR FORT BEND COUNTY M.D. NO. 30
FM 1464 - PHASE 1
12" WATERLINE IMPROVEMENTS

TRAFFIC CONTROL PLAN
STA: 60+00 TO STA: 91+00

CITY OF HOUSTON
DEPARTMENT OF PUBLIC WORKS AND BUILDINGS

FILE NO.:
FOOD-1000

DRAWING SCALE
1"=50'

SHEET 38 OF 42

FOR CITY OF HOUSTON USE ONLY

ALL ATTEMPTS HAVE BEEN MADE TO ACCURATELY SHOW ALL EXISTING UNDERGROUND UTILITIES AND PIPELINES. HOWEVER, IT IS THE RESPONSIBILITY OF THE CONTRACTOR TO HAVE THE UTILITY AND PIPELINES PHYSICALLY LOCATED IN THE FIELD PRIOR TO CONSTRUCTION. ALL LIABILITY FOR THE UTILITIES AND PIPELINES ARE SOLELY THE CONTRACTOR'S WHETHER SHOWN ON THE PLANS OR NOT.

CAUTION: UNDERGROUND GAS FACILITIES
LOCATION OF GAS LINES ARE SHOWN IN AN
APPROXIMATE LOCATION ONLY. SERVICE LINES
ARE USUALLY NOT SHOWN. THE CONTRACTOR
SHALL CONTACT THE UTILITY COORDINATING
COMMITTEE AT 713-223-4557 OR
1-800-669-3344 A MINIMUM OF 48 HOURS

PRIOR TO CONSTRUCTION TO HAVE MAIN AND SERVICE LINES FIELD LOCATED, THE CONTRACTOR SHALL DETERMINE THE EXACT LOCATION BEFORE COMMENCING WORK AND AGREE TO BE FULLY RESPONSIBLE FOR ANY DAMAGES CAUSED BY HIS FAILURE TO EXACTLY LOCATE AND PRESERVE THESE UNDERGROUND FACILITIES.

WARNING: OVERHEAD LINES MAY EXIST ON THE PROPERTY. WE HAVE NOT ATTEMPTED TO MARK THOSE LINES SINCE THEY ARE CLEARLY VISIBLE, BUT CONTRACTOR SHOULD LOCATE THEM PRIOR TO BEGINNING ANY CONSTRUCTION. TEXAS LAW.

SECTION 752, HEALTH & SAFETY CODE, FORBIDS ALL ACTIVITIES IN WHICH PERSONS OR THINGS MAY COME WITHIN SIX (6) FEET OF LIVE OVERHEAD HIGH VOLTAGE LINES. CONTRACTOR AND OWNERS ARE LEGALLY RESPONSIBLE FOR SAFETY OF CONSTRUCTION WORKERS UNDER THIS LAW. THIS LAW CARRIES BOTH CRIMINAL AND CIVIL LIABILITY.

CONCLUSIONS

REVISED	DATE	BY	REASON

Question	Text	Answer	Score
1	What is the main purpose of the text?	To inform the reader about the importance of recycling.	1
2	Which of the following is NOT a benefit of recycling?	It saves time.	1
3	What is the author's tone in the text?	Informative and persuasive.	1
4	What is the main idea of the text?	Recycling is essential for a sustainable future.	1
5	What is the author's opinion on recycling?	Positive.	1

APPROVED: L. E. H.
DEVELOPMENT COORDINATOR
9/2/72

DATE: 4/5/77

JACOSTANZA & ASSOCIATES
ATTORNEYS AT LAW
1000 N. CENTRAL AVE., SUITE 200
CHICAGO, ILL. 60610
(312) 527-1100

FORT BEND COUNTY M.U.D. NO. 30
FM 1464 - PHASE I
12" WATERLINE IMPROVEMENTS

TRAFFIC CONTROL PLAN
STA. 91+00 TO END OF PROJECT

OFFICE OF THE CITY CLERK
CITY OF HOUSTON
DEPARTMENT OF PUBLIC WORKS AND ENGINEERING
NAME: *[Signature]* DATE: *[Signature]* 11/13/2013

DATE	7-23-68	
TIME	10:30 AM	
BY	J. J. [Signature]	
REMARKS	See page 3-27	
APPROVING AUTHORITY	[Signature]	

FILE NO:
FO03-1009

DRAWING SCALE

1"=50'

SHEET 7 OF 42

08731


U.S. GEOLOGICAL SURVEY


WATER RESOURCES DIVISION


ALBUQUERQUE, NEW MEXICO





1961

No: 37 Of 42

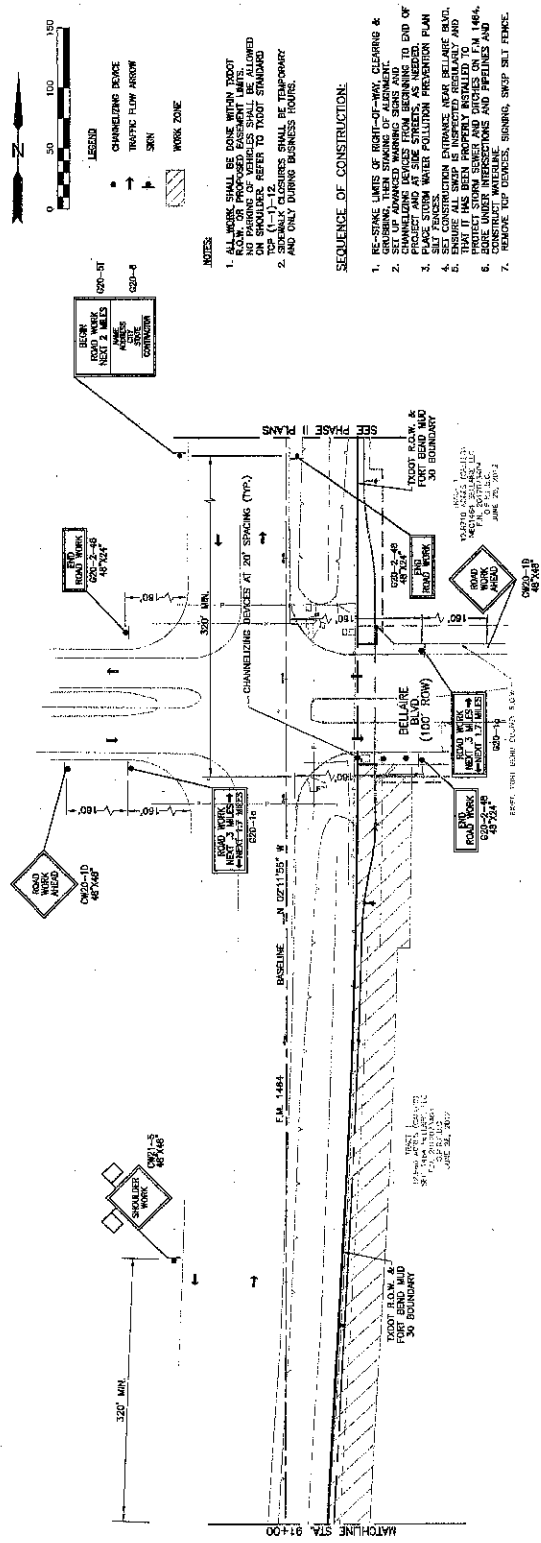

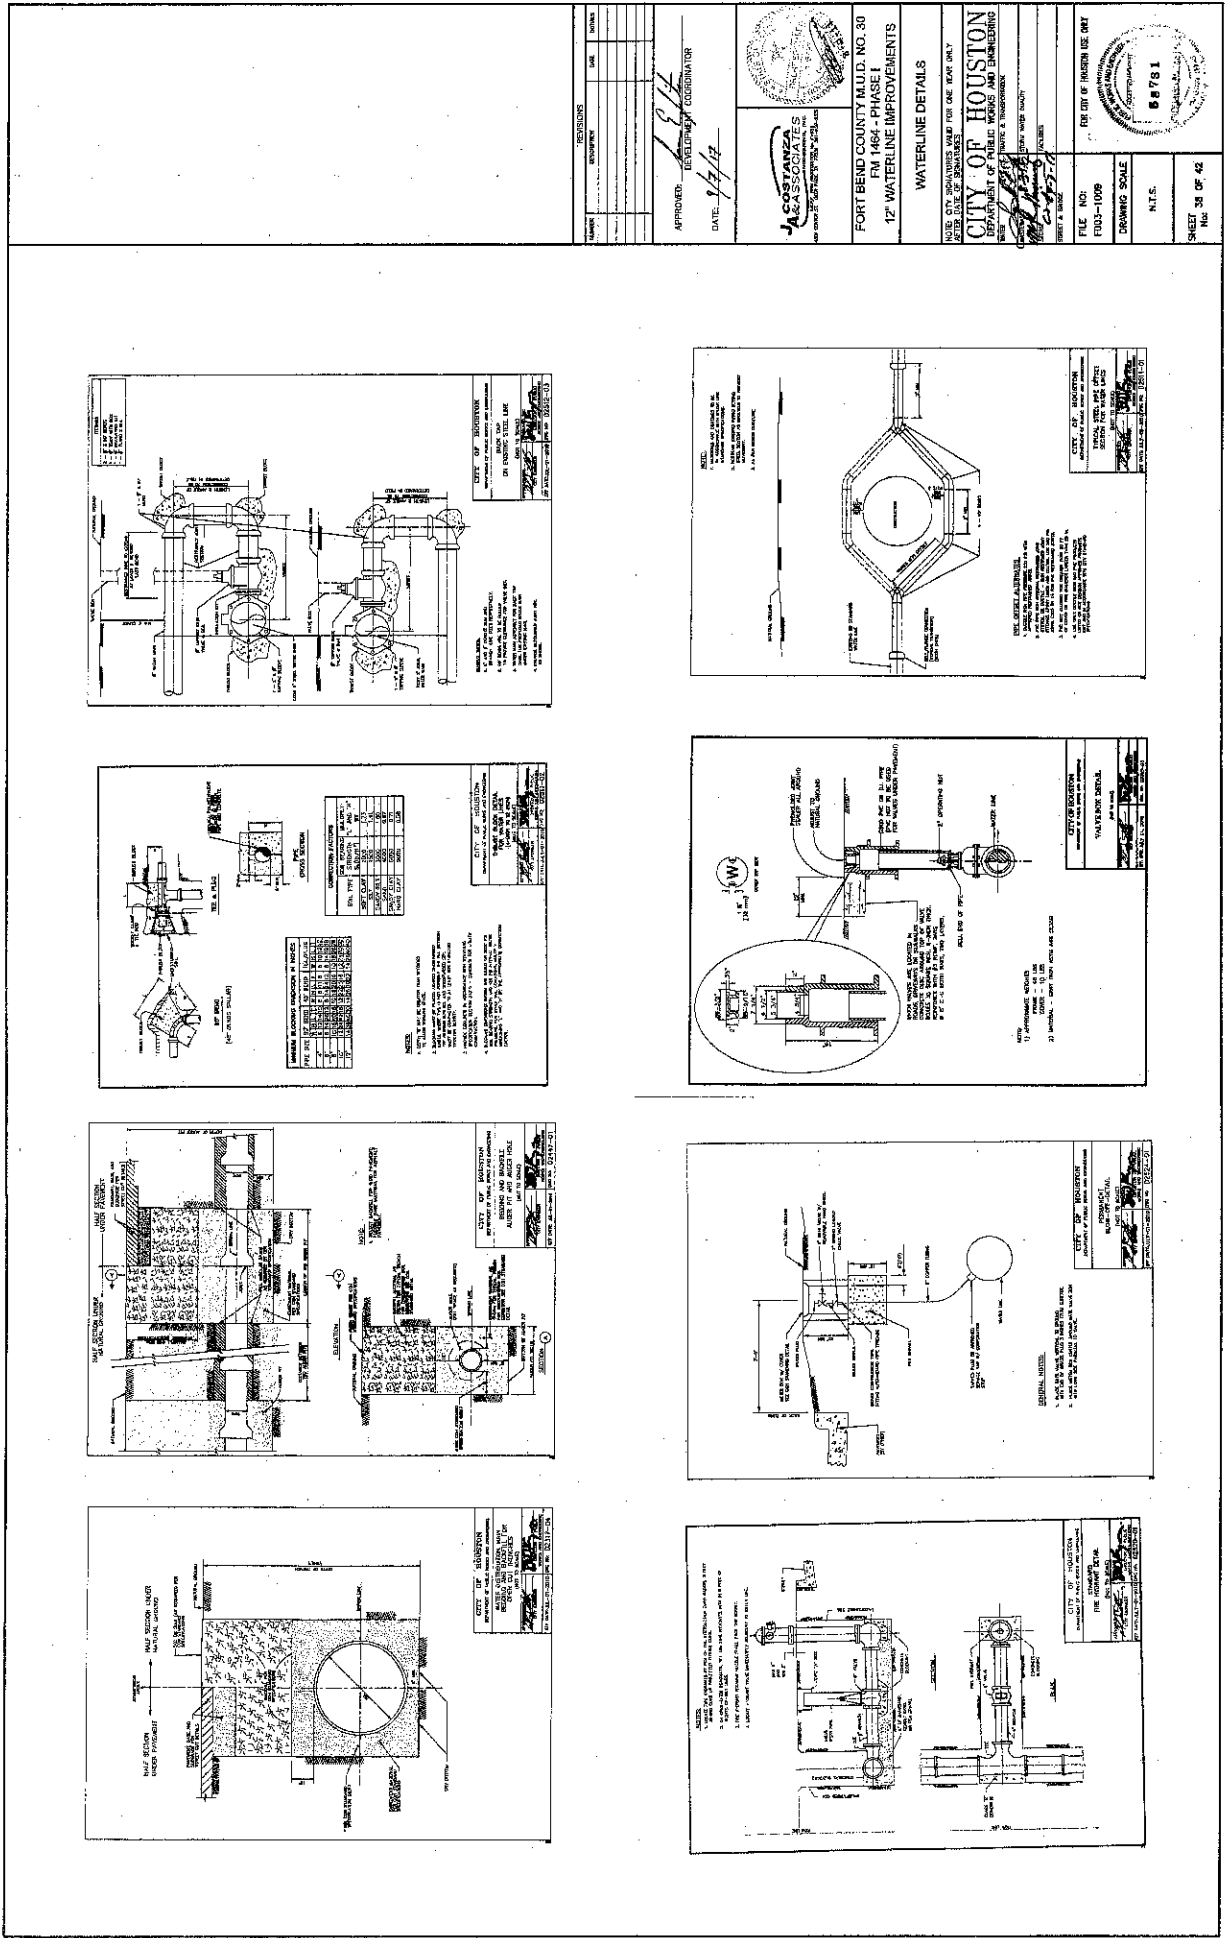

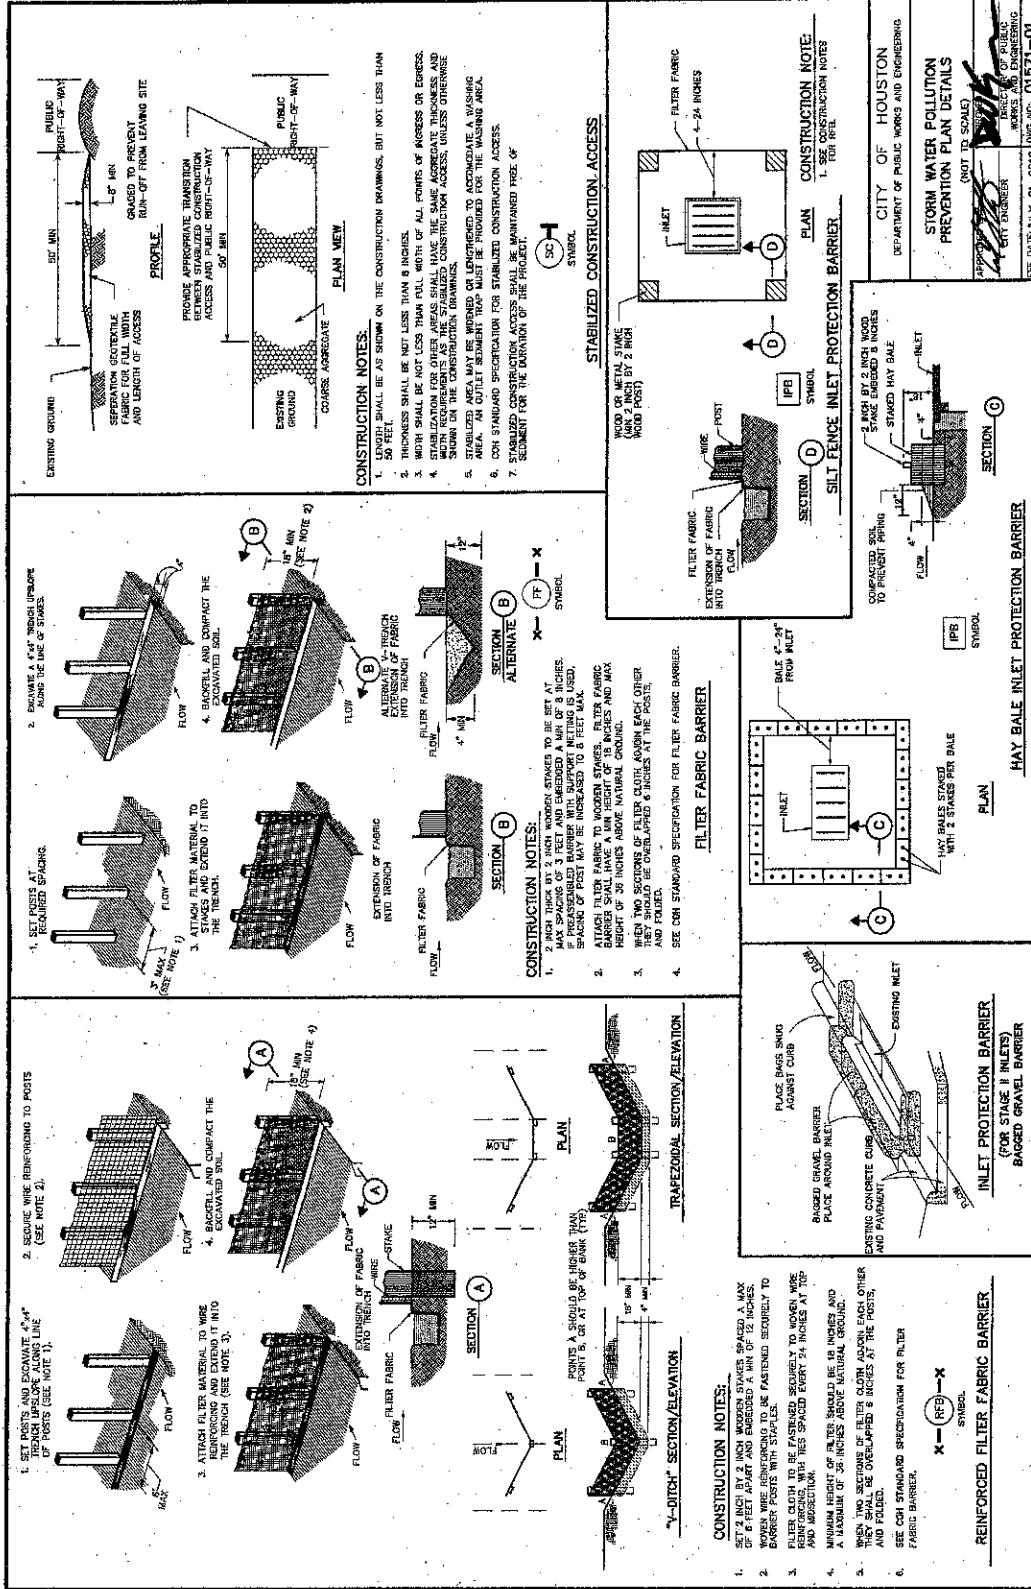

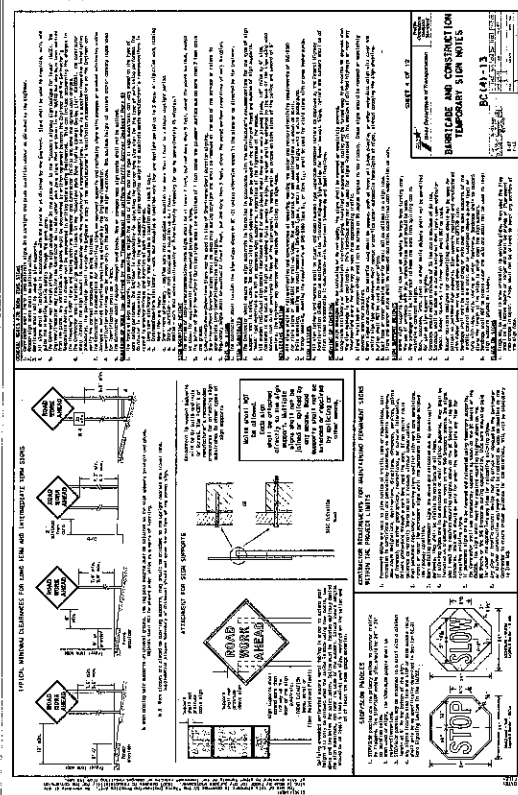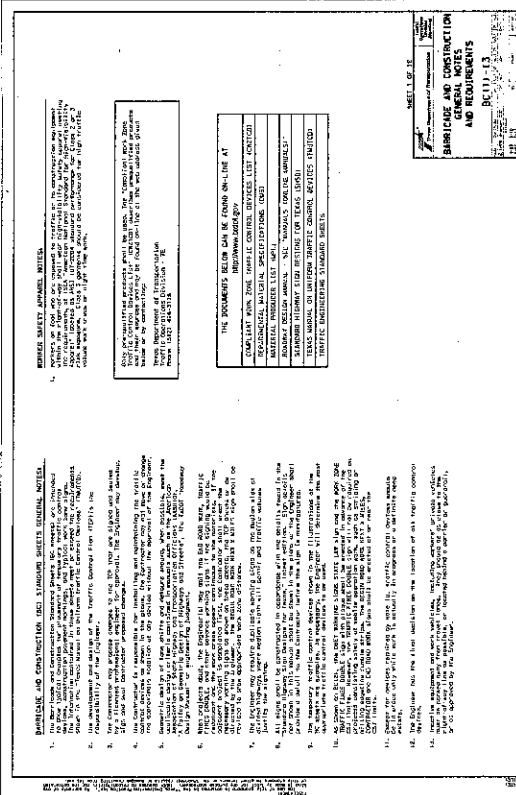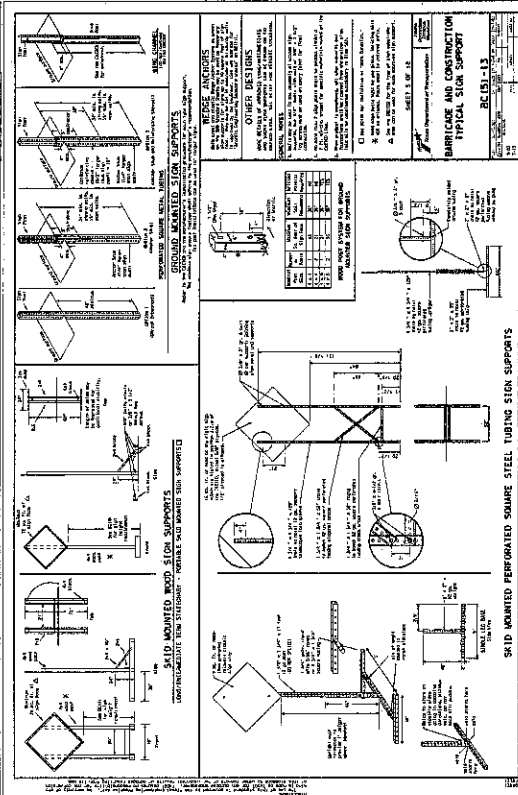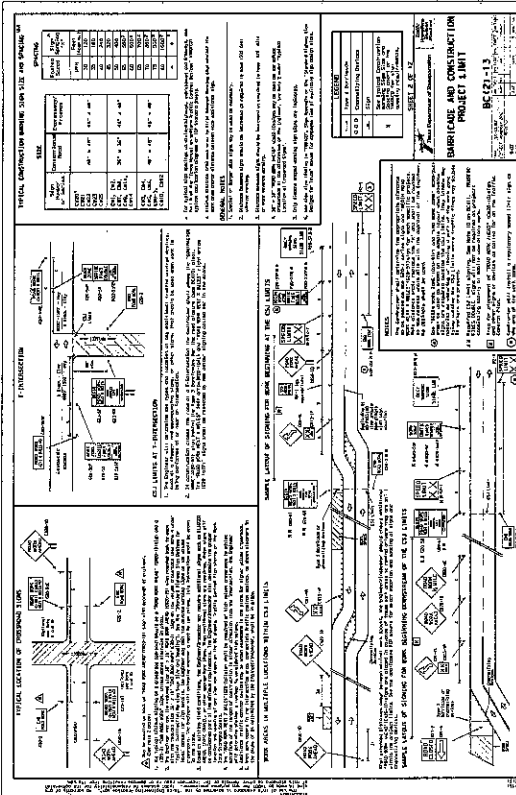

Form # 10-45	RECEIVED FBI JAN 10 1964	DATE: 1/10/64	TO: DIRECTOR, FBI
FROM: SAC, NEW YORK	RE: JAMES EARL RAY ALLEGEDLY AKA OF SUBJECT IN NEW YORK	RE: JAMES EARL RAY ALLEGEDLY AKA OF SUBJECT IN NEW YORK	RE: JAMES EARL RAY ALLEGEDLY AKA OF SUBJECT IN NEW YORK
SUBJECT: MURDER OF MARTIN LUTHER KING, JR.	RE: JAMES EARL RAY ALLEGEDLY AKA OF SUBJECT IN NEW YORK	RE: JAMES EARL RAY ALLEGEDLY AKA OF SUBJECT IN NEW YORK	RE: JAMES EARL RAY ALLEGEDLY AKA OF SUBJECT IN NEW YORK
DATE: 1/10/64	RE: JAMES EARL RAY ALLEGEDLY AKA OF SUBJECT IN NEW YORK	RE: JAMES EARL RAY ALLEGEDLY AKA OF SUBJECT IN NEW YORK	RE: JAMES EARL RAY ALLEGEDLY AKA OF SUBJECT IN NEW YORK
TO: DIRECTOR, FBI	RE: JAMES EARL RAY ALLEGEDLY AKA OF SUBJECT IN NEW YORK	RE: JAMES EARL RAY ALLEGEDLY AKA OF SUBJECT IN NEW YORK	RE: JAMES EARL RAY ALLEGEDLY AKA OF SUBJECT IN NEW YORK
FROM: SAC, NEW YORK	RE: JAMES EARL RAY ALLEGEDLY AKA OF SUBJECT IN NEW YORK	RE: JAMES EARL RAY ALLEGEDLY AKA OF SUBJECT IN NEW YORK	RE: JAMES EARL RAY ALLEGEDLY AKA OF SUBJECT IN NEW YORK
SUBJECT: MURDER OF MARTIN LUTHER KING, JR.	RE: JAMES EARL RAY ALLEGEDLY AKA OF SUBJECT IN NEW YORK	RE: JAMES EARL RAY ALLEGEDLY AKA OF SUBJECT IN NEW YORK	RE: JAMES EARL RAY ALLEGEDLY AKA OF SUBJECT IN NEW YORK

