

REVIEW BY FORT BEND COUNTY COMMISSIONERS COURT

On this 28 day of SEPTEMBER, 2010, before the Fort Bend Commissioners Court came on to be heard and reviewed the accompanying notice of PHONOSCOPE L.L.C.

Job Location WESTPARK TOLLWAY

Dated 09/21/10 BOND NO 103827669 Permit No. 83828
to make use of certain Fort Bend County property subject to, "A Revised Order Regulating the Laying, Construction, Maintenance, and Repair of Buried Cables, Conduits, and Pole Lines, In, Under, Across or Along Roads, Streets, Highways, and Drainage Ditches in Fort Bend County, Texas, Under the Jurisdiction of the Commissioners Court of Fort Bend County, Texas," as passed by the Commissioners Court of Fort Bend County, Texas, date the 3rd day of August, 1987, recorded in Volume _____ of the Minutes of the Commissioners Court of Fort Bend County, Texas, to the extent that such order is not inconsistent with Article 1436a, Vernon's Texas Civil Statutes. Upon Motion of Commissioner Meyers, seconded by Commissioner Prestage, duly put and carried, it is ORDERED, ADJUDGED AND DECREED that said notice of said above purpose is hereby acknowledged by the Commissioners Court of Fort Bend County, Texas, and that said notice be placed on record according to the regulation order thereof.

Notes:

1. Evidence of review by the Commissioners Court must be kept on the job site and failure to do so constitutes grounds for job shutdown.
2. Written notices are required:
 - a. 48 hours in advance of construction start up, and
 - b. When construction is completed and ready for final inspection

Mail notices to: Permit Administrator
Fort Bend County Engineering
P.O. Box 1449
Rosenberg, Texas 77471
281-633-7500

3. This permit expires one (1) year from date of permit if construction has not commenced.

By [Signature]
County Engineer

By N/A
Drainage District Engineer/Manager

Presented to Commissioners Court
and approved.
Recorded in Volume 9-28-10
Minutes of Commissioners Court.

Clerk of Commissioners Court
By [Signature]
Deputy

Engineering Department

1124 Blume Road
Phone: (281) 341-7500

PERMIT NO. 003828

Date 09/21/2010

NOTICE OF PROPOSED CABLE, CONDUIT AND/OR POLE LINE ACTIVITY
IN, UNDER, ACROSS OR ALONG ROADS, STREETS, HIGHWAYS AND DRAINAGE DITCHES
IN FORT BEND COUNTY

APPLICANT'S JOB NO. _____
PERMIT No. 83828 PCT. No. 3
BOND No. 103827669

Formal notice is hereby given that PHONOSCOPE L.L.C
proposes to lay, construct, maintain and/or repair cable, conduit and/or pole line, in, under, across, or
along roads, streets, highways and drainage ditches in Fort Bend County, as follows:

In, Under, or Across Roads and/or Drainage Ditches

Road or Ditch Name	Distance & Direction From Nearest Intersection	Length of Crossing	Type of Construction			
			Bored:	Jacked:	Driven:	Case

Along Roads and/or Drainage Ditches

Road or Ditch Name	Distance & Direction From Nearest Intersection	To	Distance
WESTPARK TOLLWAY	73' E/C/L WEST OF F.M. 1464	EXISTING UTILITY POLE EAST OF F.M. 1093	783'

General Description

PROPOSE TO BORE AND INSTALL (1) 4" PVC CONDUIT
ENCASING FIBER OPTIC CABLE

The Location and description of the proposed installation and appurtenances is more fully shown on the
attached detail drawings. The laying, construction, maintenance and/or repair of the proposed installation
shall be subject to "A Revised Order Regulating the Laying, Construction, Maintenance and/or Repair of
Cables, Conduits, and/or Pole Lines, In, Under, Across, or Along Roads, Streets, Highways and Drainage
Ditches in Fort Bend County, Texas, Under the Jurisdiction of the Commissioners Court of Fort Bend
County, Texas," as passed by Commissioners Court of Fort Bend County, Texas, dated the 3rd. day of
August, 1987, recorded in Volume 639 of the Minutes of the Commissioners Court of Fort Bend County,
Texas.

Written notices are required: 1) 48 hours in advance of start of construction and 2) when construction is
complete and ready for final inspection.

Mail to: Permit Administrator/Fort Bend County Engineering
P.O. Box 1449, Rosenberg, TX 77471.

Violation of requirements shall constitute grounds for job shut down.

COMPANY NAME: PHONOSCOPE L.L.C.
AGENT and/or OWNER

(Signature)


NAME & TITLE: HARRELL TAYLOR / AUTOCAD
(Please Print) DRAFTER

DATE: 9/15/2010

ADDRESS: 6105 WESTLINE DR
(Street/P.O. Box)

HOUSTON TEX 77036
City State Zip

TELEPHONE NO: (713) 272-4600
(accessible 24 hrs/day, 7 days/week)

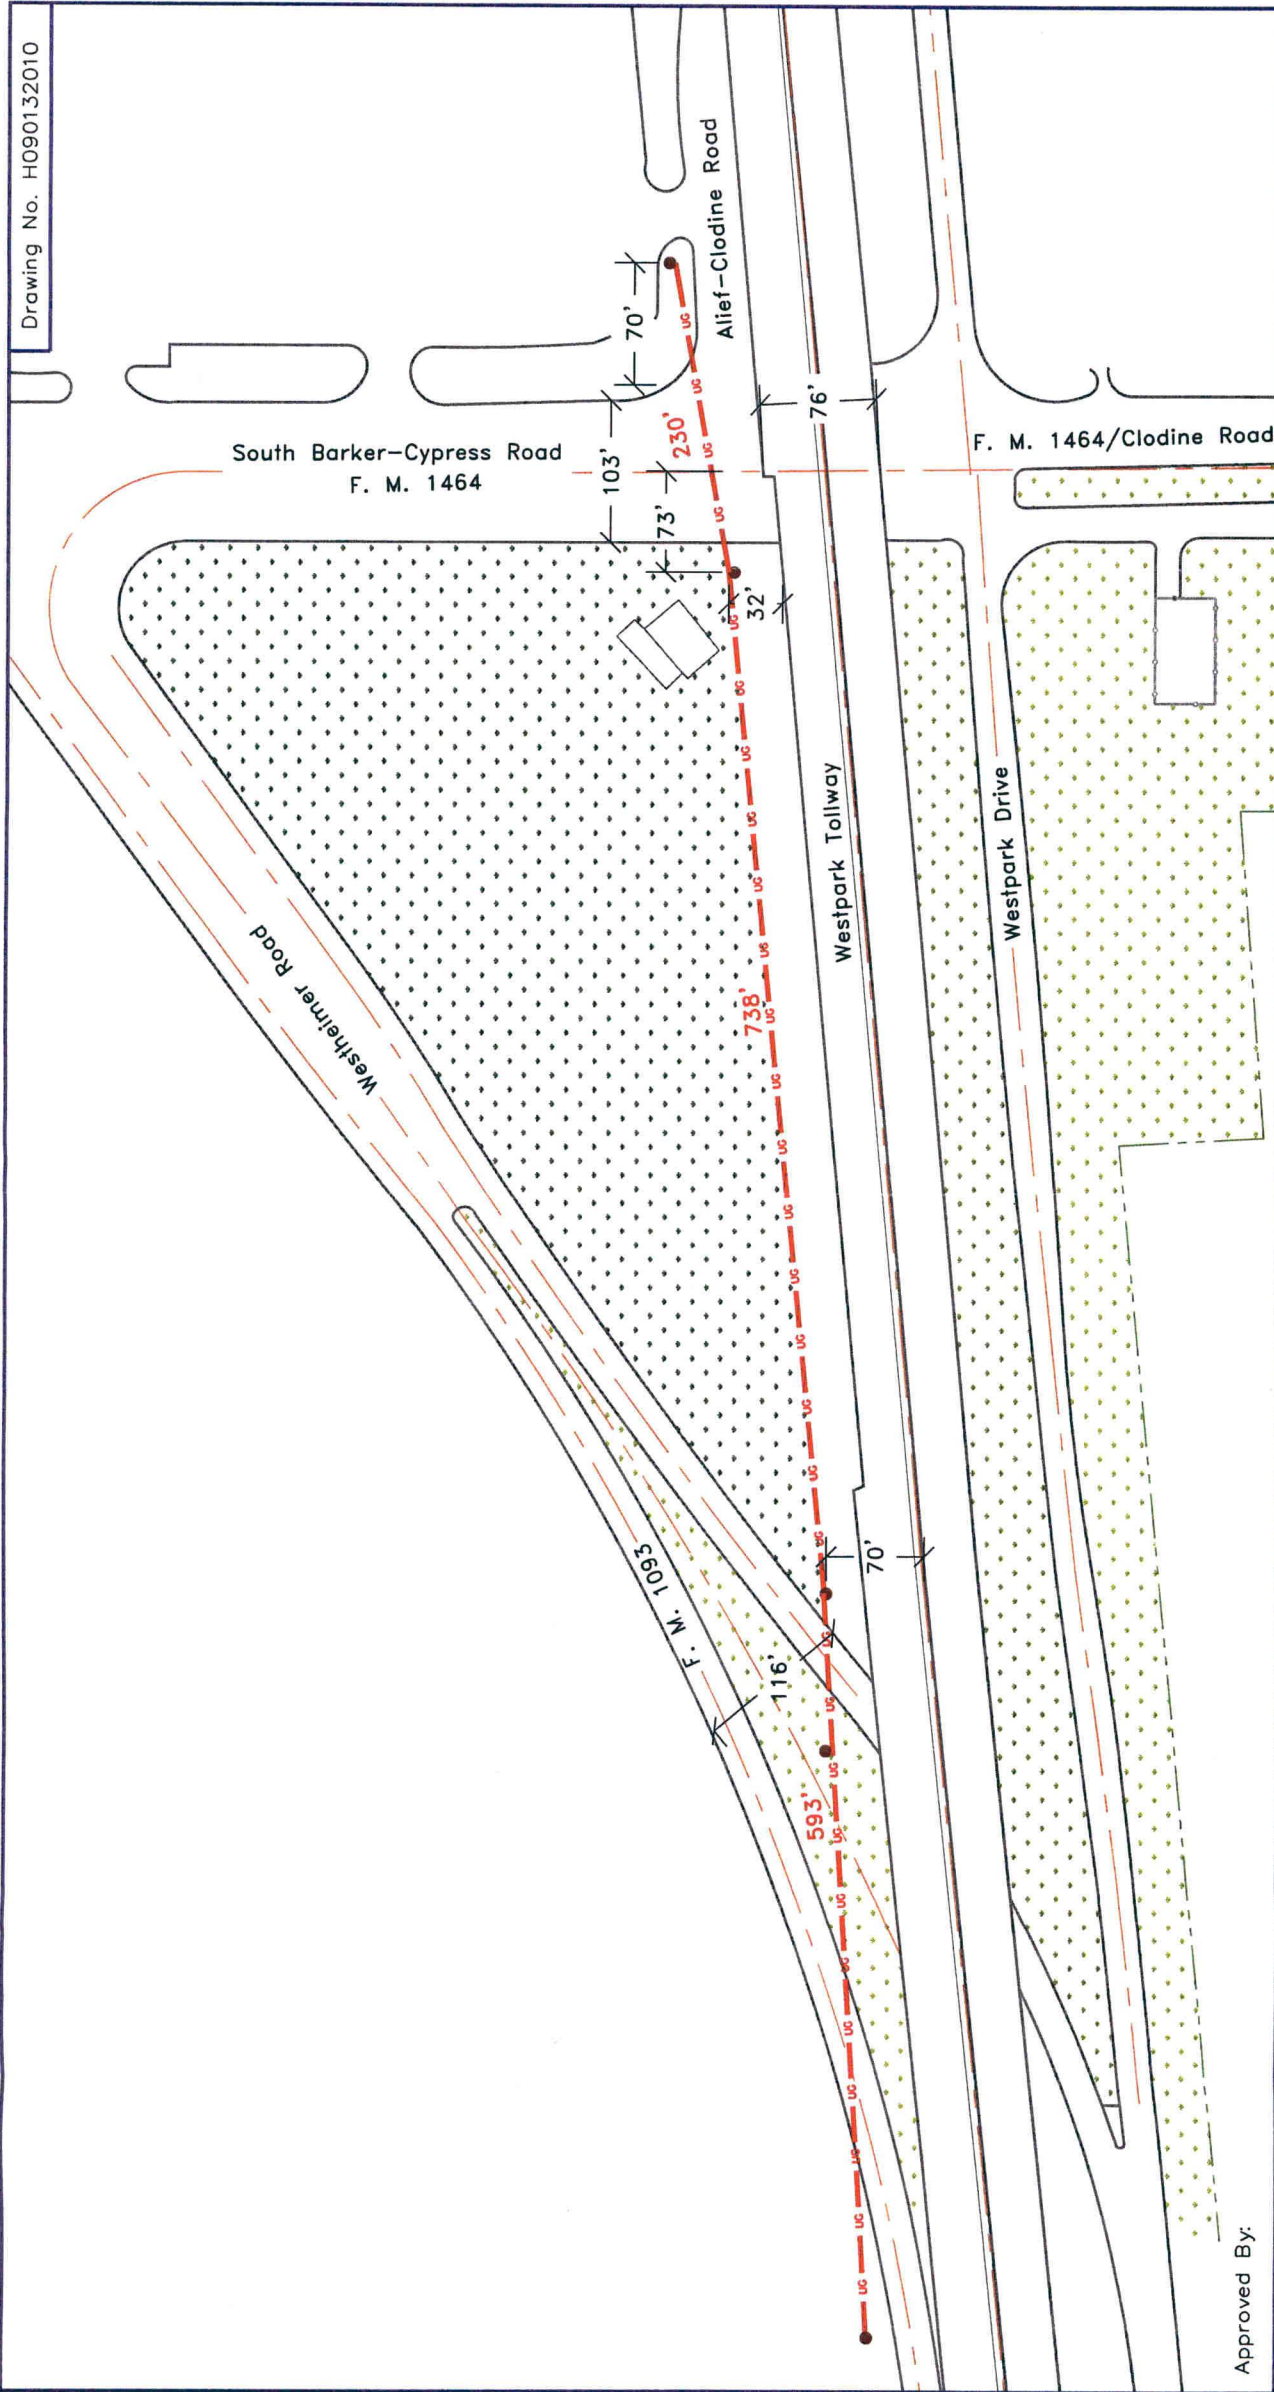

Approved By:

Symbol	Description	Revisions
UG	(1) 4" PVC conduit encasing fiber optic cable underground @ min depth of 60" below existing grade	
•	Existing Utility poles	
---	MCI Underground Utility fiber line	
---	AT&T Underground Utility fiber line	
---	Water Utility line	

Drawn By: Harrell Taylor

Scale: N.T.S.

Date: 09/14/2010



Key Map: 527 E



PHONOSCOPE

FIBERTOWER - HOU2901

Notice of Proposed Utility Installation

Proposed Underground Wireline Construction

Site Plan- UG ROW of Westpark Tollway

1 of 4

W. O.# 43370 & 43371


WESTPARK TOLLWAY/ F.M. 1093 R.O.W. Profile Dwg

DWG NO#. H091142010

General:

- 1) Phonoscope fiber located ~Westpark Tollway between F.M 1093 & F.M 1464.
- 2) Fiber optic cable located at a min. depth of 60" below existing ground.
- 3) All information current as of Oct. of 2010 on proposed Phonoscope, L.L.C. Fiber Optic Cable.


WESTPARK TOLLWAY/ F.M. 1093 @ CANAL RD.
Proposed Underground Fiber Optic Line
Profile Plan

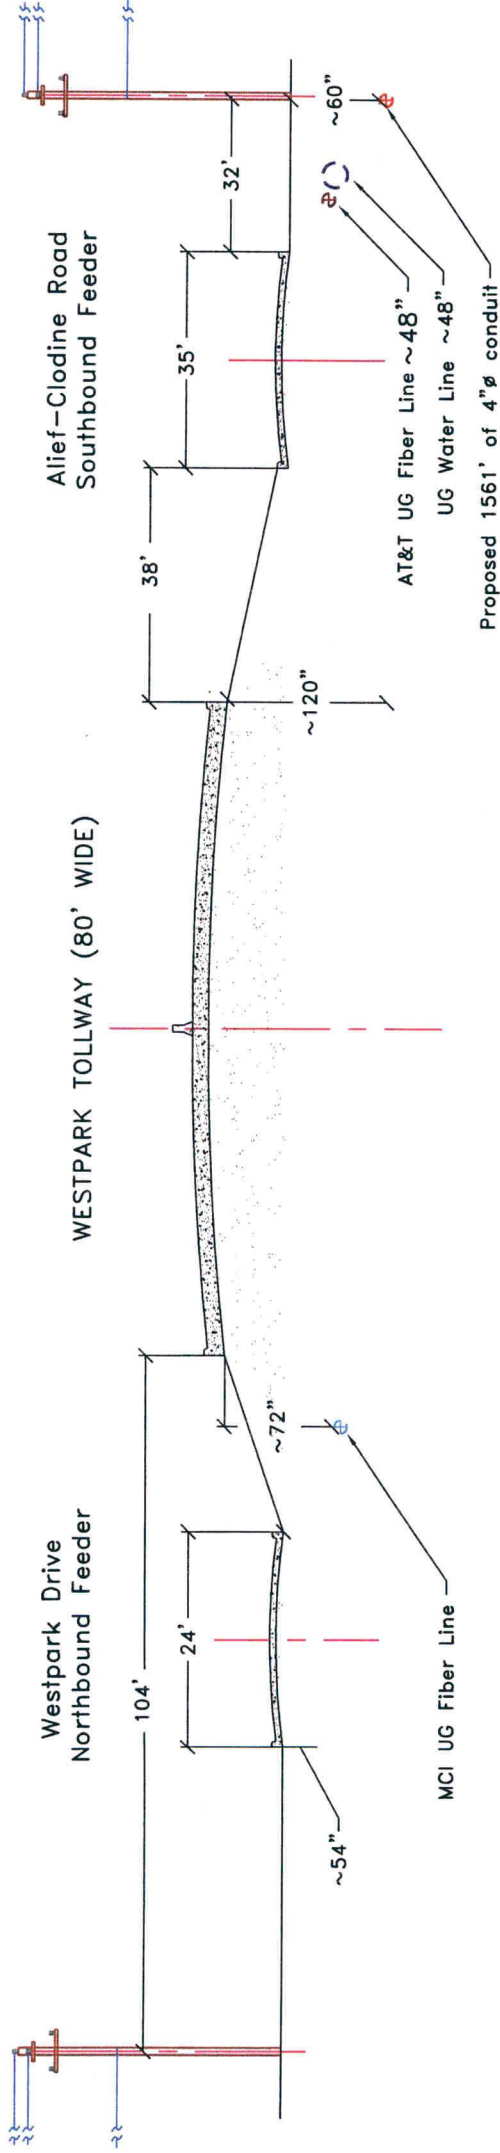

Approved By:

Symbol	Description	Symbol	Description
—	Phonoscope 4" PVC Conduit		
—	MCI UG Fiber Wireline		
—	AT&T UG Fiber Wireline		
—	UG Water Utility Line		

Drawn By: Harrell Taylor	Scale: N.T.S.	Date: 09/14/2010	FIBERTOWER— HOU2901
			Notice of Proposed Utility Installation
PHONOSCOPE			Proposed Underground Wireline Construction
Key Map # 527 E			Existing Phonoscope Fiber Optic Line
			2 of 4
			W. O.# 43370 & 43371

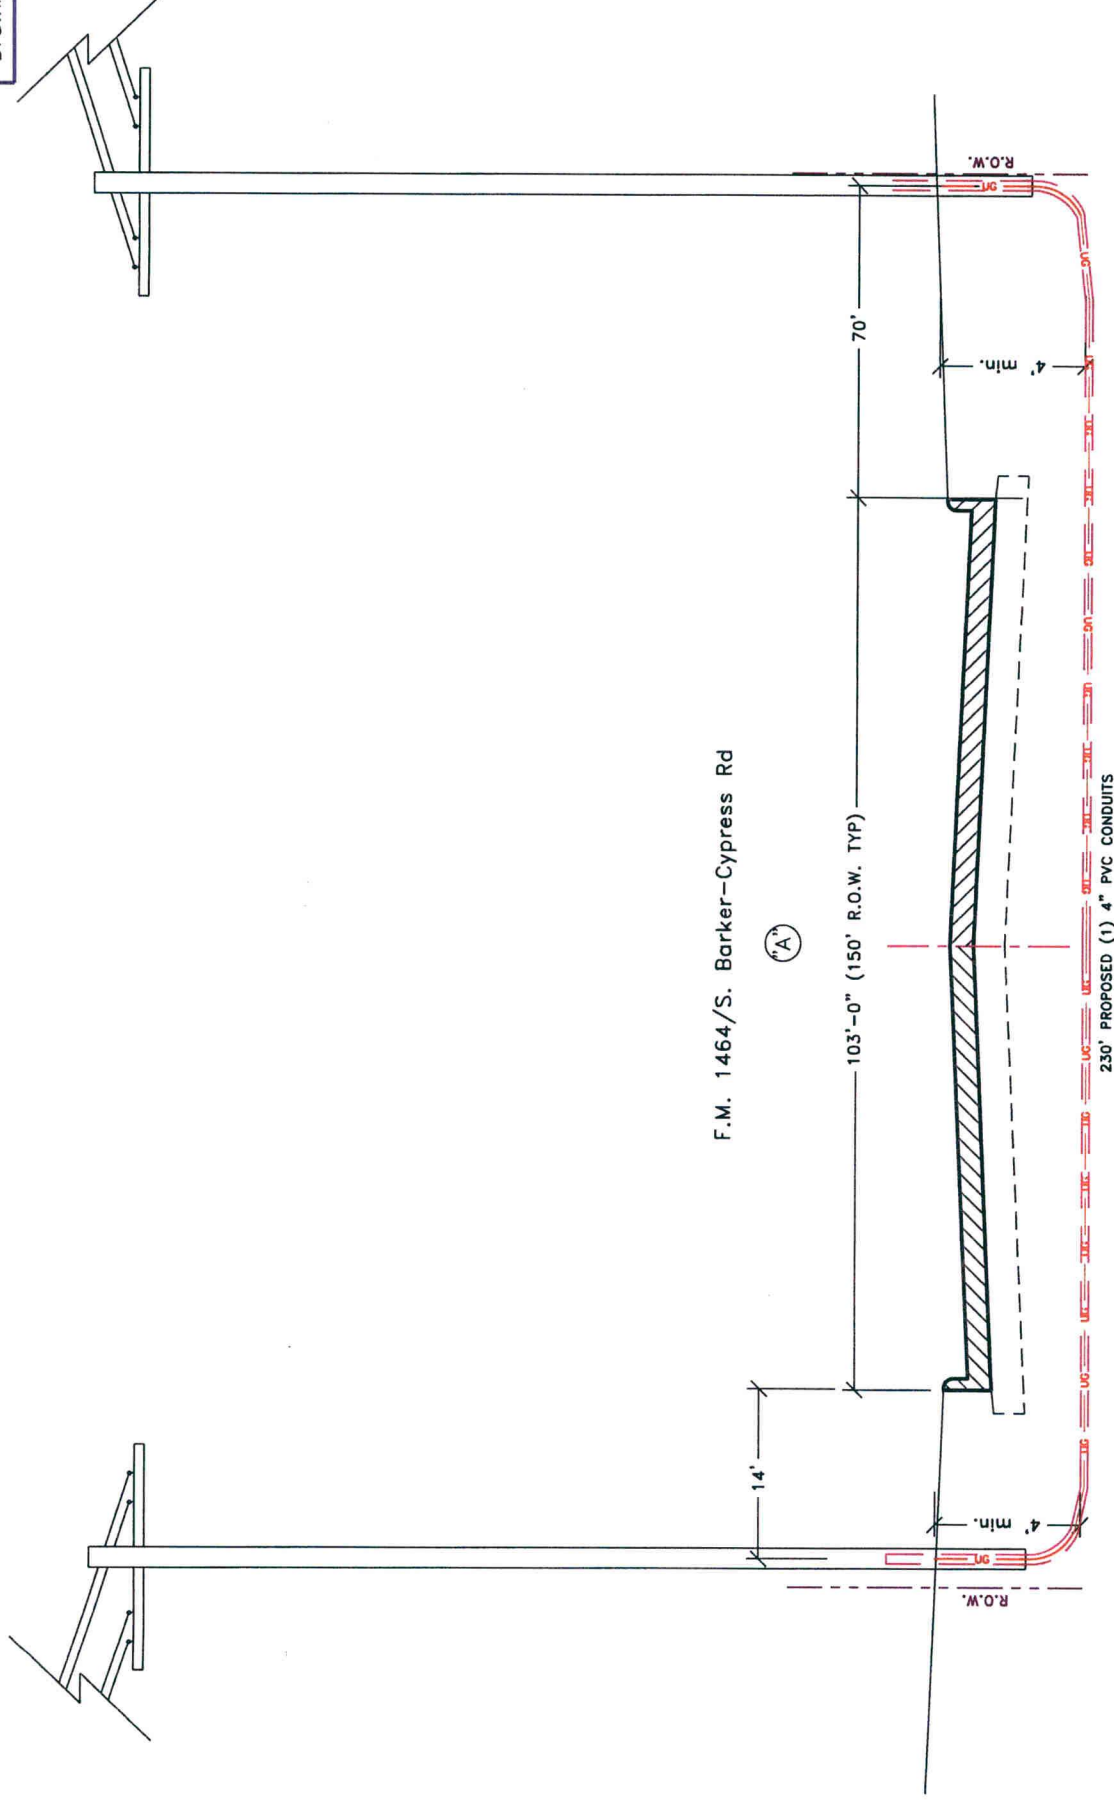

Approved By:

[illegible]

Drawn By: Harrell Taylor	Scale: N.T.S.	Date: 09/14/2010
-----------------------------	------------------	---------------------



PHONOSCOPE

Key Map # 527 E

FIBERTOWER- HOU0126

Notice of Proposed Utility Installation

Proposed Underground Crossing

Profile View-UG Xing of F.M. 1464

3 of 4


W. O.# 43370 & 43371

General Notes:

- 1) Contractor may block shoulder (if applicable) but may not obstruct traffic flow
- 2) Contractor is to remove vehicles when not present, except any equipment necessary to complete job (i.e. bore machine or backhoe).
- 3) Contractor is to fence or tape off construction area when not present.
- 4) Contractor shall restore surfaces to original conditions and is subject to city restoration criteria and inspection.



Lane Closure

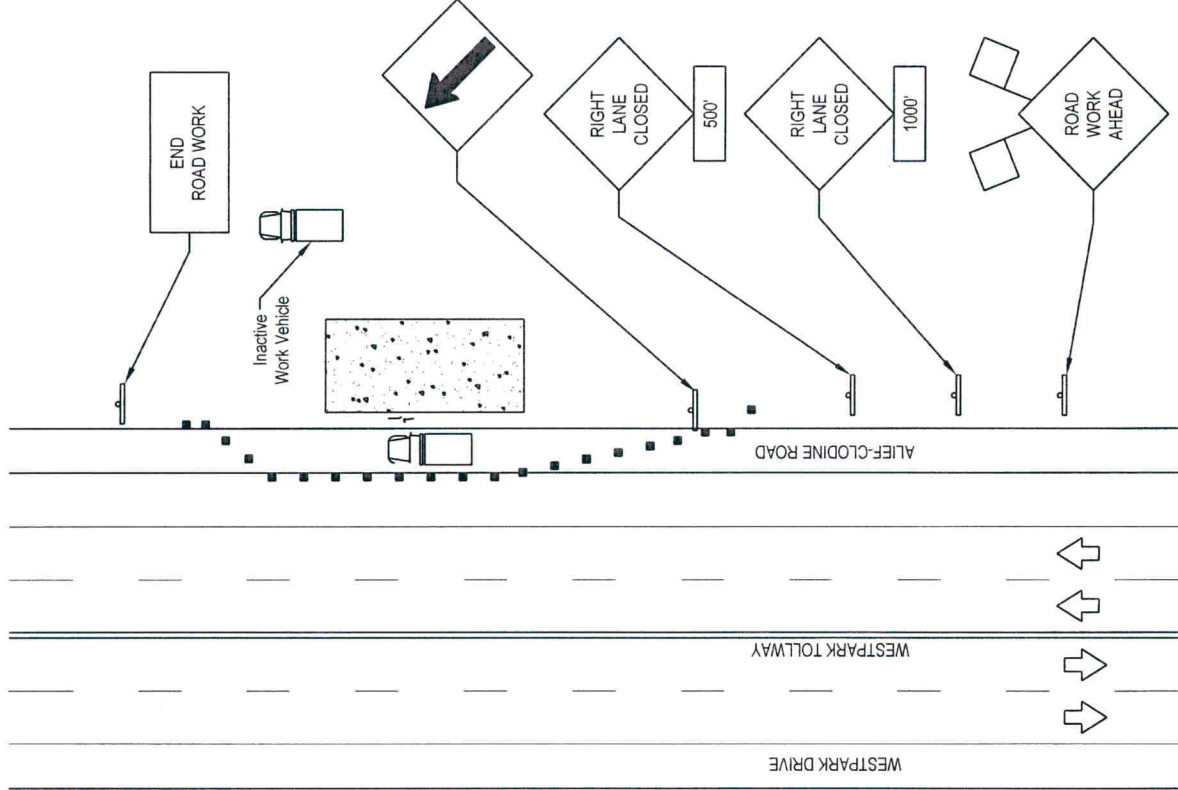

Approved By:

Symbol	Description	Revisions

Drawn By: Harrell Taylor
Scale: N.T.S.
Date: 09/15/2010



PHONOSCOPE

Key Map # 527 E

FIBERTOWER - HOU2901

Notice of Proposed Utility Installation
Proposed Underground Right-of-Way
Traffic Control Plan

4 of 4 W. O.# 43370 & 43371