

REVIEW BY FORT BEND COUNTY COMMISSIONERS COURT

On this 02 day of AUGUST, 2011, before the Fort Bend Commissioners Court came on to be heard and reviewed the accompanying notice of PHONOSCOPE, LLC

Job Location BELLA TERRA BOULEVARD

Dated 07/21/11 BOND NO. 103827669 Permit No. 83992

to make use of certain Fort Bend County property subject to, "A Revised Order Regulating the Laying, Construction, Maintenance, and Repair of Buried Cables, Conduits, and Pole Lines, In, Under, Across or Along Roads, Streets, Highways, and Drainage Ditches in Fort Bend County, Texas, Under the Jurisdiction of the Commissioners Court of Fort Bend County, Texas," as passed by the Commissioners Court of Fort Bend County, Texas, date the 3rd day of August, 1987, recorded in Volume _____ of the Minutes of the Commissioners Court of Fort Bend County, Texas, to the extent that such order is not inconsistent with Article 1436a, Vernon's Texas Civil Statues. Upon Motion of Commissioner Meyers, seconded by Commissioner Patterson, duly put and carried, it is ORDERED, ADJUGED AND DECREED that said notice of said above purpose is hereby acknowledged by the Commissioners Court of Fort Bend County, Texas, and that said notice be placed on record according to the regulation order thereof.

Notes:

- 1. Evidence of review by the Commissioners Court must be kept on the job site and failure to do so constitutes grounds for job shutdown.
- 2. Written notices are required:
 - a. 48 hours in advance of construction start up, and
 - b. When construction is completed and ready for final inspection

Mail notices to: Permit Administrator
Fort Bend County Engineering
P.O. Box 1449
Rosenberg, Texas 77471
281-633-7500

- 3. This permit expires one (1) year from date of permit if construction has not commenced.

By [Signature]
County Engineer

By N/A
Drainage District Engineer/Manager

Presented to Commissioners Court and approved.
Recorded in Volume 8-2-11
Minutes of Commissioners Court.

Clerk of Commissioners Court
By [Signature]
Deputy

COUNTY OF FORT BEND

Engineering Department

P.O. BOX 1449
Rosenberg, Texas 77471-1449

Johnny Ortega
Permit Administrator

1124 Blume Road
Phone: (281) 341-7500

PERMIT APPLICATION REVIEW FORM FOR CABLE, CONDUIT, AND POLE LINE ACTIVITY IN FORT BEND COUNTY

PERMIT NO. 083992

The following "Notice of Proposed Cable, Conduit, and/or Pole Line activity in Fort Bend County" and accompanying attachments have been reviewed and the notice conforms to appropriate regulations set by Commissioner's Court of Fort Bend County, Texas.

- (1) Complete Application Form.
- a. Name of road, street, and/or drainage ditch affected.
 - b. Vicinity map showing course of direction.
 - c. Plans and specifications.

- (2) Bond:
- District Attorney, approval when applicable.
 - Perpetual bond currently posted.
No. 103827669
Amount \$50,000.00
 - Performance bond submitted.
No. _____
Amount _____
 - Cashier's Check.
No. _____
Amount _____

- (3) Verbal permission given for emergencies, to start construction before approved in Commissioner's Court.

Precinct Engineer Acknowledgment Date _____

Precinct Commissioner Acknowledgment Date _____

- (4) _____
Drainage District Approval when applicable

We have reviewed this project and agree it meets minimum requirements.



Johnny Ortega CFM/ Permit Administrator
(REVISED 5/30/08)

07/21/2011

Date

NOTICE OF PROPOSED CABLE, CONDUIT AND/OR POLE LINE ACTIVITY
IN, UNDER, ACROSS OR ALONG ROADS, STREETS, HIGHWAYS AND DRAINAGE DITCHES
IN FORT BEND COUNTY

APPLICANT'S JOB NO. _____
 PERMIT No. 83992 PCT. No. 3
 BOND No. 103827662

Formal notice is hereby given that PHONOSCOPE LLC
 proposes to lay, construct, maintain and/or repair cable, conduit and/or pole line, in, under, across, or
 along roads, streets, highways and drainage ditches in Fort Bend County, as follows:

In, Under, or Across Roads and/or Drainage Ditches

| Road or Ditch Name | Distance & Direction From Nearest Intersection | Length of Crossing | Type of Construction | | | |
|-----------------------|---|-----------------------|----------------------|---------|---------|------|
| | | | Bored: | Jacked: | Driven: | Case |
| | | | | | | |
| | | | | | | |
| | | | | | | |

Along Roads and/or Drainage Ditches

| Road or Ditch Name | Distance & Direction From Nearest Intersection | To | Distance |
|-----------------------|---|---------------------------|----------|
| BELLA TERA | 34' EAST OF CANAL RD | 61' WEST OF GRAND PKWY | 800 |
| | | | |
| | | | |

General Description

PROPOSE TO BORE AND INSTALL CONDUIT, FIBER OPTIC
 CABLE, AND (3) VAULTS IN ROW ALONG BELLA TERA

The Location and description of the proposed installation and appurtenances is more fully shown on the
 attached detail drawings. The laying, construction, maintenance and/or repair of the proposed installation
 shall be subject to "A Revised Order Regulating the Laying, Construction, Maintenance and/or Repair of
 Cables, Conduits, and/or Pole Lines, In, Under, Across, or Along Roads, Streets, Highways and Drainage
 Ditches in Fort Bend County, Texas, Under the Jurisdiction of the Commissioners Court of Fort Bend
 County, Texas," as passed by Commissioners Court of Fort Bend County, Texas, dated the 3rd. day of
 August, 1987, recorded in Volume 639 of the Minutes of the Commissioners Court of Fort Bend County,
 Texas.

Written notices are required: 1) 48 hours in advance of start of construction and 2) when construction is
 complete and ready for final inspection.

Mail to: Permit Administrator/Fort Bend County Engineering
 P.O. Box 1449, Rosenberg, TX 77471.

Violation of requirements shall constitute grounds for job shut down.

COMPANY NAME: PHONOSCOPE LLC

AGENT and/or OWNER

(Signature)

NAME & TITLE: HARRELL TAYLOR/AUTOCAD DRAFTER

(Please Print)

DATE: 7/18/2011

ADDRESS: 6105 WESTLINE DR.

(Street/P.O. Box)

HOUSTON

City

TEX


State

77036

Zip

TELEPHONE NO: (713) 272-4600


(accessible 24 hrs/day, 7 days/week)

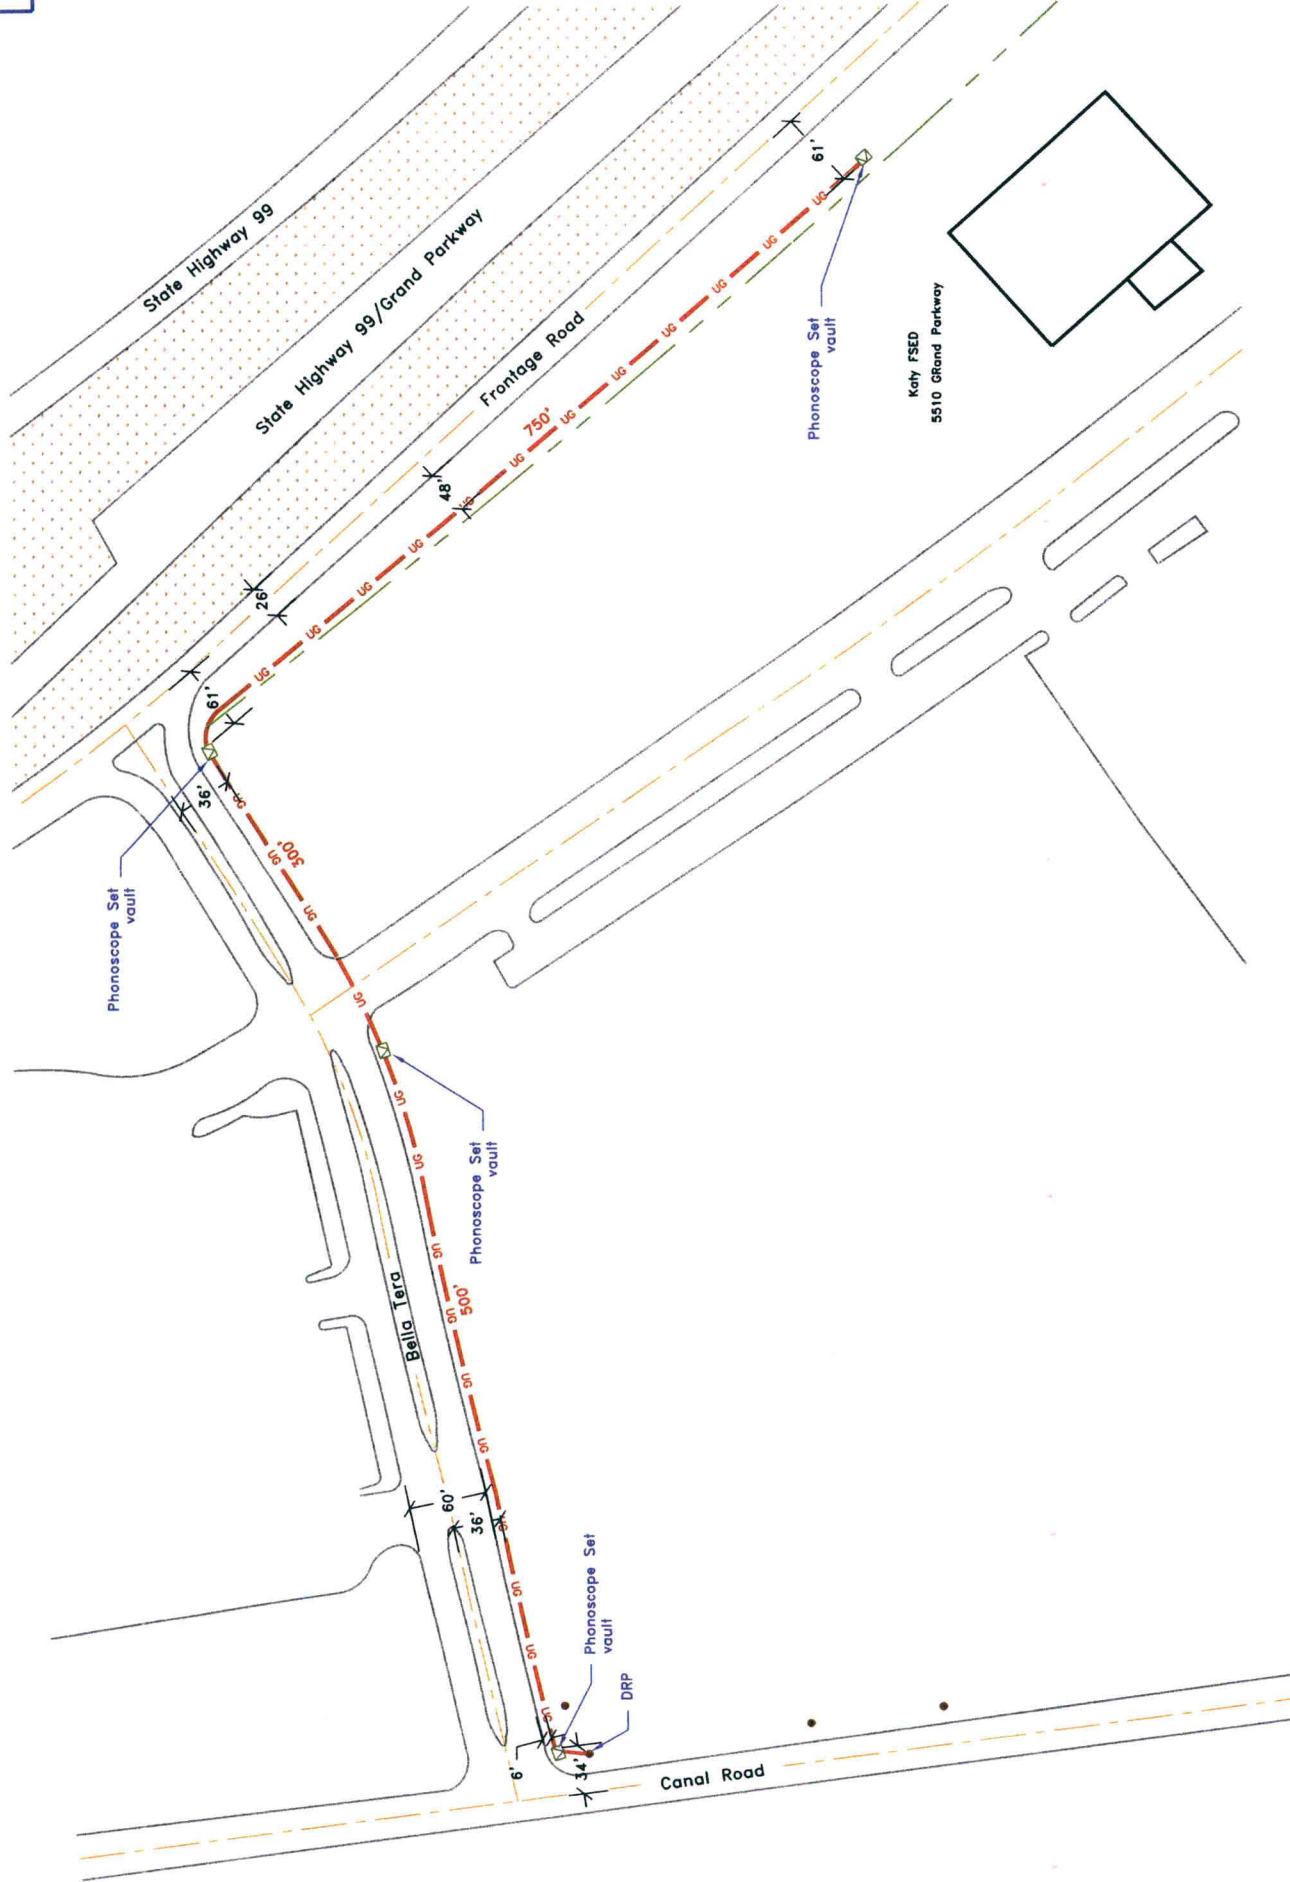

Approved By:

| Symbol | Description |
|--------|---|
| | (3) 1" PVC conduit encasing fiber optic cable underground @ a min depth of 48" below existing grade |
| | Proposed Phonoscope Set vaults |
| | Existing Utility poles |
| | |
| | |
| | |

| Revisions |
|-----------|
| |
| |
| |
| |
| |


 Key Map: 525 K
 Confidential and Proprietary

Drawn By: Harrell Taylor
 Scale: N.T.S.
 Date: 07/14/2011




KATY FSED

Notice of Proposed Utility Installation
 Proposed Underground Wireline Construction
 Site Plan - UG ROW of Bella Tera
 1 of 3
 W. O. # 48793


General Notes:

- 1) Surface to be restored to its original condition in compliance with Ft. Bend County Standards.
- 2) Traffic Control Plan (1-1c) standards to be used as noted on page 3.

**SECTIONAL DETAIL "A"
GRAND PARKWAY-FRONTAGE ROAD
(WEST VIEW)**

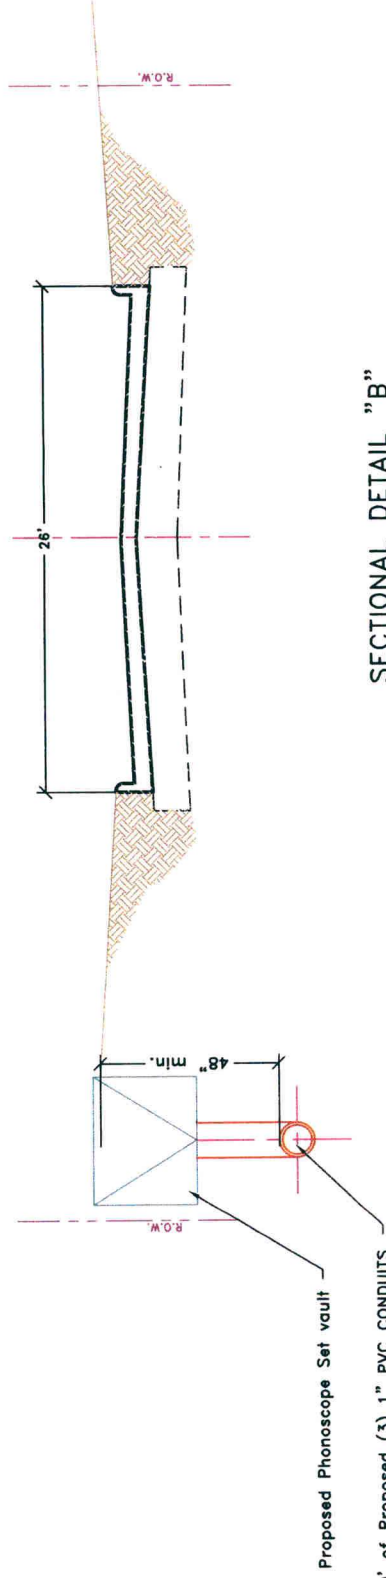

**SECTIONAL DETAIL "B"
BELLA TERA
(NORTH VIEW)**

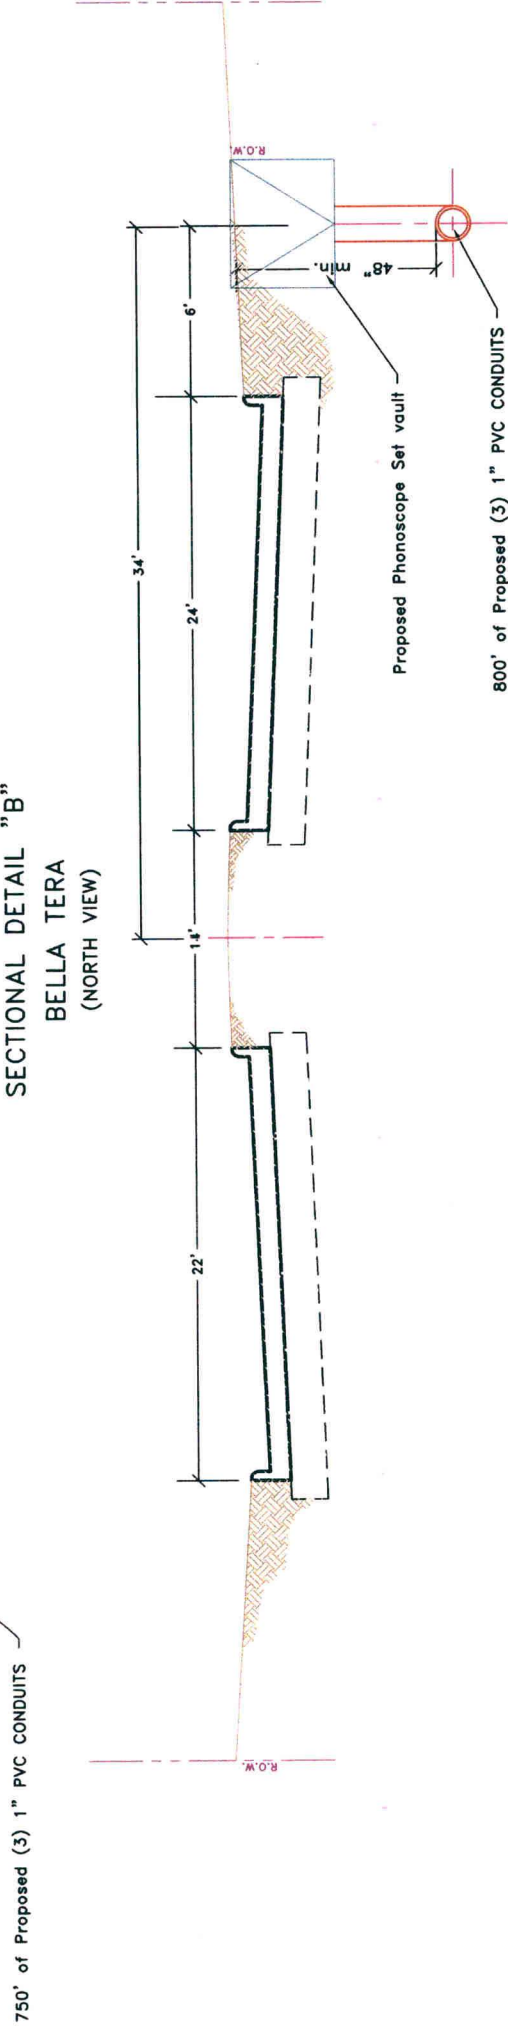

Approved By:

| Symbol | Description | Revisions |
|--------|---|-----------|
| — us — | (3) 1" PVC conduits encasing fiber optic cable underground at a min. depth of 48" below existing grade. | |
| ☑ | Proposed Set vaults | |
| | | |
| | | |
| | | |
| | | |
| | | |
| | | |

Drawn By: Harrell Taylor
 Scale: N.T.S.
 Date: 07/14/2011


 PHONOSCOPE
 Key Map: 525 K


KATY FSED

Notice of Proposed Utility Installation
 Proposed Underground Wireline Construction
 Street Cross Section/ Profile
 2 of 3
 W.O.# 48793

General Notes:

- 1) Contractor will need to use parking lane or side of street for equipment, but shall not obstruct flow of traffic or close street without proper notice submitted to the Fort Bend County Engineers for review and approval.

No Traffic Obstruction

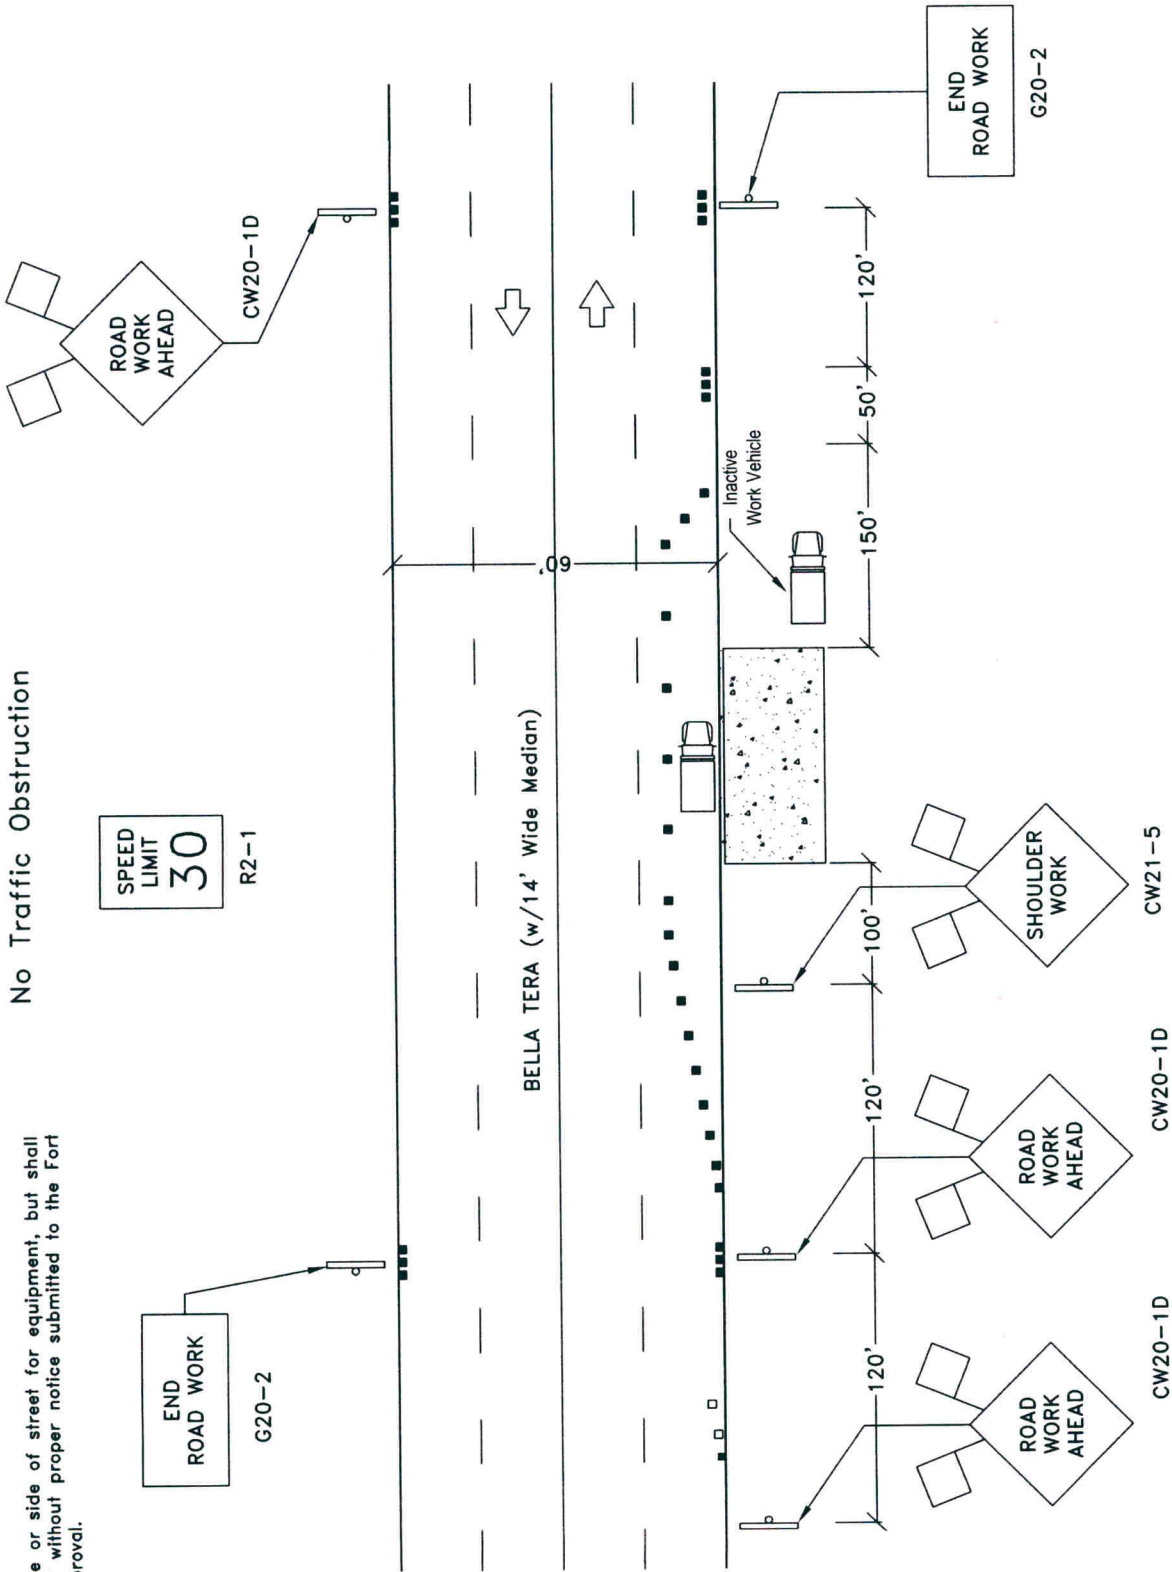

Approved By:

| Symbol | Description | Revisions |
|--------|-------------|----------------------------------|
| | | Revised by: H. Taylor 10/10/2008 |
| | | |
| | | |
| | | |
| | | |

Drawn By: Harrell Taylor
 Scale: N.T.S.
 Date: 07/18/2011

PHONOSCOPE
 Key Map: 525 K