

13 m

REVIEW BY FORT BEND COUNTY COMMISSIONERS COURT

On this 28 day of FEBRUARY, 2012, before the Fort Bend Commissioners Court came on to be heard and reviewed the accompanying notice of PHONOSCOPE, LLC

Job Location OLD RICHMOND ROAD

Dated 02/08/12 BOND NO. 103827669 Permit No. 84101

to make use of certain Fort Bend County property subject to, "A Revised Order Regulating the Laying, Construction, Maintenance, and Repair of Buried Cables, Conduits, and Pole Lines, In, Under, Across or Along Roads, Streets, Highways, and Drainage Ditches in Fort Bend County, Texas, Under the Jurisdiction of the Commissioners Court of Fort Bend County, Texas," as passed by the Commissioners Court of Fort Bend County, Texas, date the 3rd day of August, 1987, recorded in Volume _____ of the Minutes of the Commissioners Court of Fort Bend County, Texas, to the extent that such order is not inconsistent with Article 1436a, Vernon's Texas Civil Statutes. Upon Motion of Commissioner Meyers, seconded by Commissioner Prestrage, duly put and carried, it is ORDERED, ADJUGED AND DECREED that said notice of said above purpose is hereby acknowledged by the Commissioners Court of Fort Bend County, Texas, and that said notice be placed on record according to the regulation order thereof.

Notes:

1. Evidence of review by the Commissioners Court must be kept on the job site and failure to do so constitutes grounds for job shutdown.
2. Written notices are required:
 - a. 48 hours in advance of construction start up, and
 - b. When construction is completed and ready for final inspection

Mail notices to: Permit Administrator
Fort Bend County Engineering
P.O. Box 1449
Rosenberg, Texas 77471
281-633-7500

3. This permit expires one (1) year from date of permit if construction has not commenced.

By [Signature]
County Engineer

By _____
Drainage District Engineer/Manager

Presented to Commissioners Court and approved.
Recorded in Volume 2-28-12
Minutes of Commissioners Court.

Clerk of Commissioners Court
By [Signature]
Deputy

**NOTICE OF PROPOSED CABLE, CONDUIT AND/OR POLE LINE ACTIVITY
IN, UNDER, ACROSS OR ALONG ROADS, STREETS, HIGHWAYS AND DRAINAGE DITCHES
IN FORT BEND COUNTY**

APPLICANT'S JOB NO. 1211-915
 PERMIT No. 84161 PCT. No. 3
 BOND No. 103827669

Formal notice is hereby given that PHONOSCOPE LLC
 proposes to lay, construct, maintain and/or repair cable, conduit and/or pole line, in, under,
 across, or along roads, streets, highways and drainage ditches in Fort Bend County, as follows:

In, Under, or Across Roads and/or Drainage Ditches

Road or Ditch Name	Distance & Direction From Nearest Intersection	Length of Crossing	Type of Construction
			Bored: Jacked: Driven: Cased
OLD RICHMOND RD	404 FT SOUTH OF BOSS GASTON RD	60 FT	✓ : : :

Along Roads and/or Drainage Ditches

Road or Ditch Name	Distance & Direction From Nearest Intersection	To	Distance
OLD RICHMOND RD	404 FT SOUTH OF BOSS GASTON RD		389 FT

General Description

PROPOSE TO TRENCH 389 FT IN (WEST) ROW OF OLD RICHMOND BORE 60 FT CROSSING OLD RICHMOND RD TO INSTALL CONDUIT & FIBEROPTIC CABLE


The Location and description of the proposed installation and appurtenances is more fully shown on the attached detail drawings. The laying, construction, maintenance and/or repair of the proposed installation shall be subject to "A Revised Order Regulating the Laying, Construction, Maintenance and/or Repair of Cables, Conduits, and/or Pole Lines, In, Under, Across, or Along Roads, Streets, Highways and Drainage Ditches in Fort Bend County, Texas, Under the Jurisdiction of the Commissioners Court of Fort Bend County, Texas," as passed by Commissioners Court of Fort Bend County, Texas, dated the 3rd. day of August, 1987, recorded in Volume 639 of the Minutes of the Commissioners Court of Fort Bend County, Texas.


Written notices are required: 1) 48 hours in advance of start of construction and
 2) when construction is complete and ready for final inspection.

Mail to: Permit Administrator/Fort Bend County Engineering
 P.O. Box 1449, Rosenberg, TX 77471.

Violation of requirements shall constitute grounds for job shut down.

Does project comply with Fort Bend County Outdoor Lighting Ordinance? Yes () No ()
--

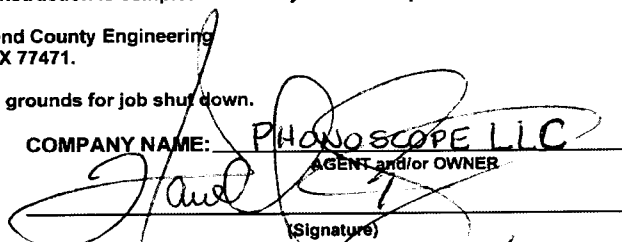COMPANY NAME: PHONOSCOPE LLC
 AGENT and/or OWNER

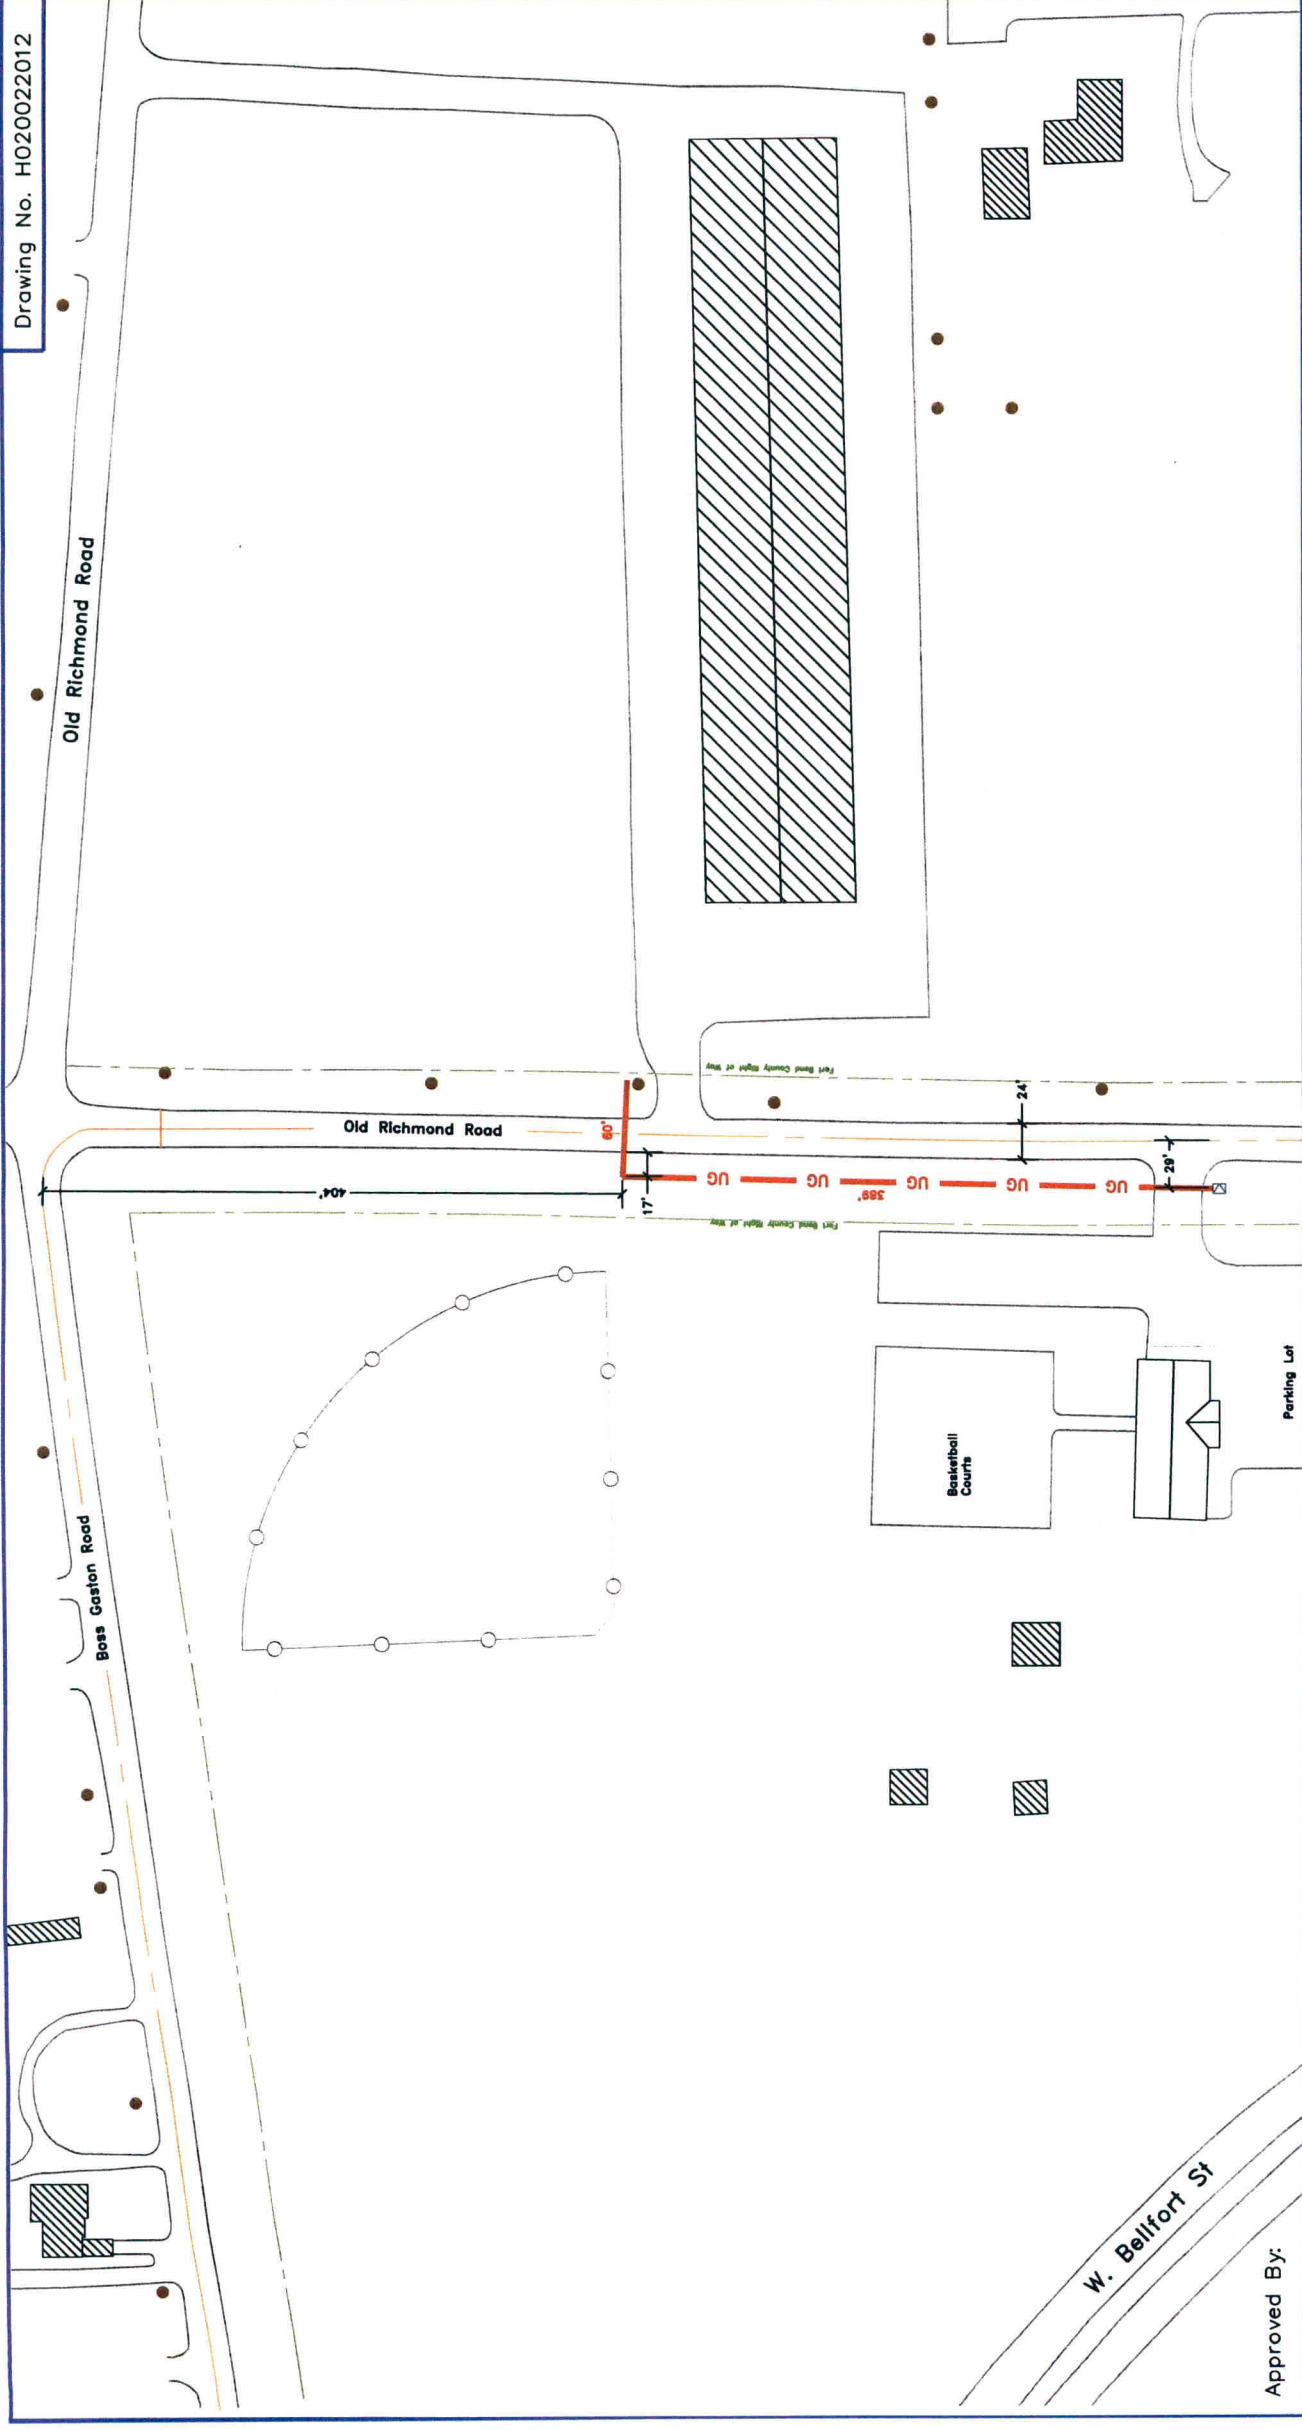 (Signature)
 NAME & TITLE HARRELL TAYLOR/AUTOCAD DRAFTER
 (Please Print)
 DATE 2/2/2012
 ADDRESS 6105 WESTLINE DR
 (Street/P.O. Box)
HOUSTON TEX 77036
 City State Zip
 TELEPHONE NO: (713) 272-4600
 (accessible 24 hrs/day, 7 days/week)



Approved By:

Symbol	Description
●	Existing Utility Poles
UG	(3) 1" PVC conduit encasing fiber optic cable underground @ a min. depth of 48" below existing grade
☒	Phonscope Set vault

Revisions

No.	Description

Drawn By: Harrell Taylor

Scale: N.T.S.

Date: 02/02/2012

JOB# 1211-915



PHONOSCOPE



Key Map: 527 V


Notice of Proposed Utility Installation
 Proposed Underground Wireline Construction
 Site Plan-UG Xing & ROW of Old Richmond Rd
 1 of 3
 W. O.# 51798

Confidential and Proprietary


General Notes:

- 1) Surface to be restored to its original condition in compliance with Fort Bend County Standards.
- 2) Traffic Control Plan (1-1c) standards to be used as noted on page 3.

SECTIONAL VIEW 'A'
OLD RICHMOND ROAD
W. O. 51798

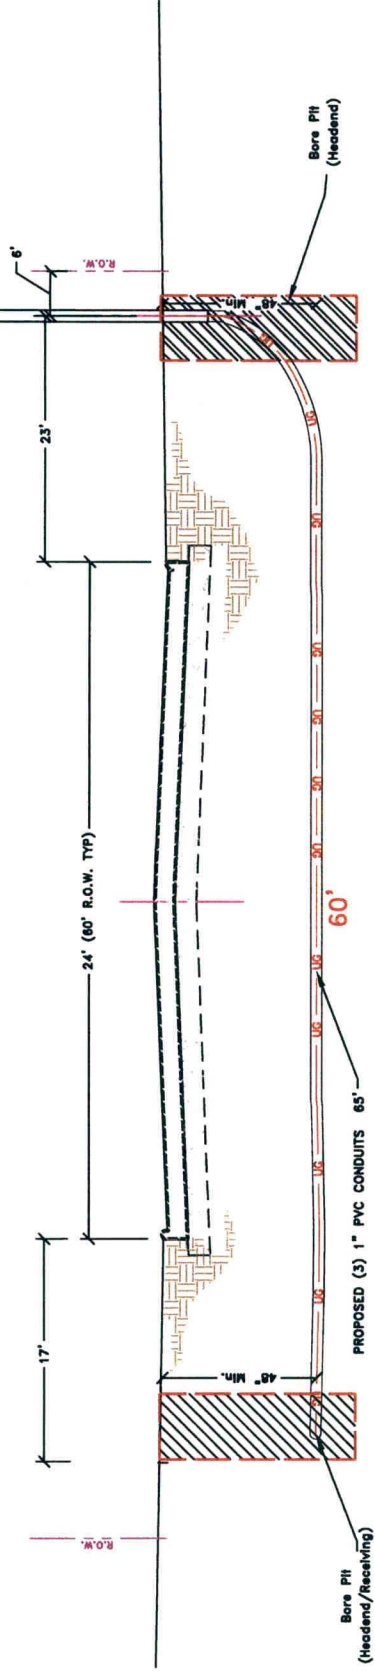

SECTIONAL VIEW 'B'
OLD RICHMOND ROAD
W. O. 51798

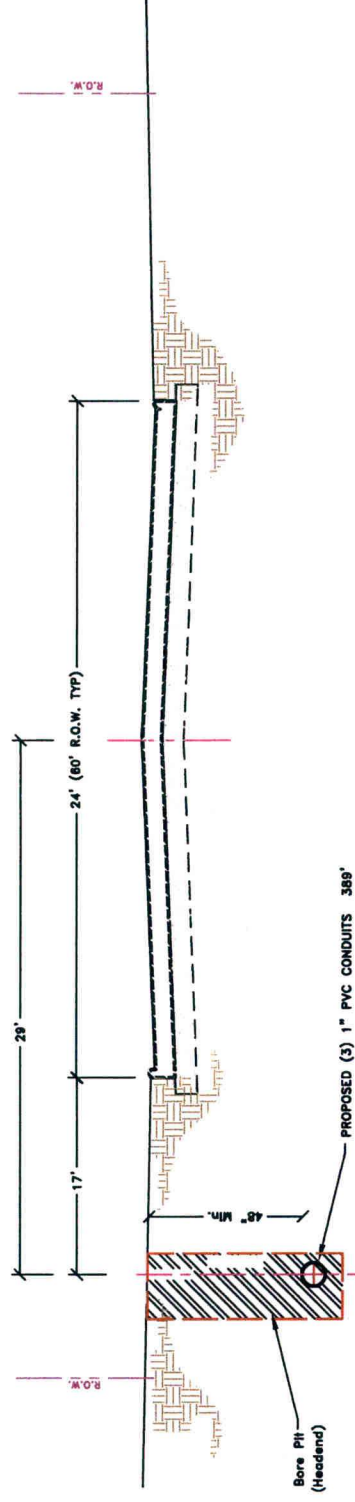

Approved By:

Symbol	Description	Revisions
UG ---	(3) 1" PVC conduits encasing fiber optic cable @ a depth of 48" below existing grade	

Drawn By:
Harrell Taylor

Scale:
N.T.S.

Date:
02/02/2012

JOB# 1211-915 PLP



PHONOSCOPE

Notice of Proposed Utility Installation
Proposed Underground Wireline Installation
Cross Section/ Profile

2 of 3

Key Map: 570N

Confidential and Proprietary

W. O. # 51798

