

REVIEW BY FORT BEND COUNTY COMMISSIONERS COURT

On this 28 day of FEBRUARY, 2012, before the Fort Bend Commissioners Court came on to be heard and reviewed the accompanying notice of PHONOSCOPE GROUP, LLC

Job Location BEECHNUT STREET

Dated 02/16/12 BOND NO. 103827669 Permit No. 84108

to make use of certain Fort Bend County property subject to, "A Revised Order Regulating the Laying, Construction, Maintenance, and Repair of Buried Cables, Conduits, and Pole Lines, In, Under, Across or Along Roads, Streets, Highways, and Drainage Ditches in Fort Bend County, Texas, Under the Jurisdiction of the Commissioners Court of Fort Bend County, Texas," as passed by the Commissioners Court of Fort Bend County, Texas, date the 3rd day of August, 1987, recorded in Volume _____ of the Minutes of the Commissioners Court of Fort Bend County, Texas, to the extent that such order is not inconsistent with Article 1436a, Vernon's Texas Civil Statues. Upon Motion of Commissioner Meyers, seconded by Commissioner Prestage, duly put and carried, it is ORDERED, ADJUGED AND DECREED that said notice of said above purpose is hereby acknowledged by the Commissioners Court of Fort Bend County, Texas, and that said notice be placed on record according to the regulation order thereof.

Notes:

1. Evidence of review by the Commissioners Court must be kept on the job site and failure to do so constitutes grounds for job shutdown.
2. Written notices are required:
 - a. 48 hours in advance of construction start up, and
 - b. When construction is completed and ready for final inspection

Mail notices to: Permit Administrator
Fort Bend County Engineering
P.O. Box 1449
Rosenberg, Texas 77471
281-633-7500

3. This permit expires one (1) year from date of permit if construction has not commenced.

By [Signature]
County Engineer

By N/A
Drainage District Engineer/Manager

Presented to Commissioners Court and approved.
Recorded in Volume 2-28-12
Minutes of Commissioners Court.

Clerk of Commissioners Court
By [Signature]
Deputy

COUNTY OF FORT BEND

Engineering Department

P.O. BOX 1449
Rosenberg, Texas 77471-1449

Johnny Ortega
Permit Administrator

1124 Blume Road
Phone: (281) 341-7500

PERMIT APPLICATION REVIEW FORM FOR CABLE, CONDUIT, AND POLE LINE ACTIVITY IN FORT BEND COUNTY

084108

PERMIT NO. _____

The following "Notice of Proposed Cable, Conduit, and/or Pole Line activity in Fort Bend County" and accompanying attachments have been reviewed and the notice conforms to appropriate regulations set by Commissioner's Court of Fort Bend County, Texas.

- (1) Complete Application Form.
- a. Name of road, street, and/or drainage ditch affected.
- b. Vicinity map showing course of direction.
- c. Plans and specifications.

- (2) Bond: _____
- _____ District Attorney, approval when applicable.
- Perpetual bond currently posted.
- No. 103827669
- Amount \$50,000.00
- Performance bond submitted.
- No. _____
- Amount _____
- Cashier's Check.
- No. _____
- Amount _____

- (3) Verbal permission given for emergencies, to start construction before approved in Commissioner's Court.

_____ Precinct Engineer Acknowledgment _____ Date _____

_____ Precinct Commissioner Acknowledgment _____ Date _____

- (4) _____
- _____ Drainage District Approval when applicable

We have reviewed this project and agree it meets minimum requirements.



Johnny Ortega CFM / Permit Administrator
(REVISED 5/30/08)

02/16/2012

Date

**NOTICE OF PROPOSED CABLE, CONDUIT AND/OR POLE LINE ACTIVITY
IN, UNDER, ACROSS OR ALONG ROADS, STREETS, HIGHWAYS AND DRAINAGE DITCHES
IN FORT BEND COUNTY**

APPLICANT'S JOB NO. 1211-912
 PERMIT No. 84108 PCT. No. 3
 BOND No. 103871669

Formal notice is hereby given that _____
 proposes to lay, construct, maintain and/or repair cable, conduit and/or pole line, in, under,
 across, or along roads, streets, highways and drainage ditches in Fort Bend County, as follows:

In, Under, or Across Roads and/or Drainage Ditches

Road or Ditch Name	Distance & Direction From Nearest Intersection	Length of Crossing	Type of Construction			
			Bored	Jacked	Driven	Cased

Along Roads and/or Drainage Ditches

Road or Ditch Name	Distance & Direction From Nearest Intersection	To	Distance
BEECHNUT ST	700 FT WESTWARD	TEAL BREEZE DR.	300 FT

General Description

PROPOSE TO BORE AND INSTALL 300' OF CONDUIT & FIBER OPT. CABLE
 IN THE SOUTH RIGHT OF WAY OF BEECHNUT ST.
 The Location and description of the proposed installation and appurtenances is more fully shown on the
 attached detail drawings. The laying, construction, maintenance and/or repair of the proposed installation
 shall be subject to "A Revised Order Regulating the Laying, Construction, Maintenance and/or Repair of
 Cables, Conduits, and/or Pole Lines, In, Under, Across, or Along Roads, Streets, Highways and Drainage
 Ditches in Fort Bend County, Texas, Under the Jurisdiction of the Commissioners Court of Fort Bend
 County, Texas," as passed by Commissioners Court of Fort Bend County, Texas, dated the 3rd. day of
 August, 1987, recorded in Volume 639 of the Minutes of the Commissioners Court of Fort Bend County,
 Texas.


Written notices are required: 1) 48 hours in advance of start of construction and
 2) when construction is complete and ready for final inspection.



Mail to: Permit Administrator/Fort Bend County Engineering
 P.O. Box 1449, Rosenberg, TX 77471.

Violation of requirements shall constitute grounds for job shut down.

Does project comply with Fort Bend County Outdoor Lighting Ordinance? Yes () No ()
--

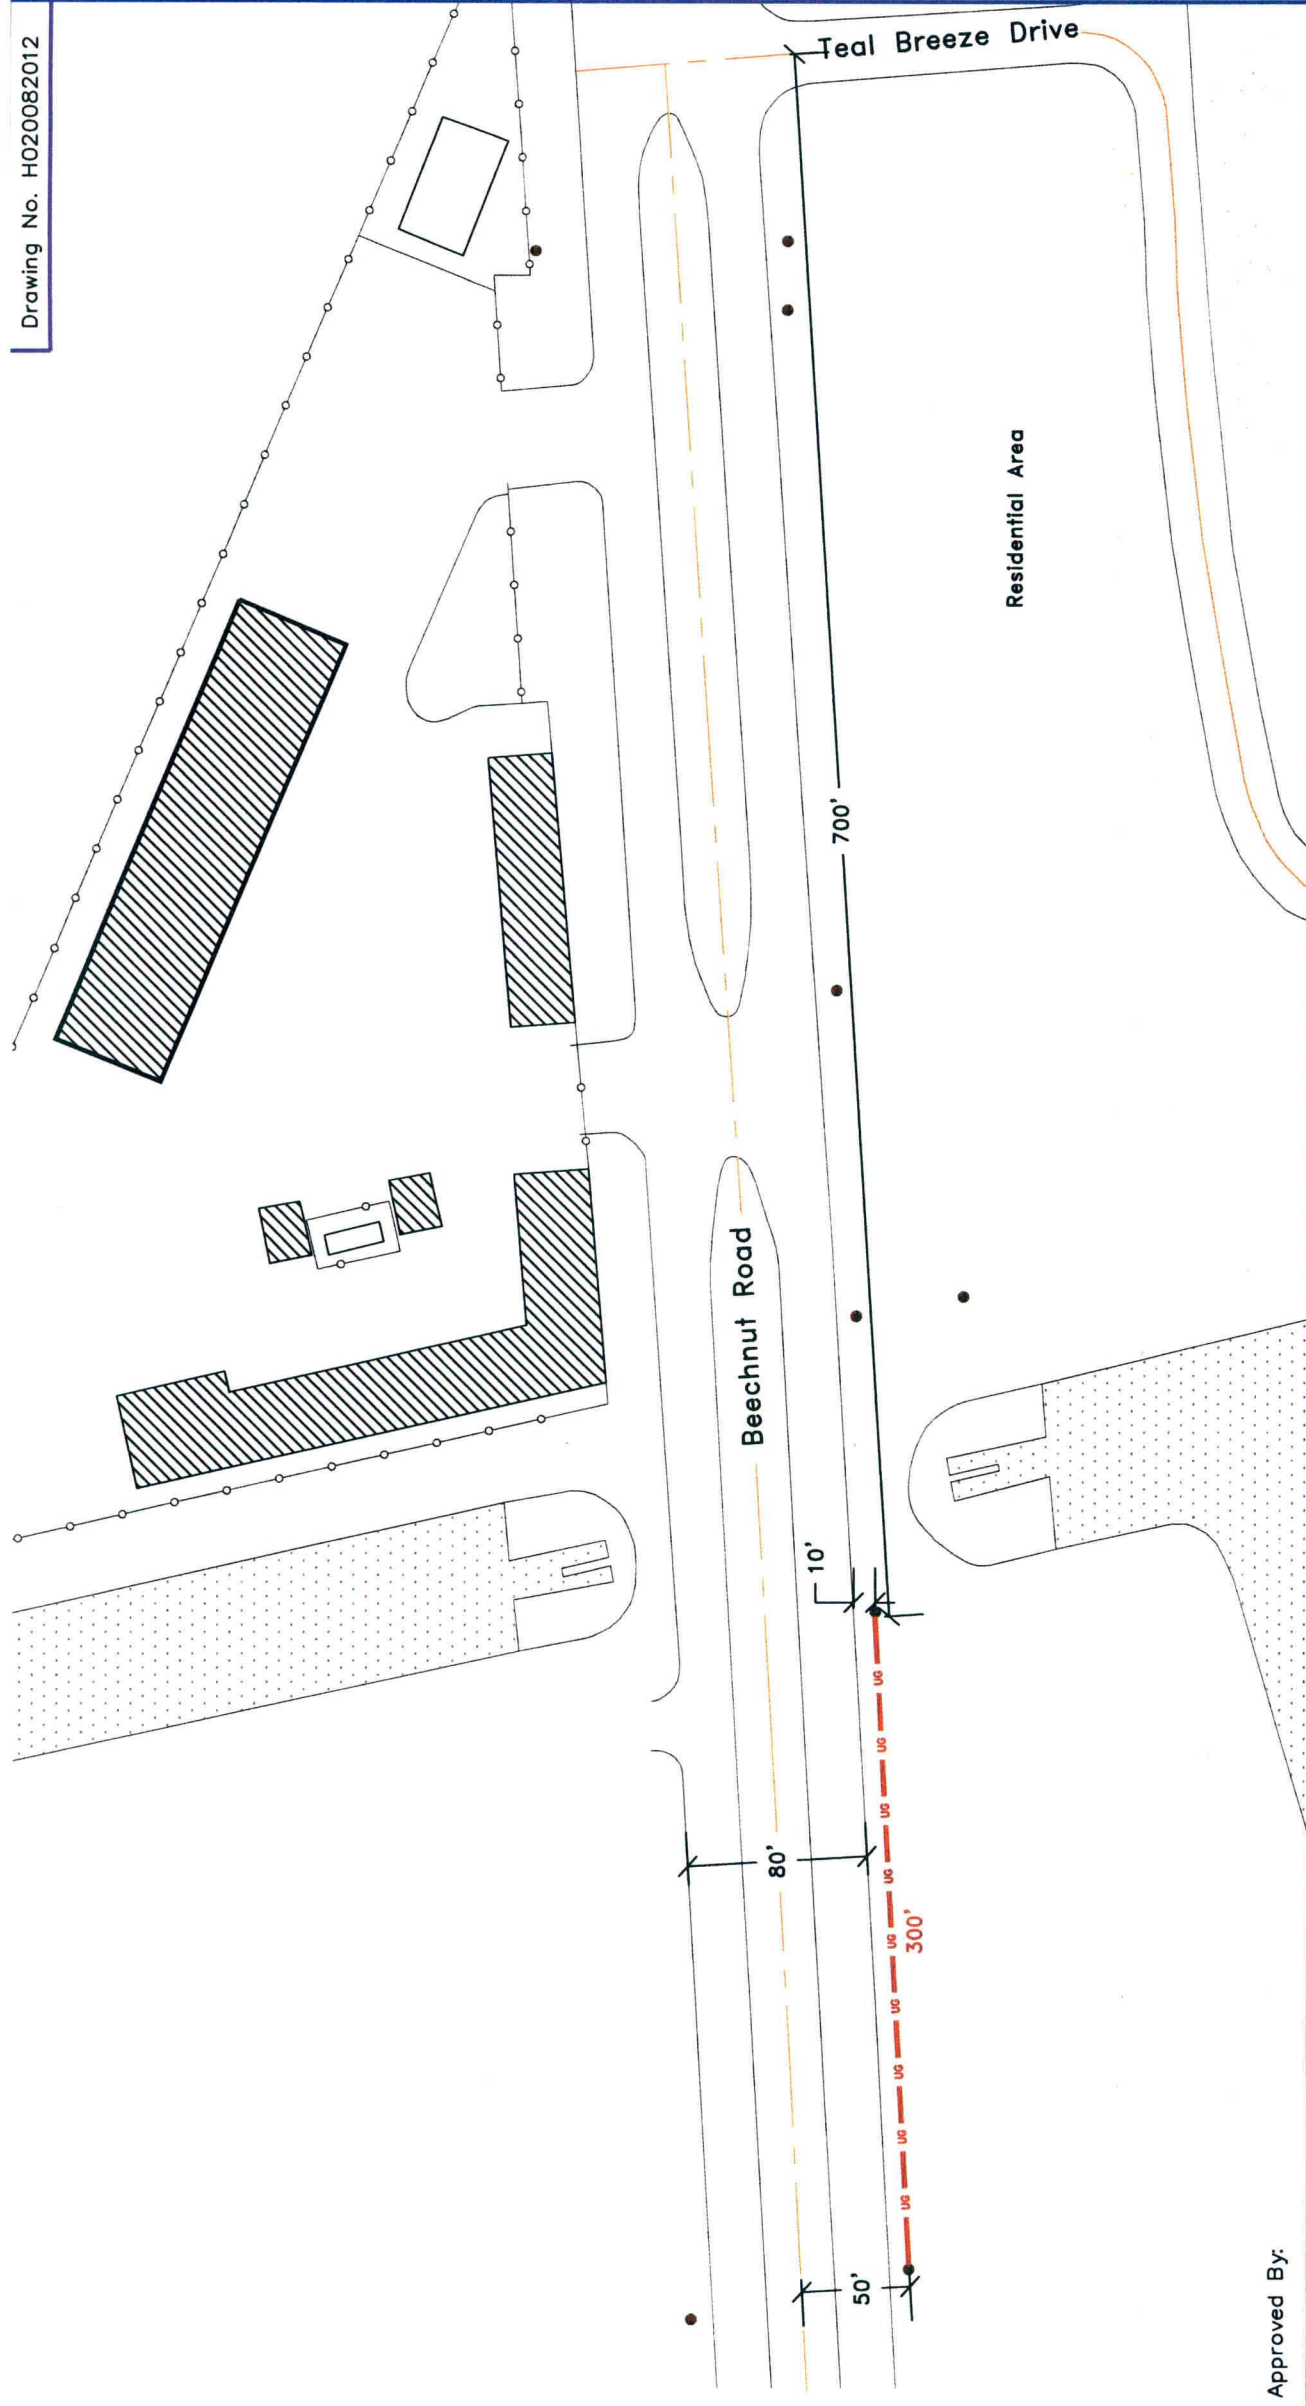COMPANY NAME: PHONOSCOPE GROUP LLC
 AGENT and/or OWNER
 (Signature)
 NAME & TITLE HARRELL TAYLOR / AUTOCAD DRAFTER
 (Please Print)
 DATE 2/8/2012
 ADDRESS 6105 WESTLINE DR
 (Street/P.O. Box)
HOUSTON TX 77036
 City State Zip
 TELEPHONE NO: (713) 272-4600
 (accessible 24 hrs/day, 7 days/week)




Approved By:		 Key Map: 526 Q	
Symbol	Description	Drawn By:	Date:
●	Existing Utility Poles	Harrell Taylor	02/08/2012
—UG—	(3) 1" PVC Conduit Encasing Fiber Optic Cable Underground	Scale:	
		N.T.S.	
		 PHONOSCOPE	
		JOB# 1211-912 PLP	
		Notice of Proposed Utility Installation	
		Proposed Underground Wireline Construction	
		Site Plan	
		1 of 3	
		W. O. # 52714	

Confidential and Proprietary

General Notes:

- 1) Surface to be restored to its original condition in compliance with Ft. Bend County Standards.
- 2) Traffic Control Plan (1-1c) standards to be used as noted on page 3.

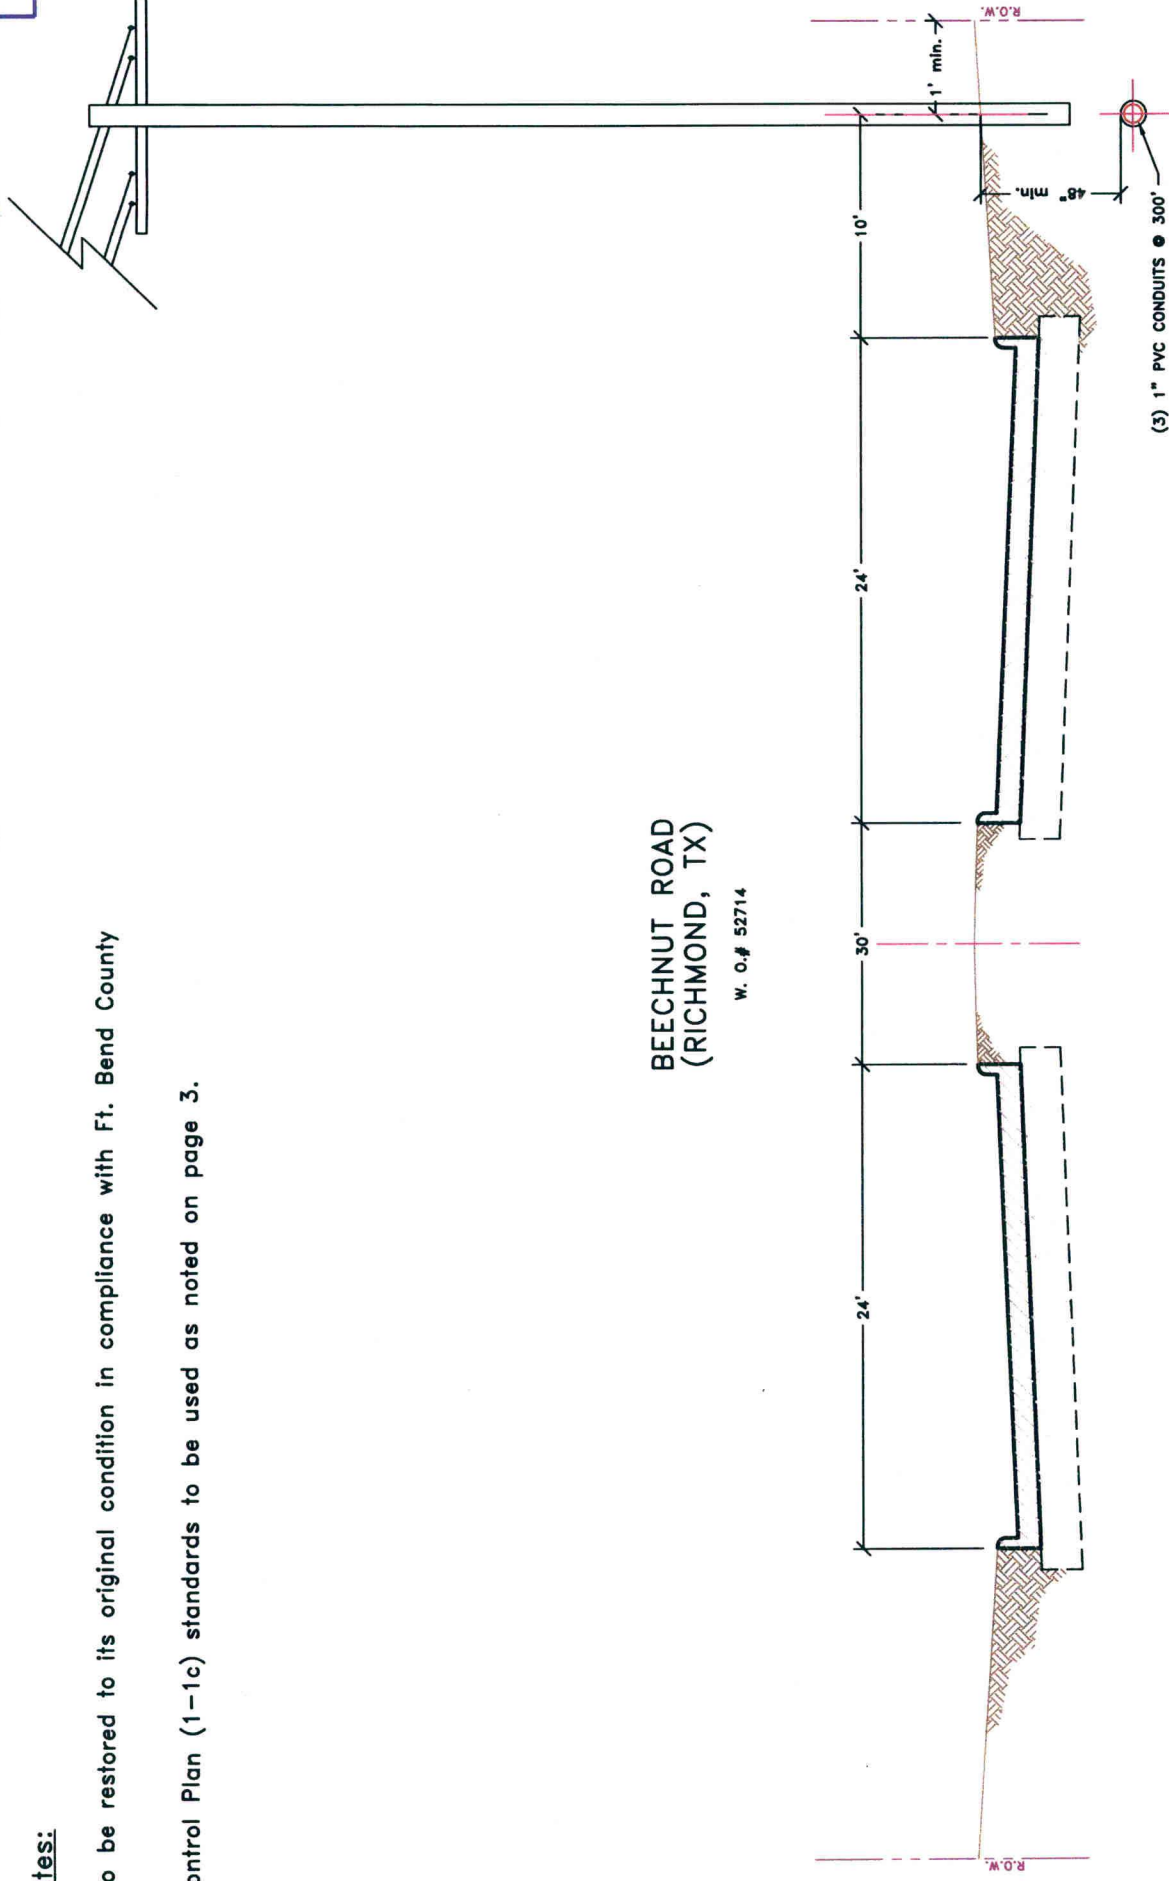

Approved By:

Symbol	Description	Revisions
uc	(3) 1" PVC conduits encasing fiber optic cable underground at a min. depth of 48" below existing grade.	

Drawn By: Harrell Taylor
 Scale: N. T. S.
 Date: 02/08/2012


 PHONOSCOPE

Key Map: 526 Q

JOB# 1211-912 PLP


Notice of Proposed Utility Installation
 Proposed Underground Wireline Crossing
 Street Cross Section/ Profile

2 of 3
 W. O.# 52714

General Notes:

1) Contractor will need to use parking lane or side of street for equipment, but shall not obstruct flow of traffic or close street without proper notice submitted to the Fort Bend County Engineers for review and approval.

No Traffic Obstruction

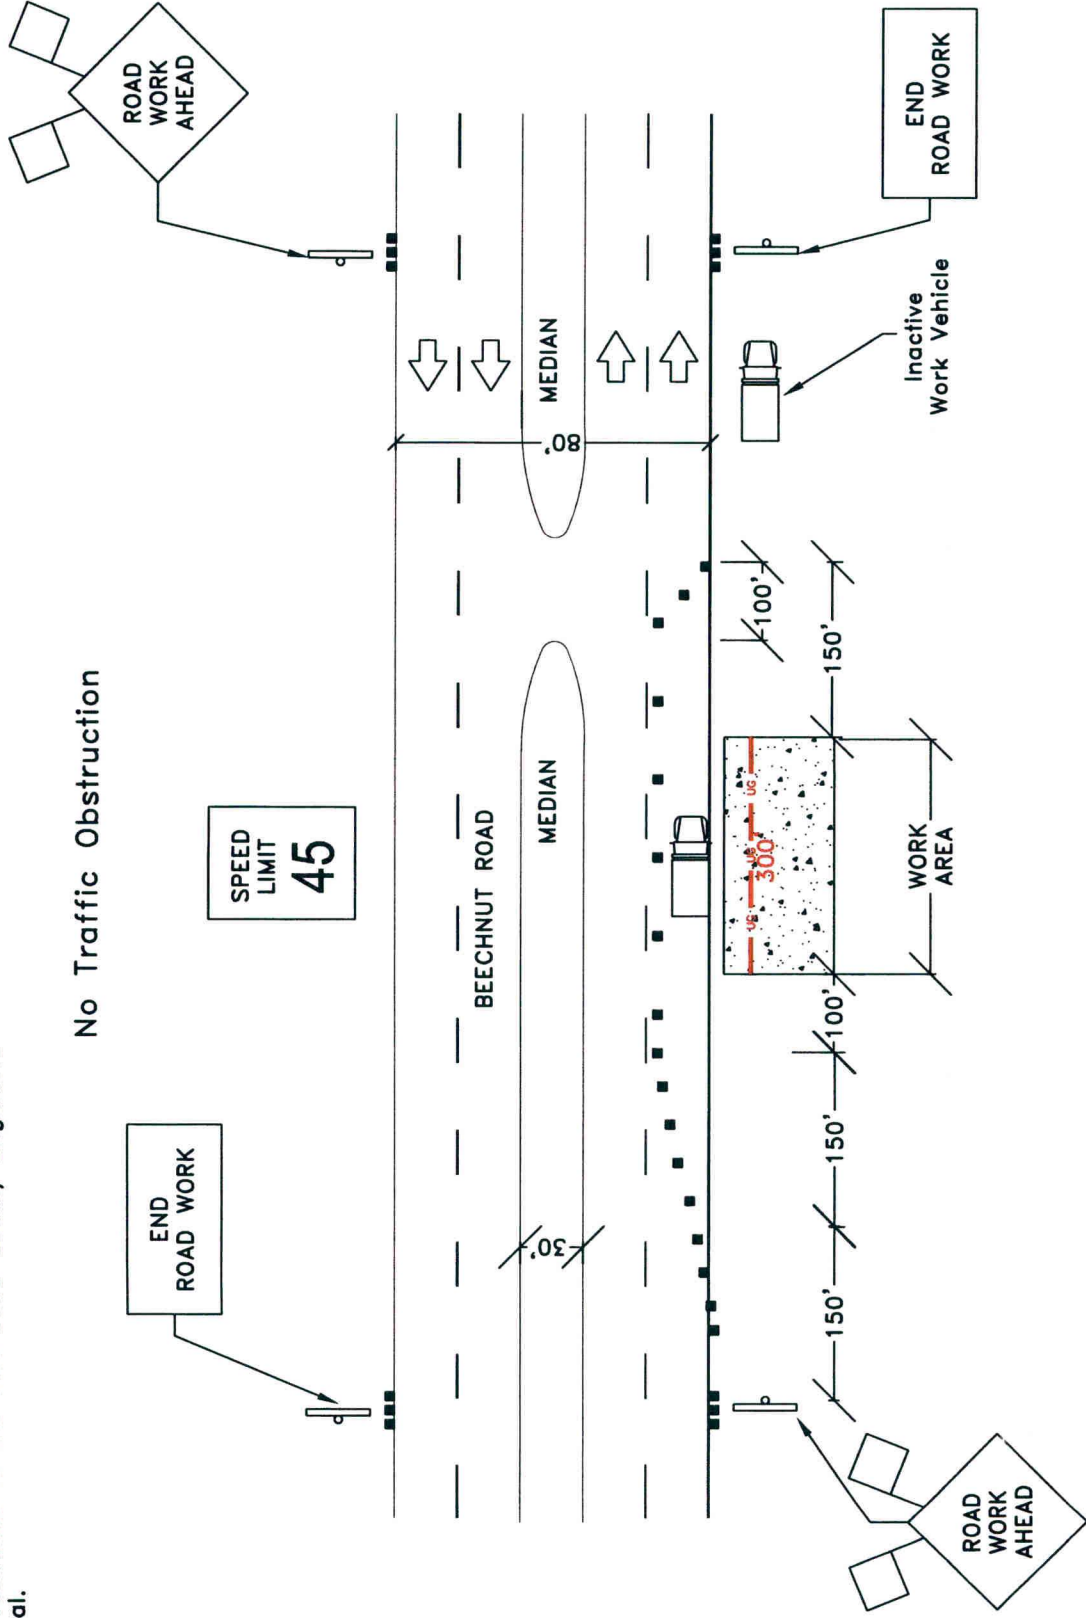

Approved By:

Symbol	Description	Revisions

Drawn By: Harrell Taylor
 Scale: N. T. S.
 Date: 02/08/2012



PHONOSCOPE

Key Map: 526 Q

Confidential and Proprietary

JOB# 1211-912 PLP

Notice of Proposed Utility Installation
 Proposed Underground Wireline Construction
 Typical Traffic Control Plan

3 of 3

W. O.# 52714