

REVIEW BY FORT BEND COUNTY COMMISSIONERS COURT

On this 26 day of NOVEMBER, 2012, Commissioners Court came on to be heard and reviewed the accompanying notice of HURTADO CONSTRUCTION COMPANY

Job Location [SEE PERMIT FOR STREET NAMES]

Dated 11/08/12 Bond No. 58S204329, Permit No. 84240 to make use of certain Fort Bend County property subject to, "A Revised Order Regulating the Laying, Construction, Maintenance, and Repair of Buried Cables, Conduits, and Pole Lines, In, Under, Across or Along Roads, Streets, Highways, and Drainage Ditches in Fort Bend County, Texas, Under the Jurisdiction of the Commissioners Court of Fort Bend County, Texas," as passed by the Commissioners Court of Fort Bend County, Texas, date the 3rd day of August, 1987, recorded in Volume _____ of the Minutes of the Commissioners Court of Fort Bend County, Texas, to the extent that such order is not inconsistent with Article 1436a, Vernon's Texas Civil Statutes. Upon Motion of Commissioner Meiners, seconded by Commissioner DeHerson, duly put and carried, it is ORDERED, ADJUGED AND DECREED that said notice of said above purpose is hereby acknowledged by the Commissioners Court of Fort Bend County, Texas, and that said notice be placed on record according to the regulation order thereof.

Notes:

1. Evidence of review by the Commissioners Court must be kept on the job site and failure to do so constitutes grounds for job shutdown.
2. Written notices are required:
 - a. 48 hours in advance of construction start up, and
 - b. When construction is completed and ready for final inspection

Mail notices to: Permit Administrator
Fort Bend County Engineering
P.O. Box 1449
Rosenberg, Texas 77471
281-633-7500

3. This permit expires one (1) year from date of permit if construction has not commenced.

By

[Signature]

County Engineer

By

Drainage District Engineer/Manager

Presented to Commissioners Court and approved.

Recorded in Volume 11-20-12
Minutes of Commissioners Court.

Clerk of Commissioners Court

By [Signature]
Deputy

**PERFORMANCE BOND COVERING ALL CABLE, CONDUIT AND/OR POLE LINE
ACTIVITY IN, UNDER, ACROSS OR ALONG FORT BEND COUNTY ROADS**

AUTHORIZED

BOND NO 58S204329

THE STATE OF TEXAS §

KNOW ALL MEN BY THESE PRESENTS:

COUNTY OF FORT BEND §

THAT WE, Hurtado Construction Company whose address is 2115 Center Street, Richmond, Texas 77469, Texas, hereinafter called the Principal, and West American Insurance Company, a Corporation existing under and by virtue of the laws of the State of Indiana and authorized to do an indemnifying business in the State of Texas, and whose principal office is located at 350 E. 96th Street, Indianapolis, IN 46240, whose officer residing in the State of Texas, authorized to accept service in all suits and actions brought within said State is Jeremy Medeiros and whose address is 1600 N. Collins Blvd #3000, Richardson, TX 75080, hereinafter called the Surety, and held and firmly bound unto, Robert E. Hebert, County Judge of Fort Bend County, Texas, or his successors in office, in the full sum of ONE HUNDRED SIXTY SIX THOUSAND ONE HUNDRED THIRTY SIX AND 00/100 Dollars (\$166,136.00) current, lawful money of the United States of America, to be paid to said Robert E. Hebert, County Judge of Fort Bend County, Texas, or his successors in office, to which payment well and truly to be made and done, we, the undersigned, bind ourselves and each of us, our heirs, executors, administrators, successors, assigns, and legal representatives, jointly and severally, by these presents.

THE CONDITION OF THIS BOND IS SUCH THAT, WHEREAS, the above bounden principal contemplates laying, constructing, maintaining and/or repairing one or more cables, conduits, and/or pole lines in, under, across and/or along roads, streets and highways in the County of Fort Bend, and the State of Texas, under the jurisdiction of the Commissioners' Court of Fort Bend County, Texas, pursuant to the Commissioners' Court order adopted on the 1st day of December, A.D. 1980, recorded in Volume 13, of the Commissioners' Court Minutes of Fort Bend County, Texas, regulating same, which Commissioners' Court order is hereby referred to and made a part hereof for all purposes as though fully set out herein;

AND WHEREAS, the principal desires to provide Fort Bend County with a performance bond covering all such cable, conduit and/or pole line activity;

NOW, THEREFORE, if the above bounden principal shall faithfully perform all its cable, conduit and/or pole line activity (including, but not limited to the laying, construction, maintenance and/or repair of cables, conduits and/or pole lines) in, under, across and/or along roads, streets and highways in the County of Fort Bend and State of Texas, under the jurisdiction of the Commissioners Court of Fort Bend County, Texas, pursuant to and in accordance with minimum requirements and conditions of the above mentioned Commissioners' Court order set forth and specified to be by said principal done and performed, at the time and in the manner therein specified, and shall pay over and make good and reimburse Fort Bend County, all loss and damages which Fort Bend County may sustain by reason of any failure or default on the part of said principal, then this obligation shall be null and void, otherwise to remain in full force and effect.

This bond is payable at the County Courthouse in the County of Fort Bend and State of Texas.

It is understood that at any time Fort Bend County deems itself insecure under this bond, it may require further and/or additional bonds of the principal.

EXECUTED this 1st day of November, 20 12.

 
Hurtado Construction Company

PRINCIPAL

BY 

West American Insurance Company

SURETY

BY  Jacqueline Kirk, Attorney in Fact

THIS POWER OF ATTORNEY IS NOT VALID UNLESS IT IS PRINTED ON RED BACKGROUND.

This Power of Attorney limits the acts of those named herein, and they have no authority to bind the Company except in the manner and to the extent herein stated.

Certificate No. 5551925

American Fire and Casualty Company
The Ohio Casualty Insurance Company
West American Insurance Company

Liberty Mutual Insurance Company
Peerless Insurance Company

POWER OF ATTORNEY

KNOWN ALL PERSONS BY THESE PRESENTS: That American Fire & Casualty Company and The Ohio Casualty Insurance Company are corporations duly organized under the laws of the State of Ohio, that Liberty Mutual Insurance Company is a corporation duly organized under the laws of the State of Massachusetts, that Peerless Insurance Company is a corporation duly organized under the laws of the State of New Hampshire, and West American Insurance Company is a corporation duly organized under the laws of the State of Indiana (herein collectively called the "Companies"), pursuant to and by authority herein set forth, does hereby name, constitute and appoint, Cindy Peters; Jacqueline Kirk; Judy M. Dold; Larry H. Senkel; Mark Hilliard; Theresa Gildart

all of the city of Houston, state of TX each individually if there be more than one named, its true and lawful attorney-in-fact to make, execute, seal, acknowledge and deliver, for and on its behalf as surety and as its act and deed, any and all undertakings, bonds, recognizances and other surety obligations, in pursuance of these presents and shall be as binding upon the Companies as if they have been duly signed by the president and attested by the secretary of the Companies in their own proper persons.

IN WITNESS WHEREOF, this Power of Attorney has been subscribed by an authorized officer or official of the Companies and the corporate seals of the Companies have been affixed thereto this 6th day of September, 2012.



American Fire and Casualty Company
The Ohio Casualty Insurance Company
Liberty Mutual Insurance Company
Peerless Insurance Company
West American Insurance Company

By: Gregory W. Davenport
Gregory W. Davenport, Assistant Secretary

STATE OF WASHINGTON ss
COUNTY OF KING

On this 6th day of September, 2012, before me personally appeared Gregory W. Davenport, who acknowledged himself to be the Assistant Secretary of American Fire and Casualty Company, Liberty Mutual Insurance Company, The Ohio Casualty Company, Peerless Insurance Company and West American Insurance Company, and that he, as such, being authorized so to do, execute the foregoing instrument for the purposes therein contained by signing on behalf of the corporations by himself as a duly authorized officer.

IN WITNESS WHEREOF, I have hereunto subscribed my name and affixed my notarial seal at Seattle, Washington, on the day and year first above written.



By: KD Riley
KD Riley, Notary Public

This Power of Attorney is made and executed pursuant to and by authority of the following By-laws and Authorizations of American Fire and Casualty Company, The Ohio Casualty Insurance Company, Liberty Mutual Insurance Company, West American Insurance Company and Peerless Insurance Company, which resolutions are now in full force and effect reading as follows:

ARTICLE IV – OFFICERS – Section 12. Power of Attorney. Any officer or other official of the Corporation authorized for that purpose in writing by the Chairman or the President, and subject to such limitation as the Chairman or the President may prescribe, shall appoint such attorneys-in-fact, as may be necessary to act in behalf of the Corporation to make, execute, seal, acknowledge and deliver as surety any and all undertakings, bonds, recognizances and other surety obligations. Such attorneys-in-fact, subject to the limitations set forth in their respective powers of attorney, shall have full power to bind the Corporation by their signature and execution of any such instruments and to attach thereto the seal of the Corporation. When so executed, such instruments shall be as binding as if signed by the President and attested to by the Secretary. Any power or authority granted to any representative or attorney-in-fact under the provisions of this article may be revoked at any time by the Board, the Chairman, the President or by the officer or officers granting such power or authority.

ARTICLE XIII – Execution of Contracts – SECTION 5. Surety Bonds and Undertakings. Any officer of the Company authorized for that purpose in writing by the chairman or the president, and subject to such limitations as the chairman or the president may prescribe, shall appoint such attorneys-in-fact, as may be necessary to act in behalf of the Company to make, execute, seal, acknowledge and deliver as surety any and all undertakings, bonds, recognizances and other surety obligations. Such attorneys-in-fact subject to the limitations set forth in their respective powers of attorney, shall have full power to bind the Company by their signature and execution of any such instruments and to attach thereto the seal of the Company. When so executed such instruments shall be as binding as if signed by the president and attested by the secretary.

Certificate of Designation – The President of the Company, acting pursuant to the Bylaws of the Company, authorizes Gregory W. Davenport, Assistant Secretary to appoint such attorney-in-fact as may be necessary to act on behalf of the Company to make, execute, seal, acknowledge and deliver as surety any and all undertakings, bonds, recognizances and other surety obligations.

Authorization – By unanimous consent of the Company's Board of Directors, the Company consents that facsimile or mechanically reproduced signature of any assistant secretary of the Company, wherever appearing upon a certified copy of any power of attorney issued by the Company in connection with surety bonds, shall be valid and binding upon the Company with the same force and effect as though manually affixed.

I, David M. Carey, the undersigned, Assistant Secretary, of American Fire and Casualty Company, The Ohio Casualty Insurance Company, Liberty Mutual Insurance Company, West American Insurance Company and Peerless Insurance Company do hereby certify that the original power of attorney of which the foregoing is a full, true and correct copy of the Power of Attorney executed by said Companies, is in full force and effect and has not been revoked.

IN TESTIMONY WHEREOF, I have hereunto set my hand and affixed the seals of said Companies this 1st day of November, 2012.



By: David M. Carey
David M. Carey, Assistant Secretary

IMPORTANT NOTICE

**TO OBTAIN INFORMATION OR MAKE A COMPLAINT:
YOU MAY CONTACT THE TEXAS DEPARTMENT OF INSURANCE
TO OBTAIN INFORMATION ON COMPANIES, COVERAGES,
RIGHTS OR COMPLAINTS AT:**

1-800-252-3439

YOU MAY WRITE THE TEXAS DEPARTMENT OF INSURANCE:

**P. O. BOX 149104
AUSTIN, TEXAS 78714-9104
FAX #(512) 475-1771**

PREMIUM OR CLAIM DISPUTES:

**SHOULD YOU HAVE A DISPUTE CONCERNING YOUR PREMIUM
OR ABOUT A CLAIM, YOU SHOULD CONTACT THE AGENT OR
COMPANY FIRST. IF THE DISPUTE IS NOT RESOLVED, YOU MAY
CONTACT THE TEXAS DEPARTMENT OF INSURANCE.**

ATTACH THIS NOTICE TO YOUR POLICY

**THIS NOTICE IS FOR INFORMATION ONLY AND DOES NOT BECOME
A PART OR CONDITION OF THE ATTACHED DOCUMENT.**

COUNTY OF FORT BEND

Engineering Department

P.O. BOX 1449

Rosenberg, Texas 77471-1449

Johnny Ortega

Permit Administrator

1124 Blume Road

Phone: (281) 341-7500

PERMIT APPLICATION REVIEW FORM FOR CABLE, CONDUIT, AND POLE LINE ACTIVITY IN FORT BEND COUNTY

PERMIT NO. 084240

The following "Notice of Proposed Cable, Conduit, and/or Pole Line activity in Fort Bend County" and accompanying attachments have been reviewed and the notice conforms to appropriate regulations set by Commissioner's Court of Fort Bend County, Texas.

- X (1) Complete Application Form.
- X a. Name of road, street, and/or drainage ditch affected.
- X b. Vicinity map showing course of direction.
- X c. Plans and specifications.

- X (2) Bond:
- District Attorney, approval when applicable.
- Perpetual bond currently posted.
- No.
- Amount
- X Performance bond submitted.
- No. 58S204329
- Amount \$166,136.00
- Cashier's Check.
- No.
- Amount


- (3) Verbal permission given for emergencies, to start construction before approved in Commissioner's Court.

 Precinct Engineer Acknowledgment Date

 Precinct Commissioner Acknowledgment Date

- (4)
- Drainage District Approval when applicable

We have reviewed this project and agree it meets minimum requirements.

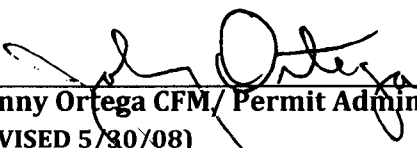
Johnny Ortega CFM/ Permit Administrator
(REVISED 5/30/08)

11/08/2012
Date

**NOTICE OF PROPOSED CABLE, CONDUIT AND/OR POLE LINE ACTIVITY
IN, UNDER, ACROSS OR ALONG ROADS, STREETS, HIGHWAYS AND DRAINAGE DITCHES
IN FORT BEND COUNTY**

APPLICANT'S JOB NO. 457
 PERMIT No. 84240 PCT. No. 4
 BOND No. 588204329

Formal notice is hereby given that _____
 proposes to lay, construct, maintain and/or repair cable, conduit and/or pole line, in, under,
 across, or along roads, streets, highways and drainage ditches in Fort Bend County, as follows:

In, Under, or Across Roads and/or Drainage Ditches

Road or Ditch Name	Distance & Direction From : Nearest Intersection	Length of : Crossing	Type of Construction : Bored: Jacked: Driven: Cased
BELLAIR BLVD.	500 LF NE OF CANAL RD.	142'	✓ : : :
GRAND PARICWAY 99	350 LF NW OF CANAL RD.	370'	✓ : : :
CANAL RD.	500 LF OF GRAND PARICWAY 99	15'	✓ : : :

Along Roads and/or Drainage Ditches

Road or Ditch Name	Distance & Direction From : Nearest Intersection	To : Distance

General Description

Installation of 24" and 42" Water Lines


The Location and description of the proposed installation and appurtenances is more fully shown on the attached detail drawings. The laying, construction, maintenance and/or repair of the proposed installation shall be subject to "A Revised Order Regulating the Laying, Construction, Maintenance and/or Repair of Cables, Conduits, and/or Pole Lines, In, Under, Across, or Along Roads, Streets, Highways and Drainage Ditches in Fort Bend County, Texas, Under the Jurisdiction of the Commissioners Court of Fort Bend County, Texas," as passed by Commissioners Court of Fort Bend County, Texas, dated the 3rd. day of August, 1987, recorded in Volume 639 of the Minutes of the Commissioners Court of Fort Bend County, Texas.

Written notices are required: 1) 48 hours in advance of start of construction and
 2) when construction is complete and ready for final inspection.

Mail to: Permit Administrator/Fort Bend County Engineering
 P.O. Box 1449, Rosenberg, TX 77471.

Violation of requirements shall constitute grounds for job shut down.

COMPANY NAME HURTADO CONSTRUCTION CO.
 AGENT and/or OWNER


 (Signature)

NAME & TITLE BENJAMIN C. VASQUEZ, CM
 (Please Print)

DATE 11/02/2012

ADDRESS 2115 CENTER ST.
 (Street/P.O. Box)

RICHMOND, TX. 77469
 City State Zip

TELEPHONE NO: 281 802 8717
 (accessible 24 hrs/day, 7 days/week)

Does project
 comply with Fort
 Bend County
 Outdoor Lighting
 Ordinance?

Yes ()

No ()

**NOTICE OF PROPOSED CABLE, CONDUIT AND/OR POLE LINE ACTIVITY
IN, UNDER, ACROSS OR ALONG ROADS, STREETS, HIGHWAYS AND DRAINAGE DITCHES
IN FORT BEND COUNTY**

APPLICANT'S JOB NO. _____

PERMIT No. _____ PCT. No. _____

BOND No. _____

Formal notice is hereby given that _____
proposes to lay, construct, maintain and/or repair cable, conduit and/or pole line, in, under,
across, or along roads, streets, highways and drainage ditches in Fort Bend County, as follows:

In, Under, or Across Roads and/or Drainage Ditches

Road or Ditch Name	: Distance & Direction From : Nearest Intersection	: Length of : Crossing	: Type of Construction : Bored: Jacked: Driven: Cased
CANAL RD.	500 LF E OF GRAND PARKWAY 99	120'	OPEN CUT
SKINNER RD.	850 LF SE OF CANAL RD.	60'	OPEN CUT
FBC MUD/US DRAINAGE CHANNEL	500 LF NE OF GIBRALTER PL.	149'	✓

Along Roads and/or Drainage Ditches

Road or Ditch Name	: Distance & Direction From : Nearest Intersection	: To	: Distance

General Description

Installation of 24" and 42" water lines

The location and description of the proposed installation and appurtenances is more fully shown on the attached detail drawings. The laying, construction, maintenance and/or repair of the proposed installation shall be subject to "A Revised Order Regulating the Laying, Construction, Maintenance and/or Repair of Cables, Conduits, and/or Pole Lines, In, Under, Across, or Along Roads, Streets, Highways and Drainage Ditches in Fort Bend County, Texas, Under the Jurisdiction of the Commissioners Court of Fort Bend County, Texas," as passed by Commissioners Court of Fort Bend County, Texas, dated the 3rd. day of August, 1987, recorded in Volume 639 of the Minutes of the Commissioners Court of Fort Bend County, Texas.

Written notices are required: 1) 48 hours in advance of start of construction and
2) when construction is complete and ready for final inspection.

Mail to: Permit Administrator/Fort Bend County Engineering
P.O. Box 1449, Rosenberg, TX 77471.

Violation of requirements shall constitute grounds for job shut down.

COMPANY NAME: _____

AGENT and/or OWNER

(Signature)

NAME & TITLE _____

(Please Print)

DATE _____

ADDRESS _____

(Street/P.O. Box)

City State Zip

TELEPHONE NO: _____


(accessible 24 hrs/day, 7 days/week)

**Does project
comply with Fort
Bend County
Outdoor Lighting
Ordinance?**


Yes ()

No ()


**NORTH FORT BEND WATER AUTHORITY
SEGMENT 7C
PROPOSED 42" TRANSMISSION WATER LINE
FROM BELLAIRE BOULEVARD TO
FORT BEND M.U.D. 165 DRAINAGE CHANNEL**

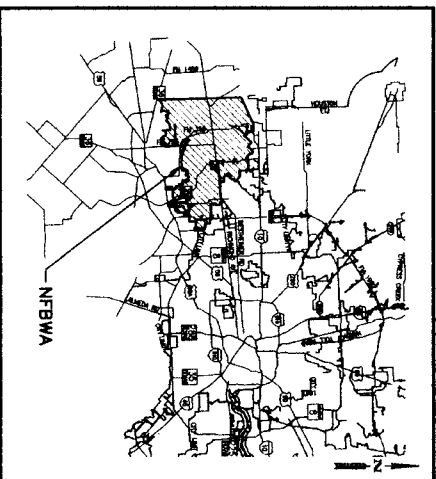

LOCATION MAP
N.T.S.

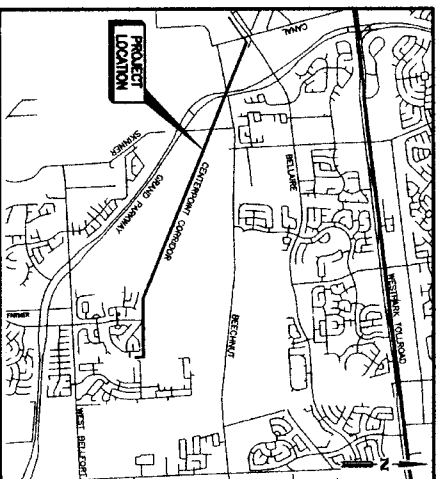

VICINITY MAP
KEY MAP NO. 525K, P.Q.R.Y., 526S.T
ZIP CODE: 77407
N.T.S.

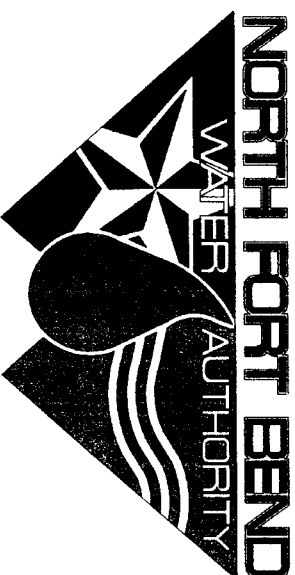

DIRECTORS

PRECINCT

DAVID SPELL
ROBERT DARDEN
BRUCE FAY
MELONY F. GAY, P.E.
ROBERT L. PATTON
PETER HOUGHTON
PAT HEBERT

FORT BEND COUNTY

APPROVED:

RICHARD W. STOLLEIS, P.E.
FORT BEND COUNTY ENGINEER

DATE _____

I, MELINDA D. SILVA P.E., CERTIFY THAT THIS PROJECT LIES OUTSIDE THE 100-YEAR FLOODPLAIN.

FROM MAP # 48157C0115J & 48157C0120J
PANEL: 115 & 120 OF 550
DATE: 01/03/97
BFE: 63.0-61.0

* NO KNOWN PROPOSED WASTEWATER WORK IS SHOWN ON THIS PLAN SET, NOR INCLUDED IN ITS WORK SCOPE.

**ALL FUTURE ACCESS AND MAINTENANCE
REMAIN THE RESPONSIBILITY OF THE NFBWA.**


ONE-CALL NOTIFICATION SYSTEM
CALL BEFORE YOU DIG!!!
(713) 223-4567
(New Statewide Number Outside Houston)
1-800-545-6005


Contractor shall notify the City of Houston Department of Public Works and Engineering, O.C.E. (Telephone No. 832-395-4424) 48 hours before starting work on this project.

ISSUE DATE: SEPTEMBER 2012

ILMS NO: 11109224
LOG NO: 11-1035

[illegible]

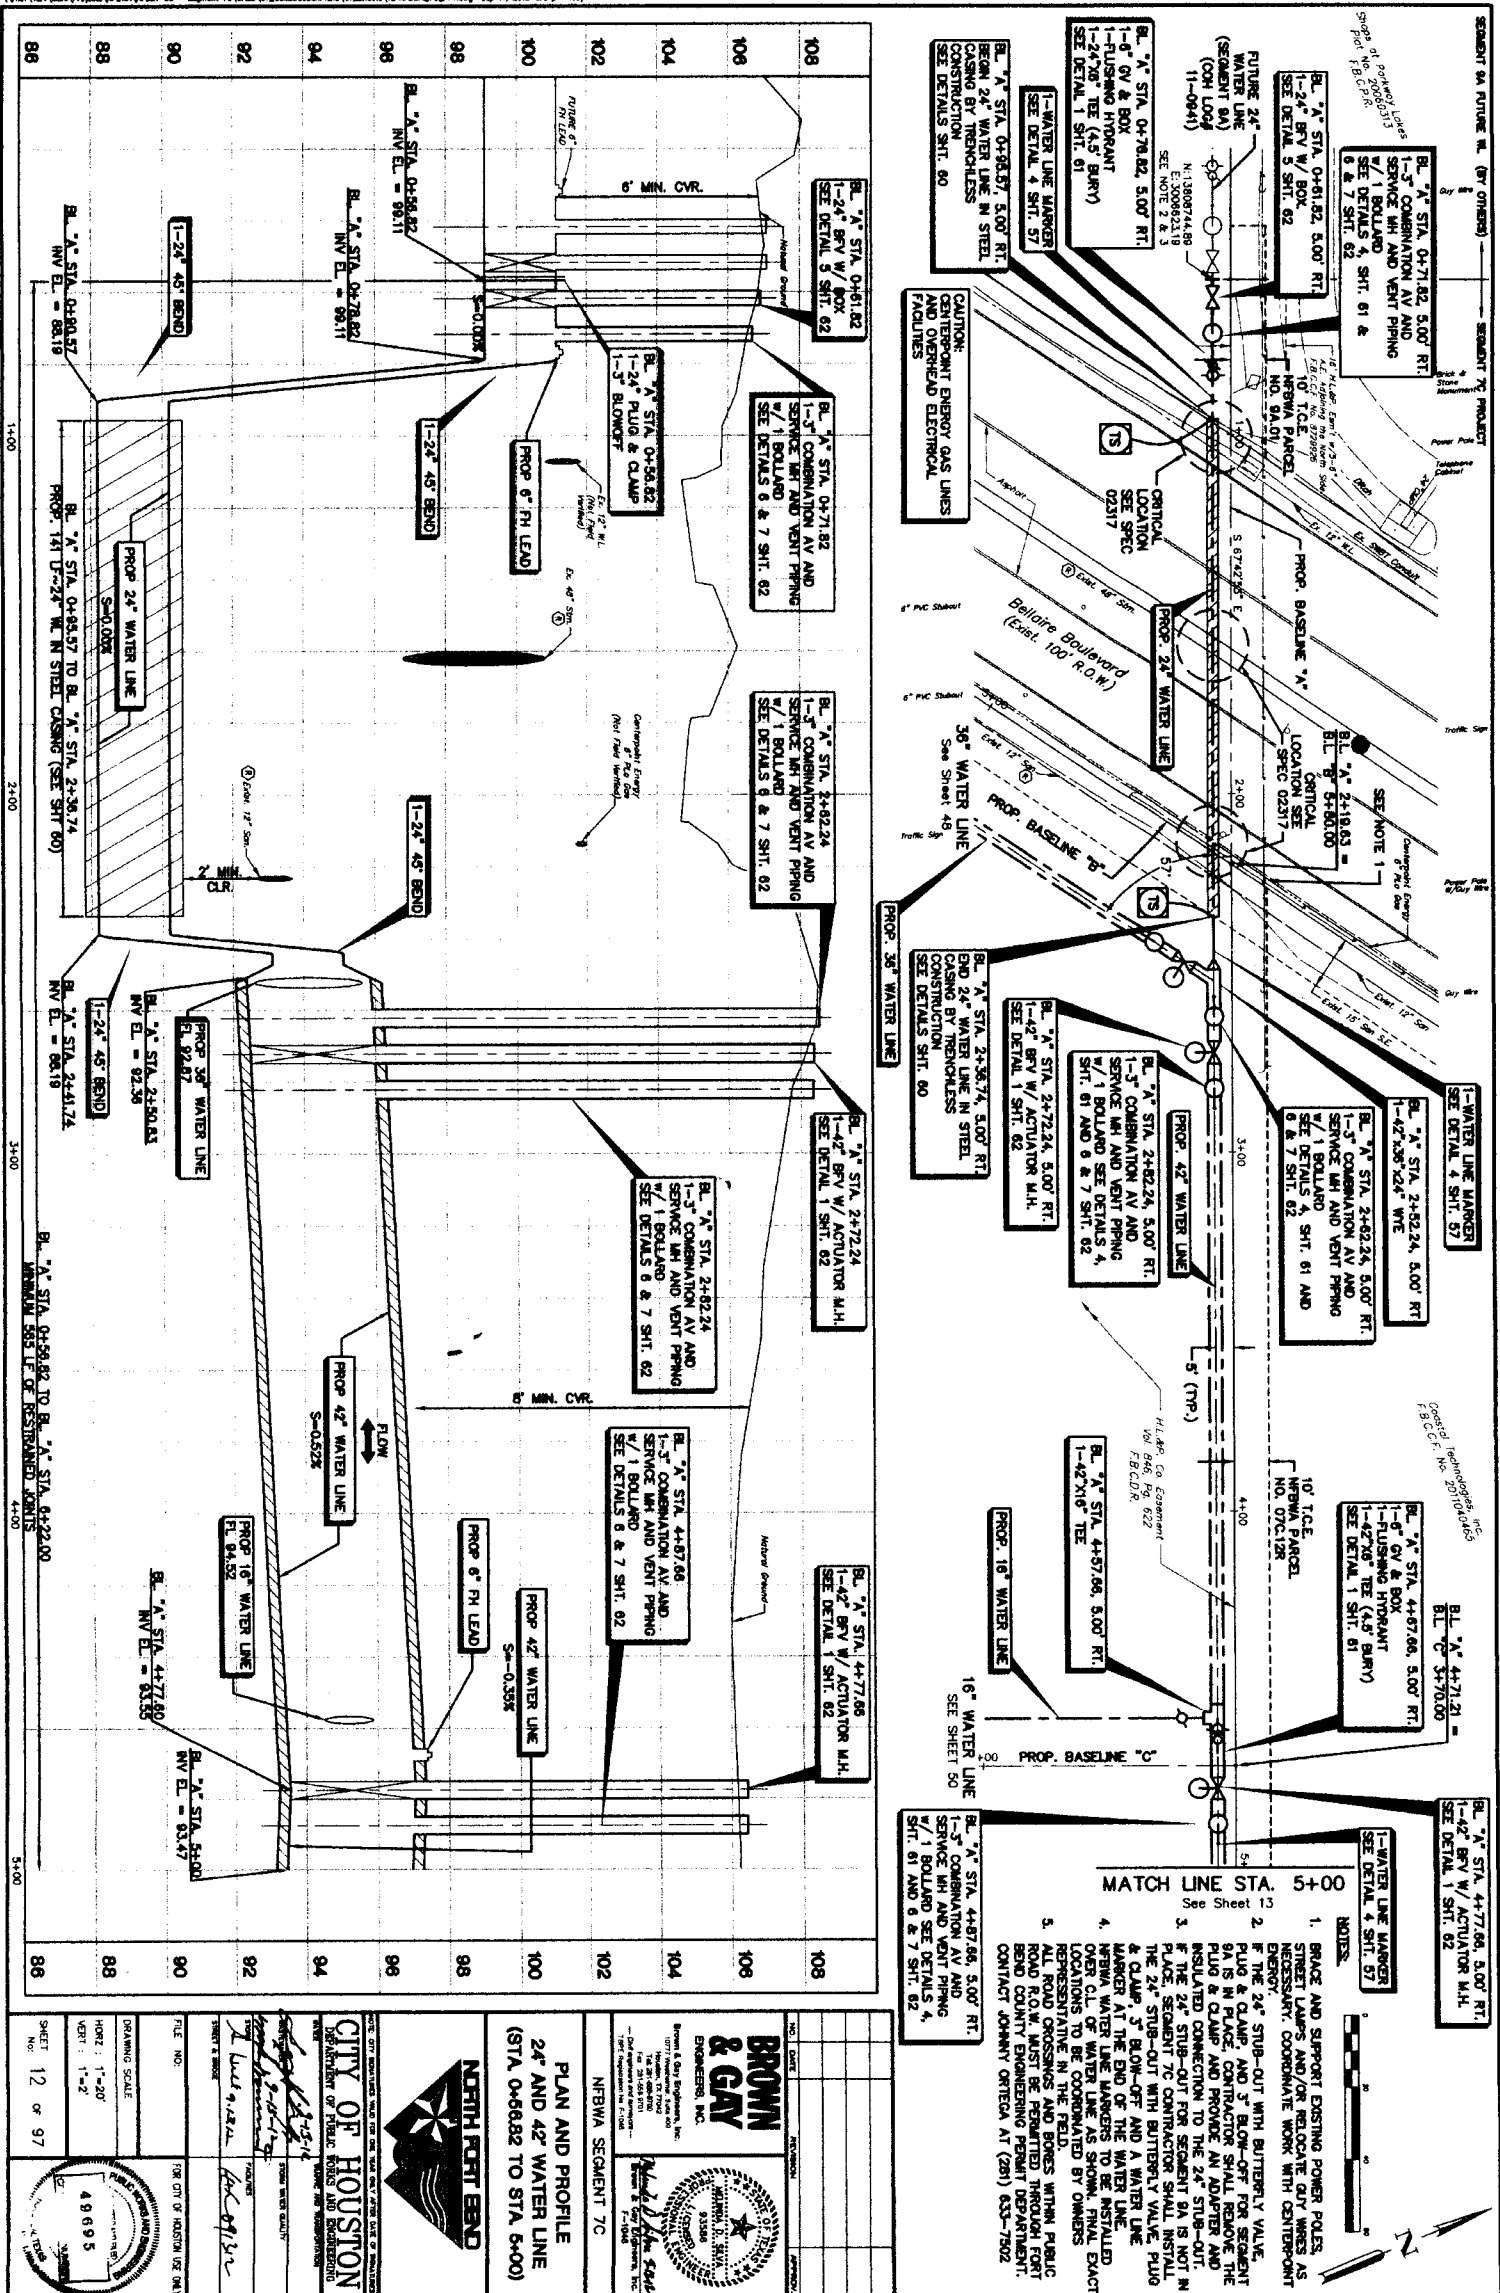

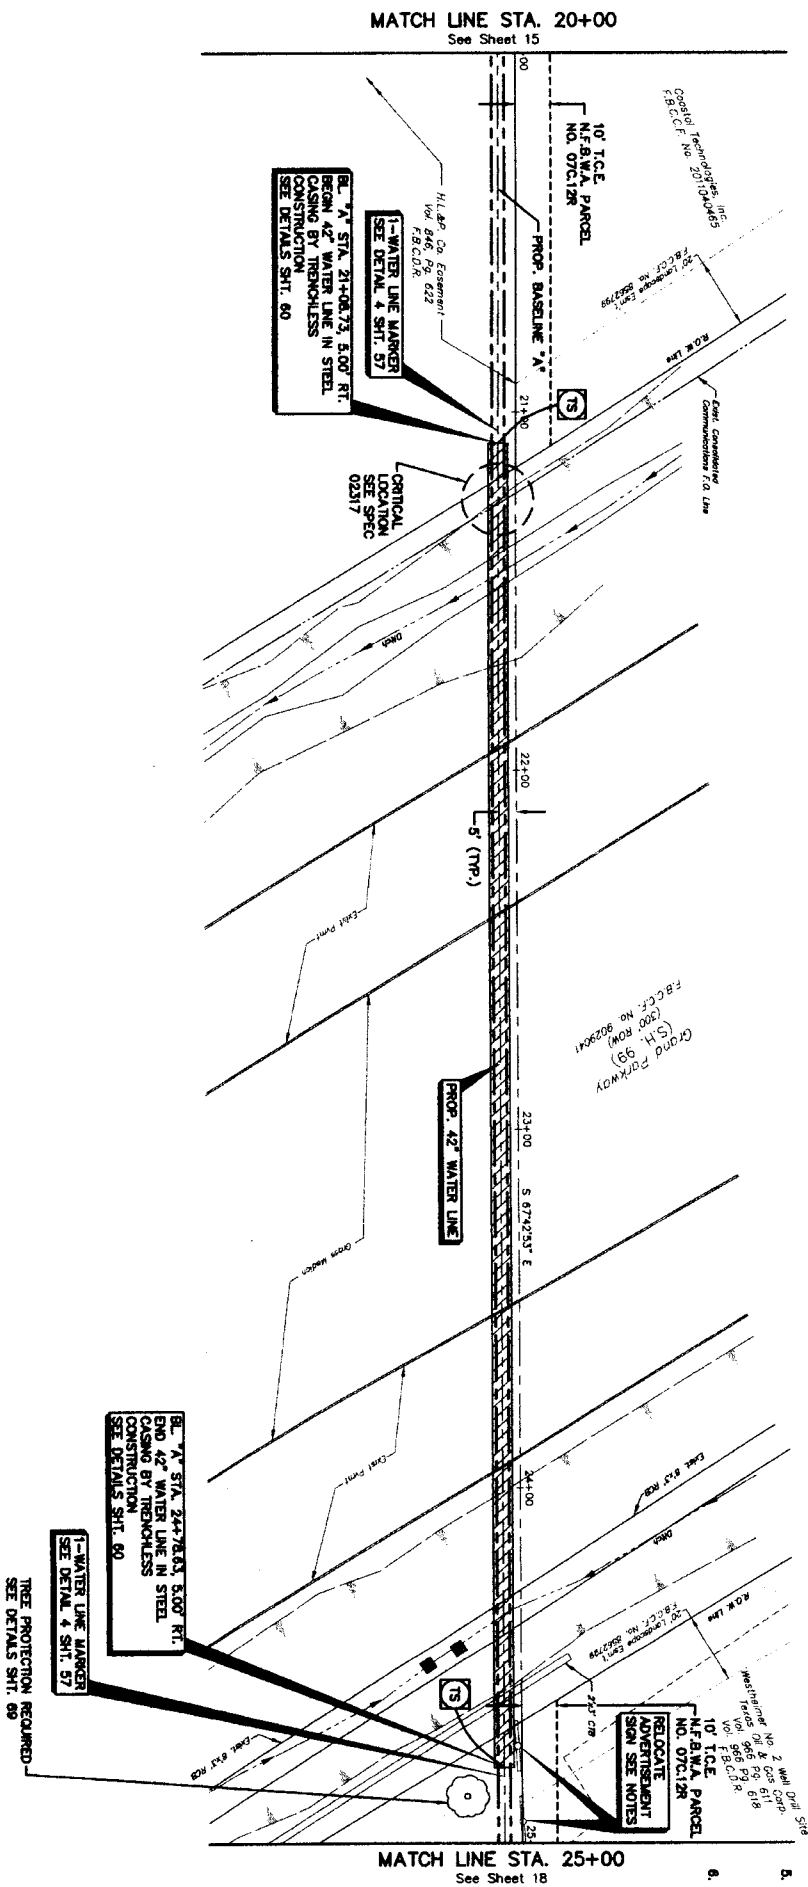
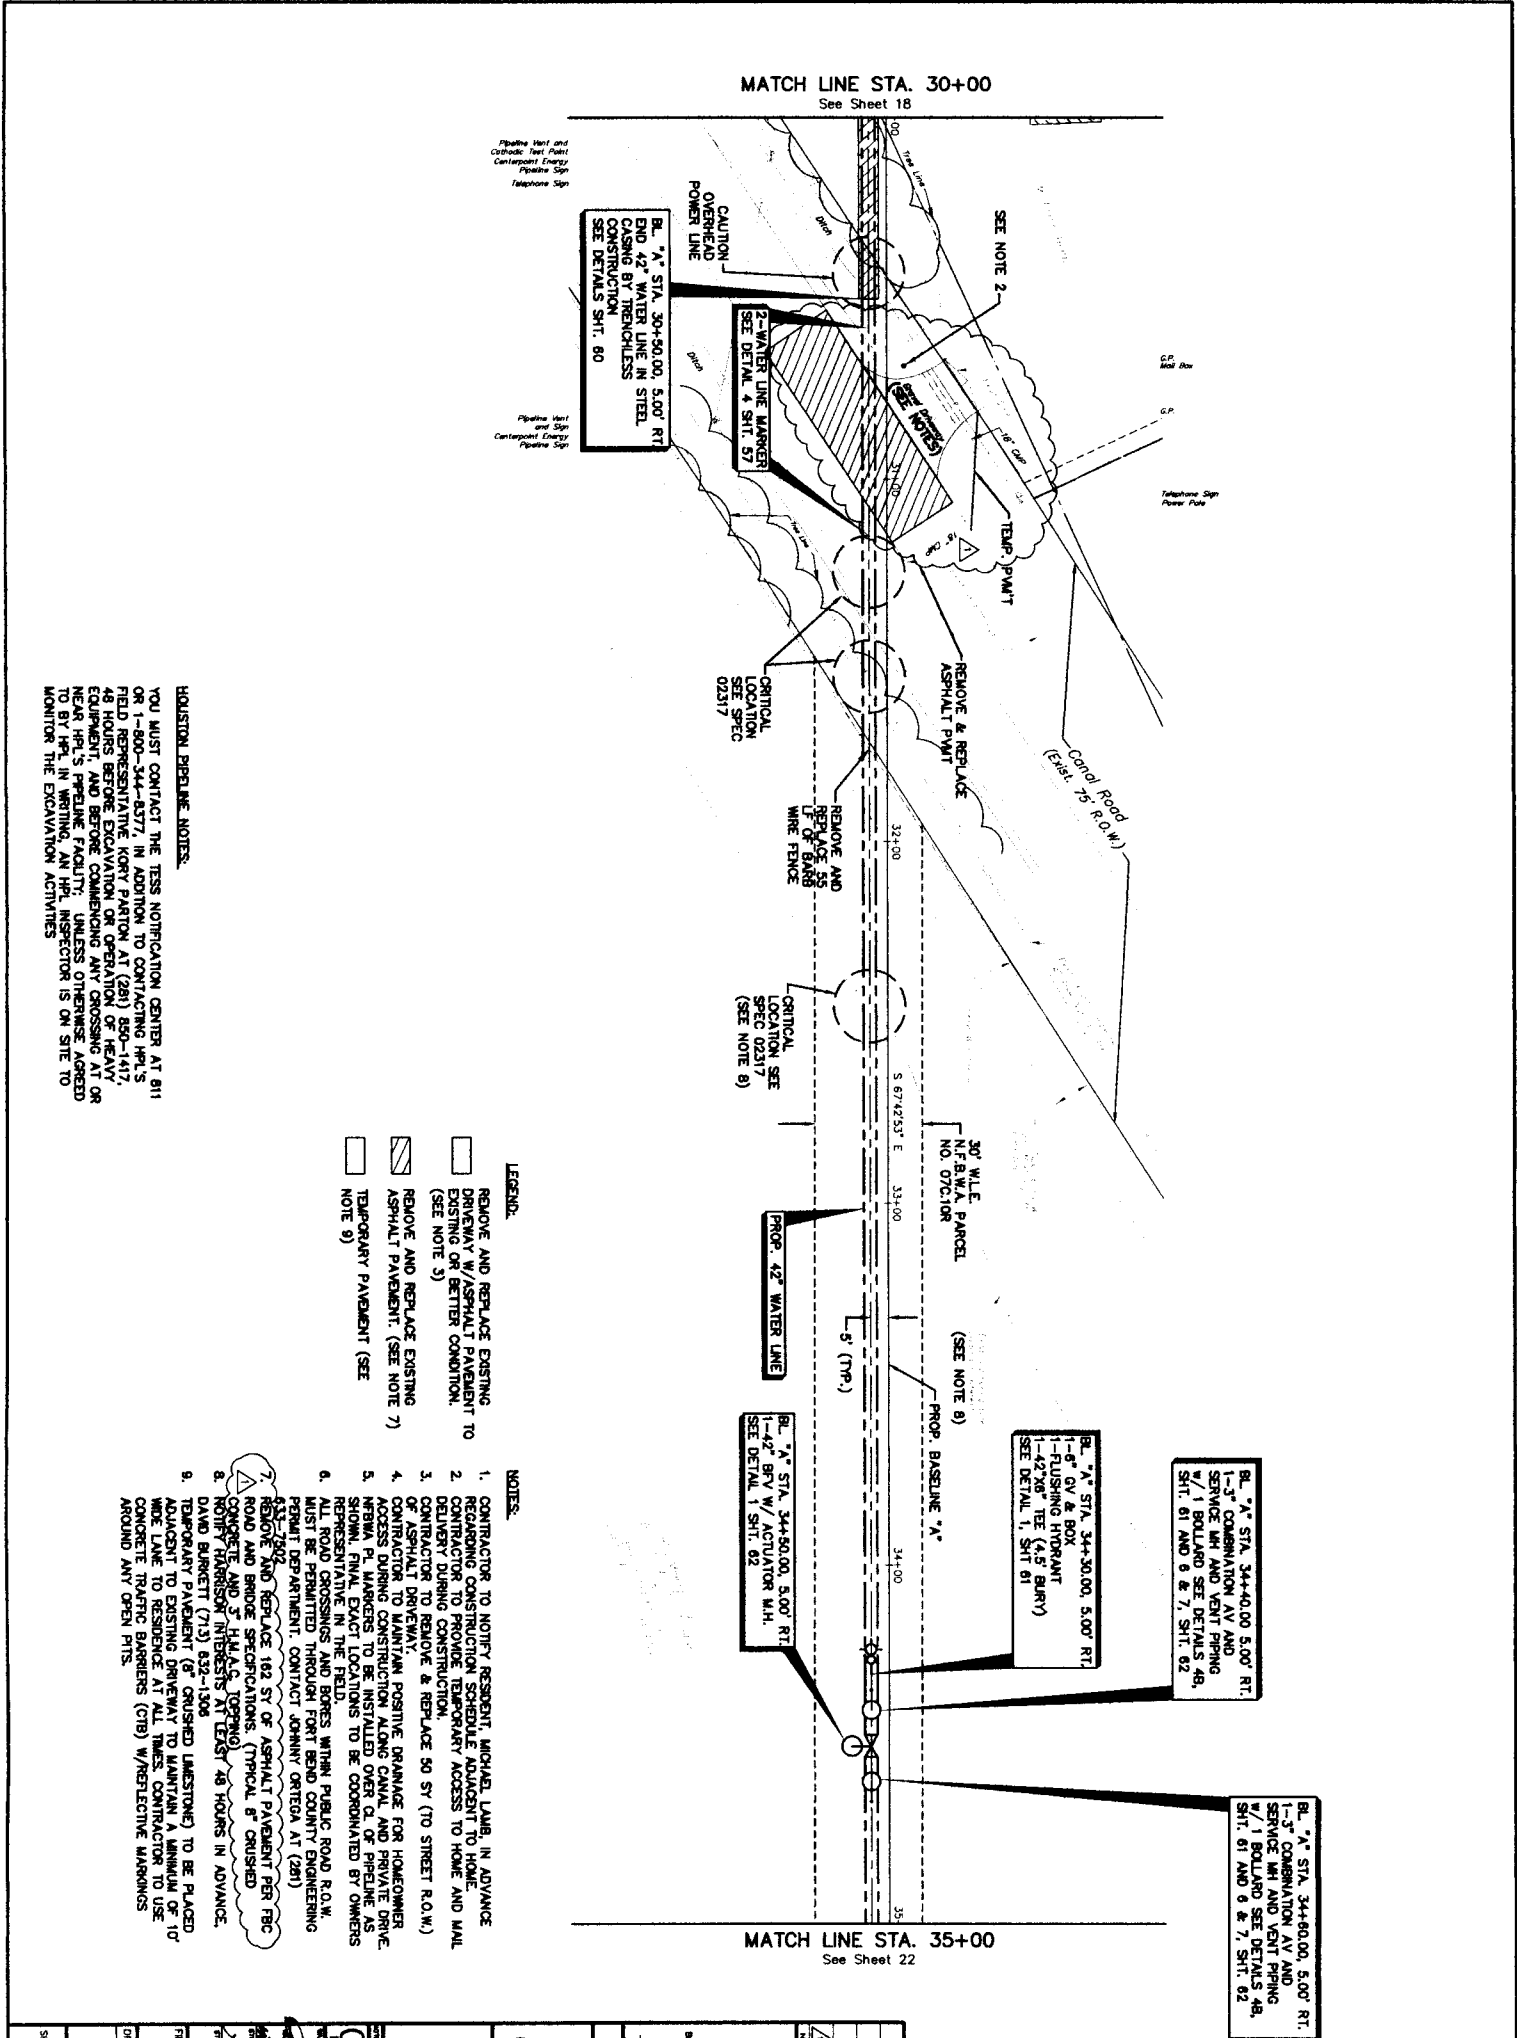


NOTES:

1. CONTRACTOR TO RELOCATE EXISTING ADJUSTMENT SIGNS APPROXIMATELY 10 FT. NORTH, COORDINATE EXACT LOCATION WITH AUTHORITY'S ENGINEER.
2. SIGNS SHALL BE AT SAME ANGLE TO MAINTAIN EXISTING WATER LINE.
3. EXISTING SIGNS SHALL BE REPAIRED BACK TO EXISTING OR BETTER CONDITION.
4. SIGN POSTS TO BE INSTALLED IN NEW LOCATION USING EXISTING OR BETTER CONSTRUCTION TECHNIQUES.
5. NEW WATER LINE MARKERS TO BE AS SHOWN. FINAL EXACT LOCATIONS TO BE COORDINATED BY AUTHORITY'S ENGINEER IN THE FIELD.
6. ALL NEW ROAD SIGNS MUST BE PERMITTED THROUGH FORT BEND COUNTY ENGINEERING PERMIT DEPARTMENT. CONTACT JOHNNY CRIGAN AT (281) 633-7602.



NO. DATE		REVISION		APPROVAL	
BROWN & GAY ENGINEERS, INC. 11551 VICTORY LANE, SUITE 200 HOUSTON, TEXAS 77058-1155 TEL: 281-460-0000 FAX: 281-460-0001 WWW.BROWN-AND-GAY.COM					
NFBWA SEGMENT 7C					
PLAN 42" WATER LINE (STA. 20+00 TO STA. 26+00)					
 CITY OF HOUSTON DEPARTMENT OF PUBLIC WORKS AND ENGINEERING 1001 PRAIRIE AVENUE, SUITE 100 HOUSTON, TEXAS 77010 TEL: 713-896-1000 FAX: 713-896-1001 WWW.CITYOFHOUSTON.ORG					
DATE: 11/11/2011 TIME: 11:11:11 AM					
FILE NO.					
DRAWING SCALE 1"=20'					
SHEET 16 OF 97					



1"=20'

48995

42" WATER LINE
(STA. 30+00 TO STA. 36+00)

PLAN

NITBWA SEGMENT 7C

CITY OF HOUSTON
DEPARTMENT OF PUBLIC WORKS AND MOBILITY

APPROVED
10/10/12
ADDENDUM NO. 2

BROWN & GAY ENGINEERS, INC.
1777 West Loop West, Suite 1000
Houston, Texas 77056
Tel: 713.866.8000
Fax: 713.866.8001
www.brownandgay.com

1-20'

48995

42" WATER LINE
(STA. 30+00 TO STA. 36+00)



PLAN

NITBWA SEGMENT 7C


CITY OF HOUSTON
DEPARTMENT OF PUBLIC WORKS AND MOBILITY

APPROVED
10/10/12
ADDENDUM NO. 2



BROWN & GAY ENGINEERS, INC.
1777 West Loop West, Suite 1000
Houston, Texas 77056
Tel: 713.866.8000
Fax: 713.866.8001
www.brownandgay.com

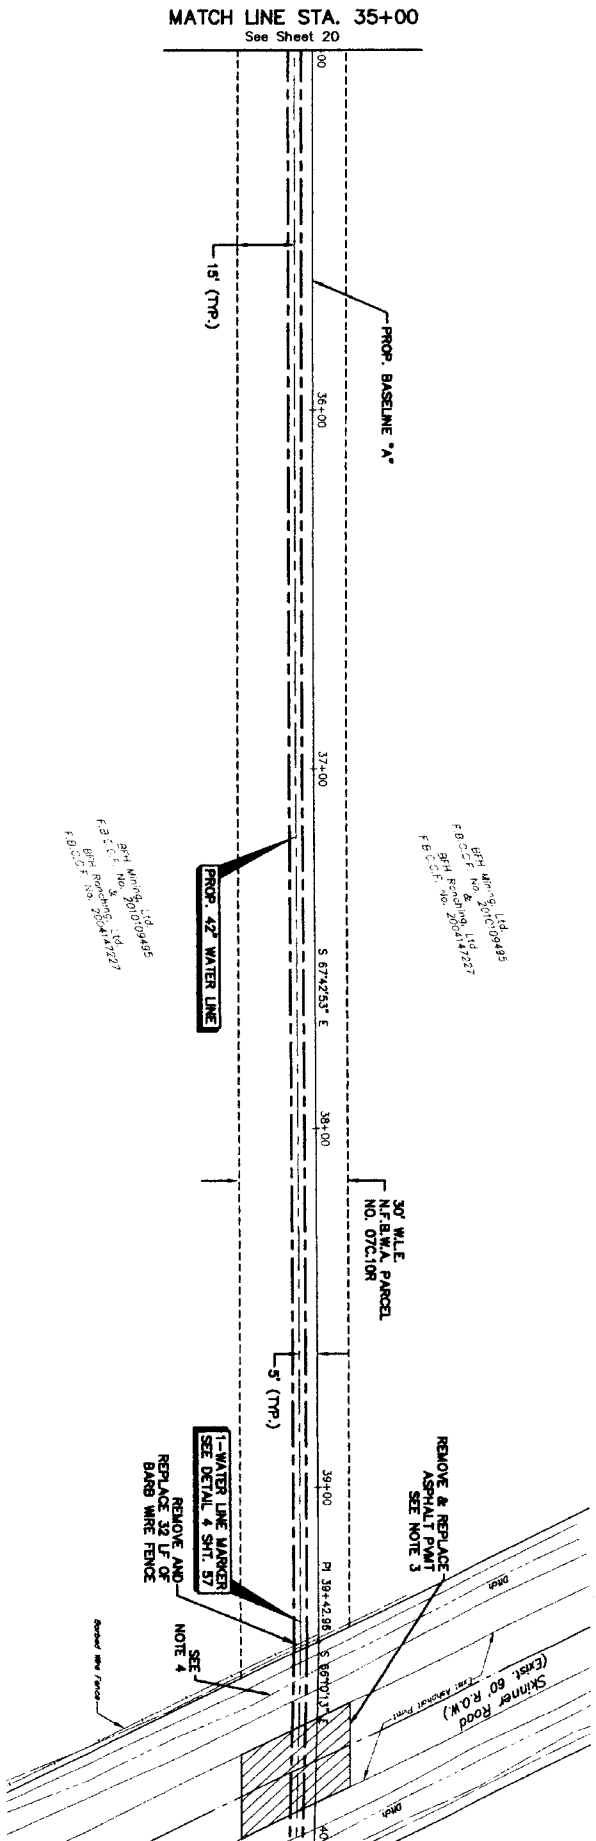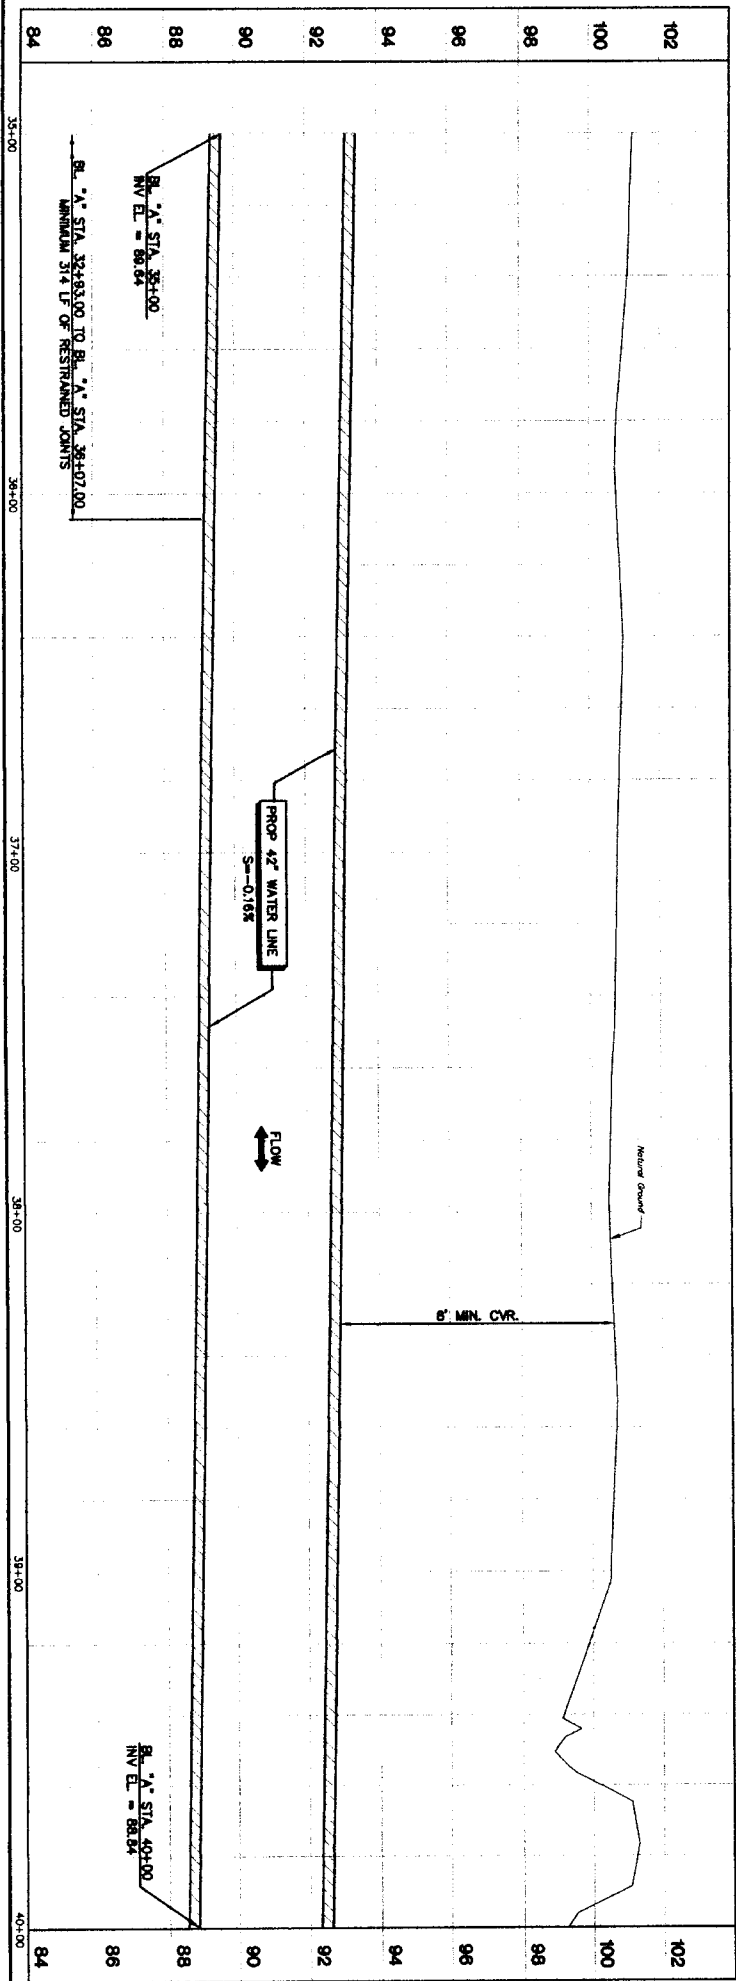


- NOTES:
1. NFWA WATER LINE MARKERS TO BE INSTALLED OVER C/L OF WATER LINE AS SHOWN. FINAL EXACT LOCATIONS TO BE COORDINATED BY AUTHORITY'S ENGINEER IN THE FIELD.
 2. ALL ROAD CROSSINGS AND BORES WITHIN PUBLIC ROAD R.O.W. MUST BE PERMITTED THROUGH FORT BEND COUNTY ENGINEERING PERMIT DEPARTMENT. CONTACT JOHNNY ORTEGA AT (281) 633-7502.
 3. REMOVE AND REPLACE 78 SY OF ASPHALT PAVEMENT (INCLUDING SUBBASE AND SUBGRADE).
 4. CONTRACTORS TO MAINTAIN POSITIVE DRAINAGE AND RESTORE DITCH TO EXISTING OR BETTER.

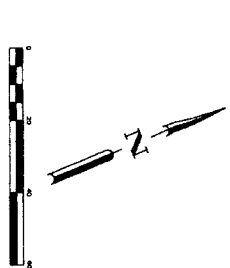


BROWN & GAY ENGINEERS, INC. 10777 Westheimer Road, Suite 600 Houston, Texas 77042 Tel: 281-486-6100 Fax: 281-486-6101 www.brown-gay.com City of Houston - Fort Bend County Professional Seal No. 11048		CITY OF HOUSTON DEPARTMENT OF PUBLIC WORKS AND ENGINEERING NAME: <i>John Ortega</i> TITLE: <i>City Engineer</i> DATE: <i>9/11/12</i> PROJECT: <i>WFBWA</i>	
PLAN AND PROFILE 42' WATER LINE (STA. 36+00 TO STA. 40+00)		NORTH FORT BEND	
DRAWING SCALE HORIZ: 1"=20' VERT: 1"=2'		SHEET 22 OF 97	

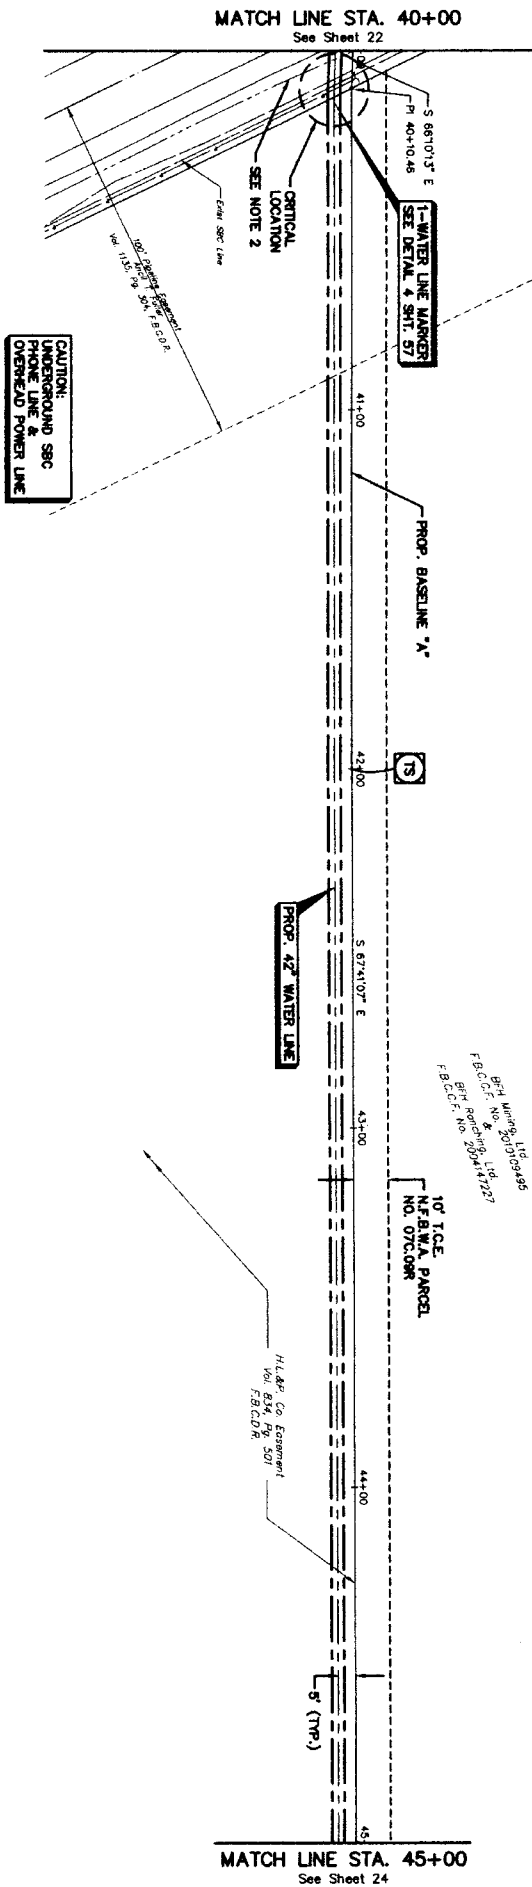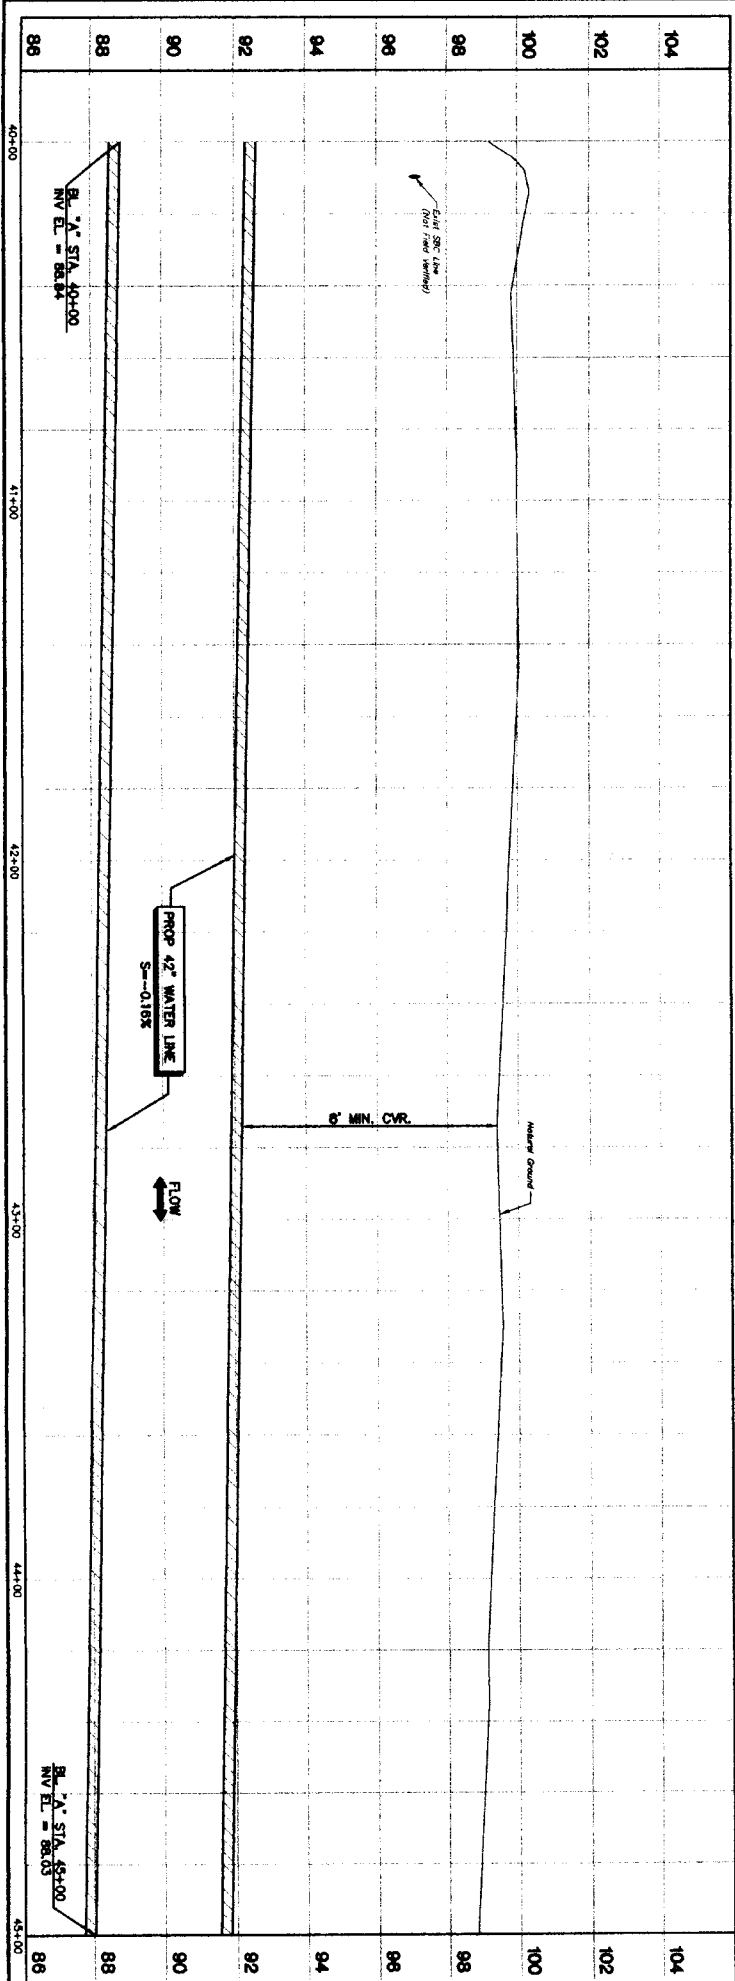


1. NEWPA WATER LINE MARKERS TO BE INSTALLED OVER C/L OF WATER LINE AS SHOWN. FINAL EXACT LOCATIONS TO BE COORDINATED BY AUTHORITY'S ENGINEER IN THE FIELD.
2. CONTRACTOR TO MAINTAIN POSITIVE DRAINAGE AND RESTORE DITCH TO EXISTING OR BETTER.

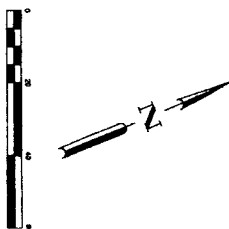

<p>BROWN & GAY ENGINEERS, INC.</p> <p>Brown & Gay Engineers, Inc. 10700 Westchase Parkway Houston, Texas 77042 Tel. 281-486-2010 Fax 281-486-2011 — Civil Engineering and Surveying — — City and Regional Planning — — Environmental Engineering — — Water Resources Engineering —</p>	<p>NO. DATE</p> <p>REV. DATE</p>	<p>NO. DATE</p> <p>REV. DATE</p>	<p>NO. DATE</p> <p>REV. DATE</p>	<p>NO. DATE</p> <p>REV. DATE</p>
<p>PLAN AND PROFILE 42" WATER LINE (87A, 40+00 TO 87A, 46+00)</p>	<p>NFBWA SEGMENT 7C</p>	<p>NORTH FORT BAND</p>	<p>CITY OF HOUSTON DEPARTMENT OF PUBLIC WORKS AND ENGINEERING WATER AND SEWERAGE DIVISION</p>	<p>CITY OF HOUSTON DEPARTMENT OF PUBLIC WORKS AND ENGINEERING WATER AND SEWERAGE DIVISION</p>
<p>DATE TIME BY</p>	<p>DATE TIME BY</p>	<p>DATE TIME BY</p>	<p>DATE TIME BY</p>	<p>DATE TIME BY</p>
<p>DATE TIME BY</p>	<p>DATE TIME BY</p>	<p>DATE TIME BY</p>	<p>DATE TIME BY</p>	<p>DATE TIME BY</p>
<p>DATE TIME BY</p>	<p>DATE TIME BY</p>	<p>DATE TIME BY</p>	<p>DATE TIME BY</p>	<p>DATE TIME BY</p>
<p>DATE TIME BY</p>	<p>DATE TIME BY</p>	<p>DATE TIME BY</p>	<p>DATE TIME BY</p>	<p>DATE TIME BY</p>
<p>DATE TIME BY</p>	<p>DATE TIME BY</p>	<p>DATE TIME BY</p>	<p>DATE TIME BY</p>	<p>DATE TIME BY</p>
<p>DATE TIME BY</p>	<p>DATE TIME BY</p>	<p>DATE TIME BY</p>	<p>DATE TIME BY</p>	<p>DATE TIME BY</p>

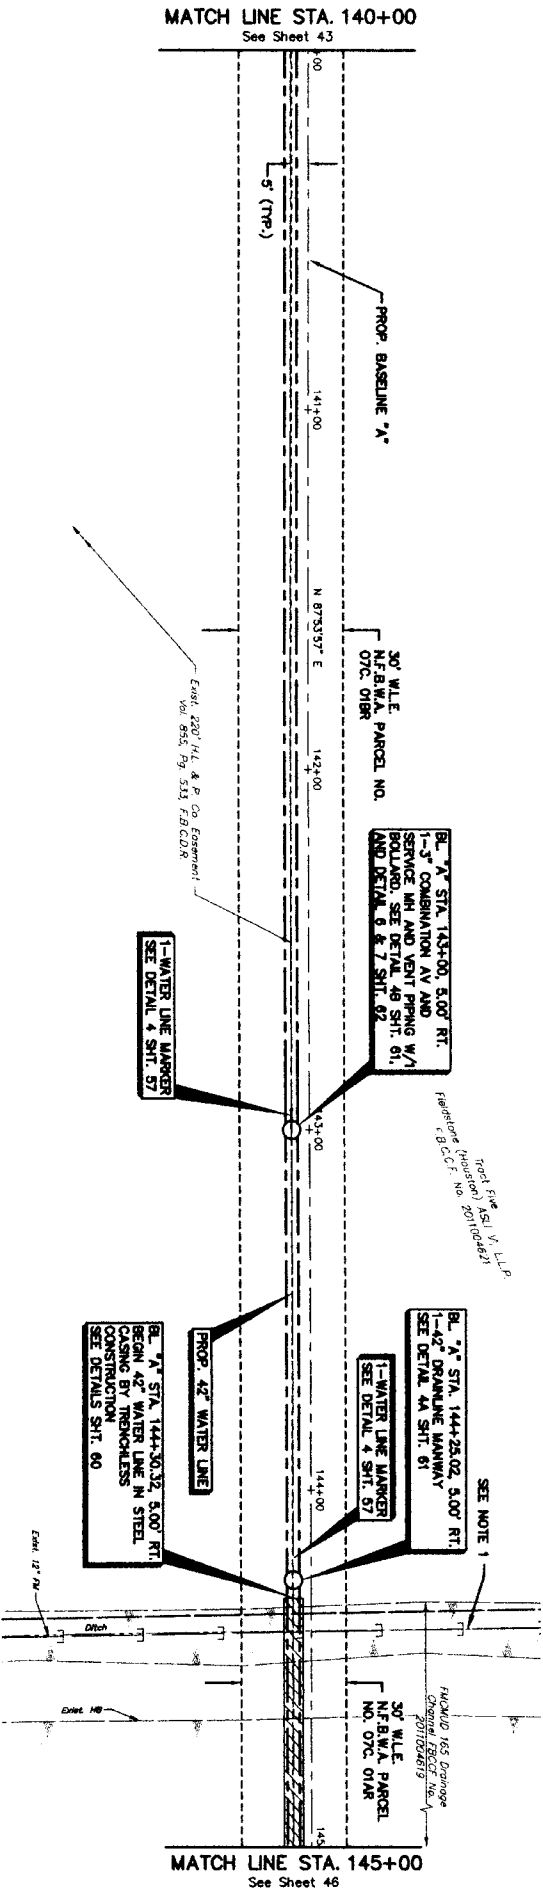

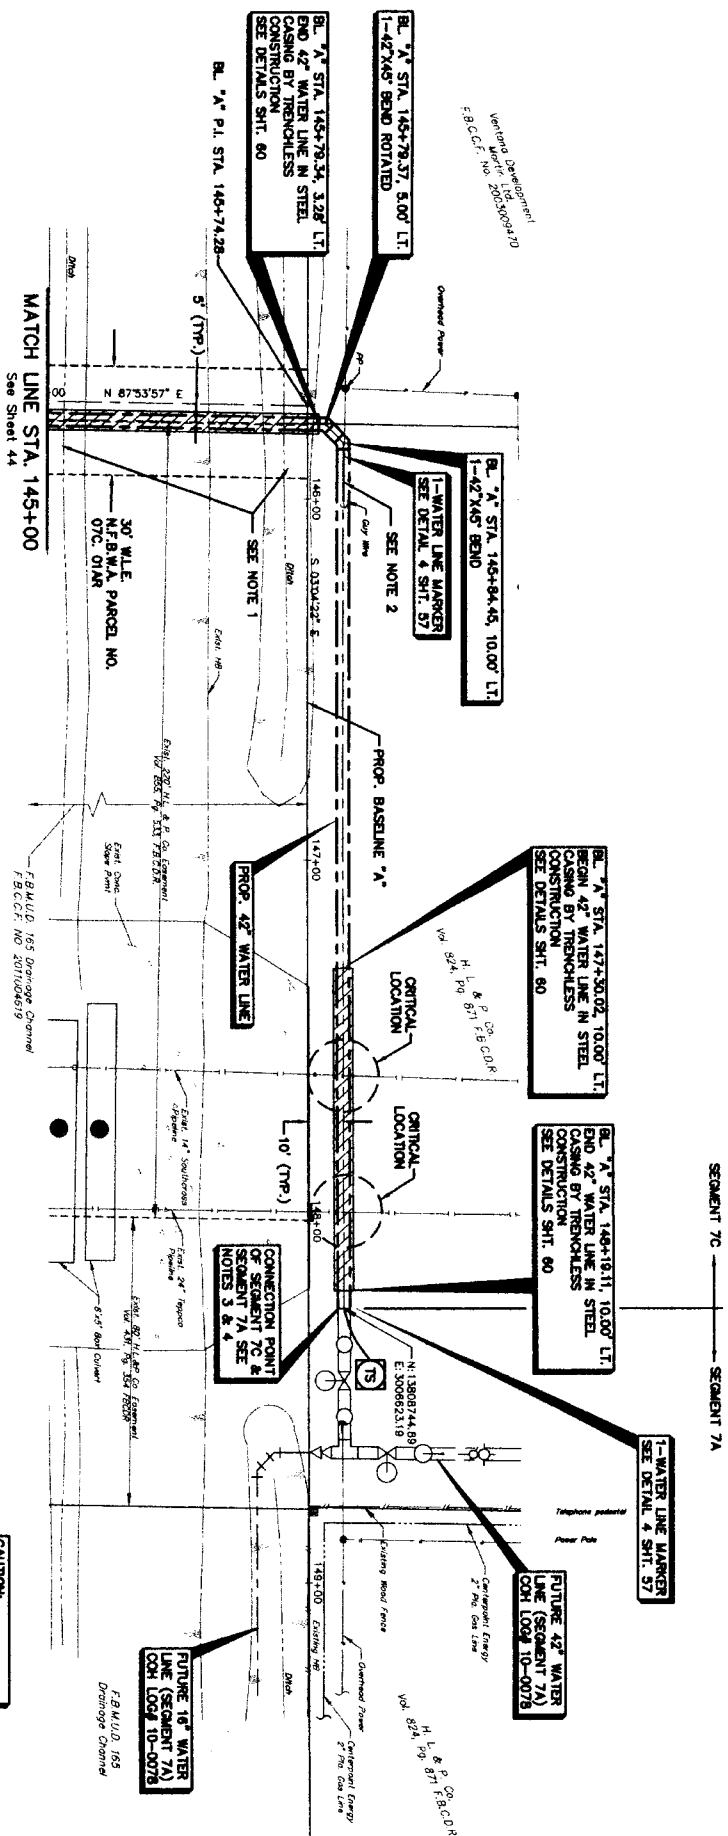

1. FLOOD 165 DRAINAGE CHANNEL TO BE RESTORED TO ORIGINAL OR BETTER CONDITION AND PROVIDE POSITIVE DRAINAGE.
2. BRACE AND SUPPORT EXISTING POWER POLES AND OR RELOCATE DUE TO WINDS AS NEEDED. COORDINATE WITH COMBINATION ENERGY.
3. IF THE 42" STUB-OUT WITH BUTTERFLY VALVE, ELIPTICAL DISKED HEAD PILE, AND 6" BLOW-OFF FOR SEGMENT 7A IS IN PLACE, CONTRACTOR SHALL REMOVE THE ELIPTICAL DISKED HEAD PILE AND PROVIDE AN ADAPTER AND INSTALLED CONNECTION TO THE 42" STUB-OUT.
4. IF THE 42" STUB-OUT FOR SEGMENT 7A IS NOT IN PLACE, SEGMENT 7B CONTRACTOR SHALL INSTALL THE 42" STUB-OUT WITH BUTTERFLY VALVE, ELIPTICAL DISKED HEAD PILE, 6" BLOW-OFF AND A WATER LINE MARKER AT THE END OF THE WATER LINE.
5. INTERVA WATER LINE MARKERS TO BE INSTALLED OVER ALL OF WATER LINE AS SHOWN ON PWD. DRAWINGS AND TO BE MAINTAINED AND REPORTED BY ADJUNCTS EMPLOYED IN THE FIELD.
6. NOTIFY ENTERPRISE PRODUCTS AT LEAST 46 HOURS IN ADVANCE. MR. ROY FITZPATRICK (713)518-5581.
7. NOTIFY SOUTHWEST ENERGY AT LEAST 48 HOURS IN ADVANCE. GAS CONTROL-1-877-980-9022.

[illegible]