

REVIEW BY FORT BEND COUNTY COMMISSIONERS COURT

On this 18 day of DECEMBER, 2012, Commissioners Court came on to be heard and reviewed the accompanying notice of PHONOSCOPE ENT. GROUP LLC.

Job Location GASTON ROAD, GREENBUSCH

 
Dated 12/10/12 Bond No. 103827669, Permit No. 84259 to make use of certain Fort Bend County property subject to, "A Revised Order Regulating the Laying, Construction, Maintenance, and Repair of Buried Cables, Conduits, and Pole Lines, In, Under, Across or Along Roads, Streets, Highways, and Drainage Ditches in Fort Bend County, Texas, Under the Jurisdiction of the Commissioners Court of Fort Bend County, Texas," as passed by the Commissioners Court of Fort Bend County, Texas, date the 3rd day of August, 1987, recorded in Volume _____ of the Minutes of the Commissioners Court of Fort Bend County, Texas, to the extent that such order is not inconsistent with Article 1436a, Vernon's Texas Civil Statutes. Upon Motion of Commissioner Meyers, seconded by Commissioner Patterson, duly put and carried, it is ORDERED, ADJUGED AND DECREED that said notice of said above purpose is hereby acknowledged by the Commissioners Court of Fort Bend County, Texas, and that said notice be placed on record according to the regulation order thereof.

Notes:

1. Evidence of review by the Commissioners Court must be kept on the job site and failure to do so constitutes grounds for job shutdown.
2. Written notices are required:
 - a. 48 hours in advance of construction start up, and
 - b. When construction is completed and ready for final inspection

Mail notices to: Permit Administrator
Fort Bend County Engineering
P.O. Box 1449
Rosenberg, Texas 77471
281-633-7500


3. This permit expires one (1) year from date of permit if construction has not commenced.

By 
County Engineer

By _____
Drainage District Engineer/Manager

Presented to Commissioners Court and approved.

 Recorded in Volume 12-18-12
Minutes of Commissioners Court.

Clerk of Commissioners Court
By 
Deputy

COUNTY OF FORT BEND

Engineering Department

P.O. BOX 1449
Rosenberg, Texas 77471-1449

Johnny Ortega
Permit Administrator

1124 Blume Road
Phone: (281) 341-7500

PERMIT APPLICATION REVIEW FORM FOR CABLE, CONDUIT, AND POLE LINE ACTIVITY IN FORT BEND COUNTY

PERMIT NO. 004259

The following "Notice of Proposed Cable, Conduit, and/or Pole Line activity in Fort Bend County" and accompanying attachments have been reviewed and the notice conforms to appropriate regulations set by Commissioner's Court of Fort Bend County, Texas.

- X (1) Complete Application Form.
- X a. Name of road, street, and/or drainage ditch affected.
 - X b. Vicinity map showing course of direction.
 - X c. Plans and specifications.

- X (2) Bond:
- _____ District Attorney, approval when applicable.
- X Perpetual bond currently posted.
- No. 103827669
- Amount \$50,000.00
- _____ Performance bond submitted.
- No. _____
- Amount _____
- _____ Cashier's Check.
- No. _____
- Amount _____

- _____ (3) Verbal permission given for emergencies, to start construction before approved in Commissioner's Court.

_____ Precinct Engineer Acknowledgment


_____ Date

_____ Precinct Commissioner Acknowledgment

_____ Date

- _____ (4) _____
- Drainage District Approval when applicable

We have reviewed this project and agree it meets minimum requirements.

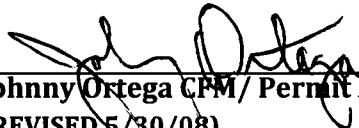
Johnny Ortega CPM/ Permit Administrator
(REVISED 5/30/08)

12/10/2012
Date

**NOTICE OF PROPOSED CABLE, CONDUIT AND/OR POLE LINE ACTIVITY
IN, UNDER, ACROSS OR ALONG ROADS, STREETS, HIGHWAYS AND DRAINAGE DITCHES
IN FORT BEND COUNTY**

APPLICANT'S JOB NO. 1112-527
 PERMIT No. 84259 PCT. No. 3
 BOND No. 103827669

Formal notice is hereby given that _____
 proposes to lay, construct, maintain and/or repair cable, conduit and/or pole line, in, under,
 across, or along roads, streets, highways and drainage ditches in Fort Bend County, as follows:

In, Under, or Across Roads and/or Drainage Ditches

Road or Ditch Name	Distance & Direction From Nearest Intersection	Length of Crossing	Type of Construction Bored: Jacked: Driven: Cased

Along Roads and/or Drainage Ditches

Road or Ditch Name	Distance & Direction From Nearest Intersection	To Distance
GREENBUSCH	278 FT (SW) OF WESTHEIMER PKWY	586 FT (NE) OF WILLOW FORK PL. : TOTAL DIST. ~4465

General Description

PROPOSE TO SET (6) UTILITY POLES ALONG (SE) ROW OF
 GREENBUSCH RD BTWN WESTHEIMER PKWY AND WILLOW FORK PL.

The Location and description of the proposed installation and appurtenances is more fully shown on the attached detail drawings. The laying, construction, maintenance and/or repair of the proposed installation shall be subject to "A Revised Order Regulating the Laying, Construction, Maintenance and/or Repair of Cables, Conduits, and/or Pole Lines, In, Under, Across, or Along Roads, Streets, Highways and Drainage Ditches in Fort Bend County, Texas, Under the Jurisdiction of the Commissioners Court of Fort Bend County, Texas," as passed by Commissioners Court of Fort Bend County, Texas, dated the 3rd. day of August, 1987, recorded in Volume 639 of the Minutes of the Commissioners Court of Fort Bend County, Texas.

Written notices are required: 1) 48 hours in advance of start of construction and
 2) when construction is complete and ready for final inspection.

Mail to: Permit Administrator/Fort Bend County Engineering
 P.O. Box 1449, Rosenberg, TX 77471.

Violation of requirements shall constitute grounds for job shut down.

COMPANY NAME: PHONOSCOPE ENT. GROUP LLC
 AGENT and/or OWNER

(Signature)
 NAME & TITLE HARRELL TAYLOR/AUTOCAD DRAFTER
 (Please Print)

DATE _____

ADDRESS 6105 WESTLINE DR.

(Street/P.O. Box)
HOUSTON TX 77036
 City State Zip

TELEPHONE NO: (713) 272-4600
 (accessible 24 hrs/day, 7 days/week)

**Does project
 comply with Fort
 Bend County
 Outdoor Lighting
 Ordinance?**

Yes ()

No ()

**NOTICE OF PROPOSED CABLE, CONDUIT AND/OR POLE LINE ACTIVITY
IN, UNDER, ACROSS OR ALONG ROADS, STREETS, HIGHWAYS AND DRAINAGE DITCHES
IN FORT BEND COUNTY**

APPLICANT'S JOB NO. 1112-527
 PERMIT No. _____ PCT. No. _____
 BOND No. _____

Formal notice is hereby given that _____
 proposes to lay, construct, maintain and/or repair cable, conduit and/or pole line, in, under,
 across, or along roads, streets, highways and drainage ditches in Fort Bend County, as follows:

In, Under, or Across Roads and/or Drainage Ditches

Road or Ditch Name	Distance & Direction From : Nearest Intersection	Length of : Crossing	Type of Construction Bored: Jacked: Driven: Cased
GASTON	798ft (SE) FROM C/L OF GREENBUSCH RD	130 ft	X

Along Roads and/or Drainage Ditches

Road or Ditch Name	Distance & Direction From : Nearest Intersection	To : 	Distance :
GASTON	798ft (SE) FROM C/L OF GREENBUSCH RD	EX. UTILITY POLE (NEW)	129

General Description

PROPOSE TO BORE AND INSTALL 130ft OF CONDUIT & FOC CROSSING GASTON AND 129ft IN THE (NE) ROW OF GASTON RD


The Location and description of the proposed installation and appurtenances is more fully shown on the attached detail drawings. The laying, construction, maintenance and/or repair of the proposed installation shall be subject to "A Revised Order Regulating the Laying, Construction, Maintenance and/or Repair of Cables, Conduits, and/or Pole Lines, In, Under, Across, or Along Roads, Streets, Highways and Drainage Ditches in Fort Bend County, Texas, Under the Jurisdiction of the Commissioners Court of Fort Bend County, Texas," as passed by Commissioners Court of Fort Bend County, Texas, dated the 3rd. day of August, 1987, recorded in Volume 639 of the Minutes of the Commissioners Court of Fort Bend County, Texas.

Written notices are required: 1) 48 hours in advance of start of construction and
 2) when construction is complete and ready for final inspection.

Mail to: Permit Administrator/Fort Bend County Engineering
 P.O. Box 1449, Rosenberg, TX 77471.

Violation of requirements shall constitute grounds for job shut down.

COMPANY NAME: PHONOSCOPE ENT. GROUP LLC.
 AGENT and/or OWNER

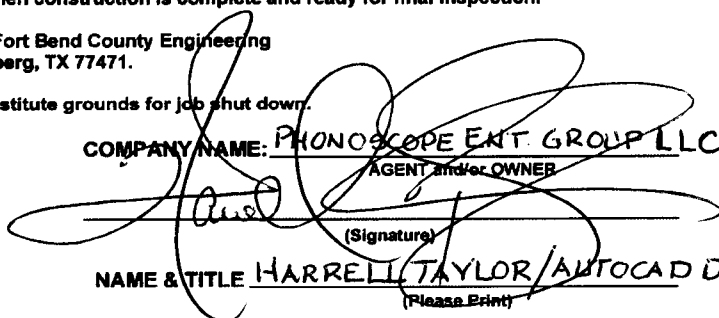
 (Signature)
 NAME & TITLE HARRELL TAYLOR/AUTOCAD DRAFTER
 (Please Print)

DATE _____

ADDRESS 6105 WESTLINE DR.
 (Street/P.O. Box)


HOUSTON TX 77036
 City State Zip

TELEPHONE NO: (713) 272-4600
 (accessible 24 hrs/day, 7 days/week)

**Does project
comply with Fort
Bend County
Outdoor Lighting
Ordinance?**

Yes ()

No ()

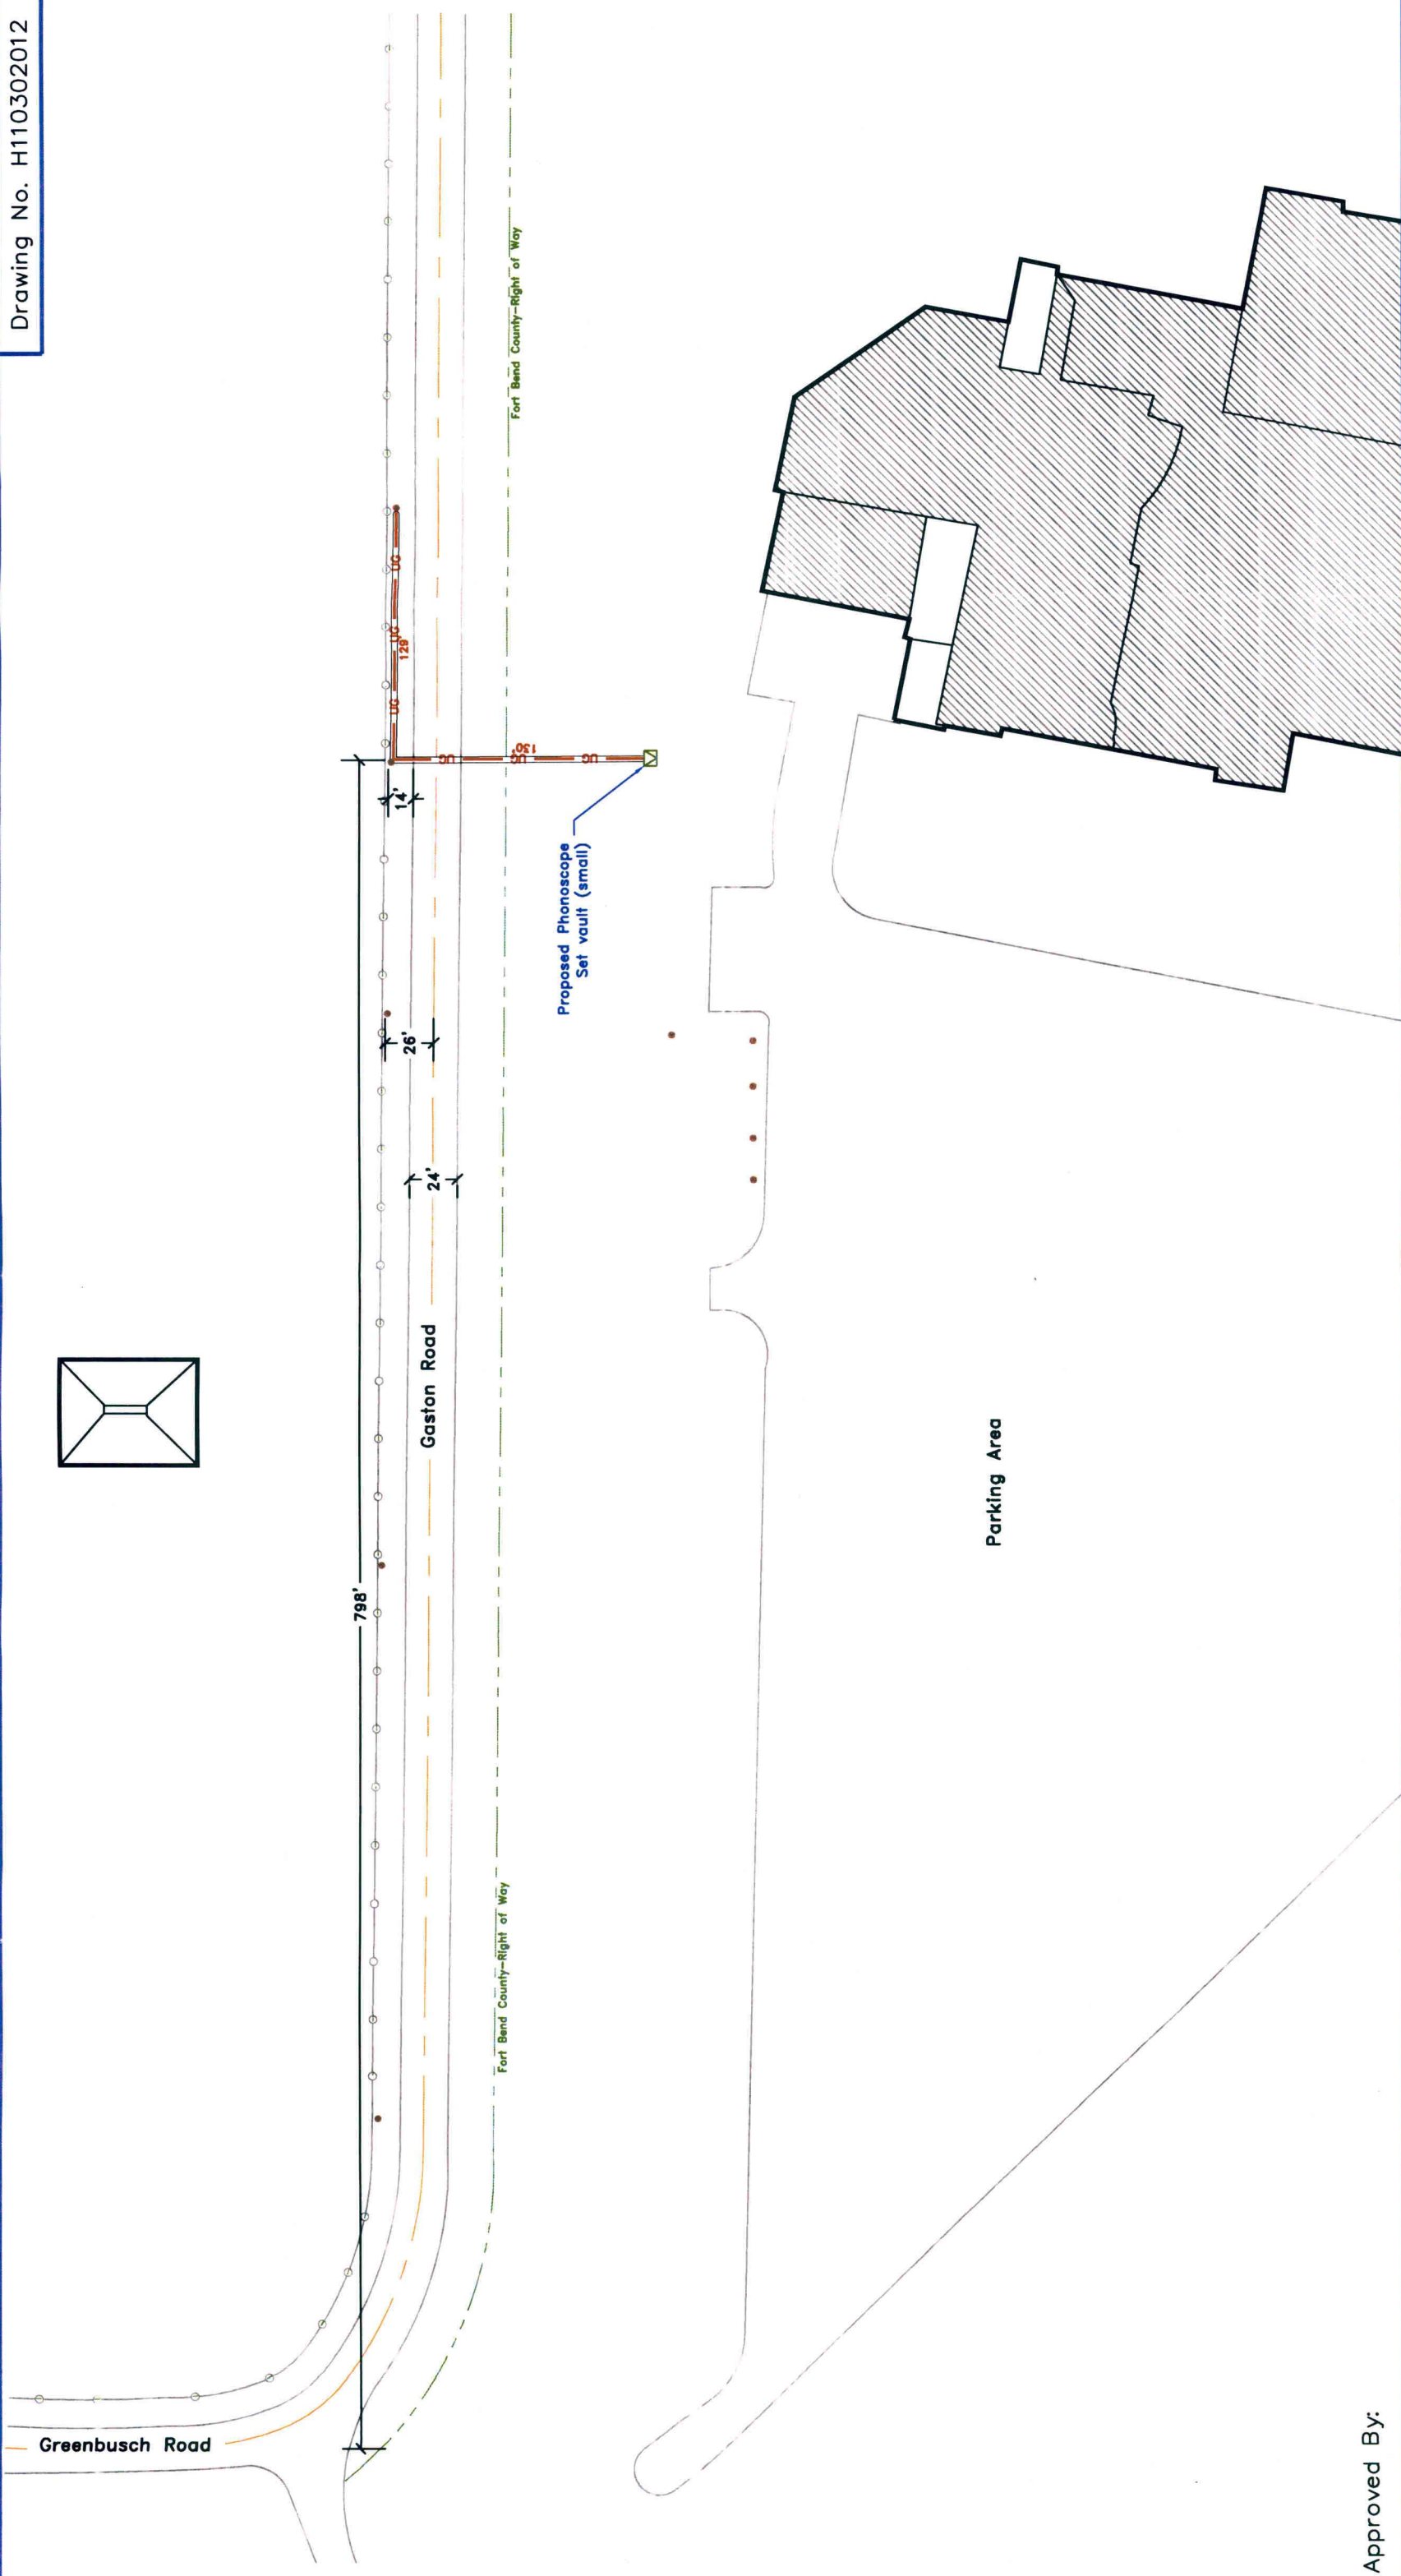

Approved By:

Symbol	Description	Revisions
	(3) 1" PVC conduit encasing Fiber Optic Cable Underground @ a min depth of 60" below existing grade	
	Existing Utility Pole	
	Proposed Phonoscope Set vault (small)	
		Confidential and Proprietary

Revisions



Key Map: 484 U

Drawn By:
Harrell Taylor

Scale:
N.T.S.

Date: 11/30/2012



PHONOSCOPE

JOB# 1112-527

Notice of Proposed Utility Installation


Proposed Underground Wireline Crossing

Site Plan—UG ROW & Xing of Gaston Rd

1 of 3

W. O.# 58778

- 1) Surface to be restored to its original condition in compliance with Fort Bend County Standards.
- 2) Traffic Control Plan (1-1c) standards to be used as noted on page 3.

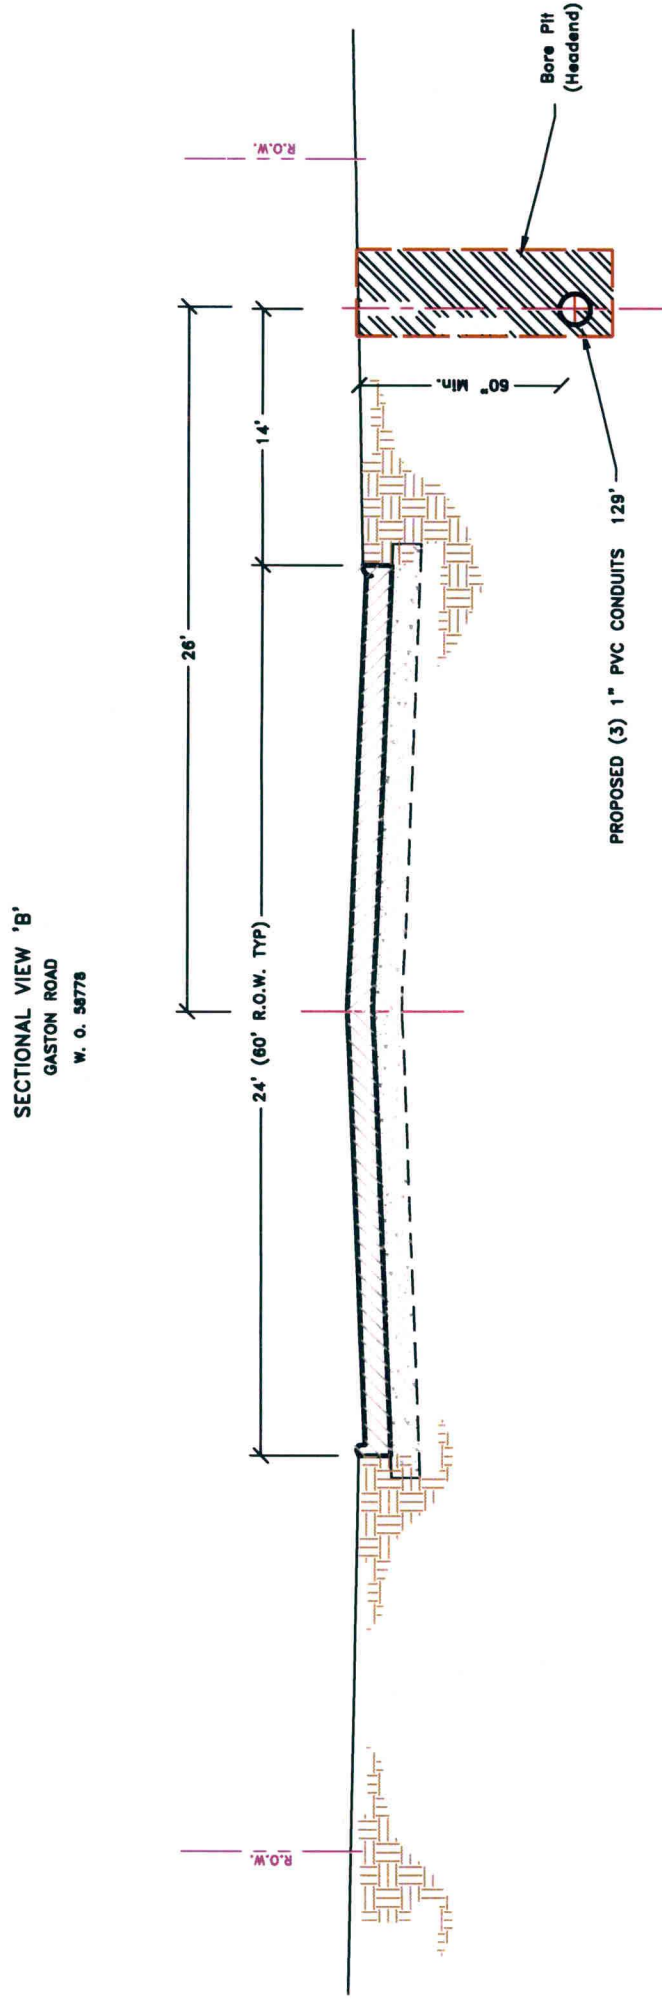

Approved By:

Symbol	Description	Revisions
— ug —	(3) 1" PVC conduits encasing fiber optic cable @ a depth of 60" below existing grade	
		Confidential and Proprietary


	Drawn By: Harrell Taylor	Scale: N.T.S.	Date: 12/03/2012
			

Key Map: 484 U

PHONOSCOPE

1) Contractor will need to use parking lane or side of street for equipment, but shall not obstruct flow of traffic or close street without proper notice submitted to the Fort Bend County Engineers for review and approval.

No Traffic Obstruction

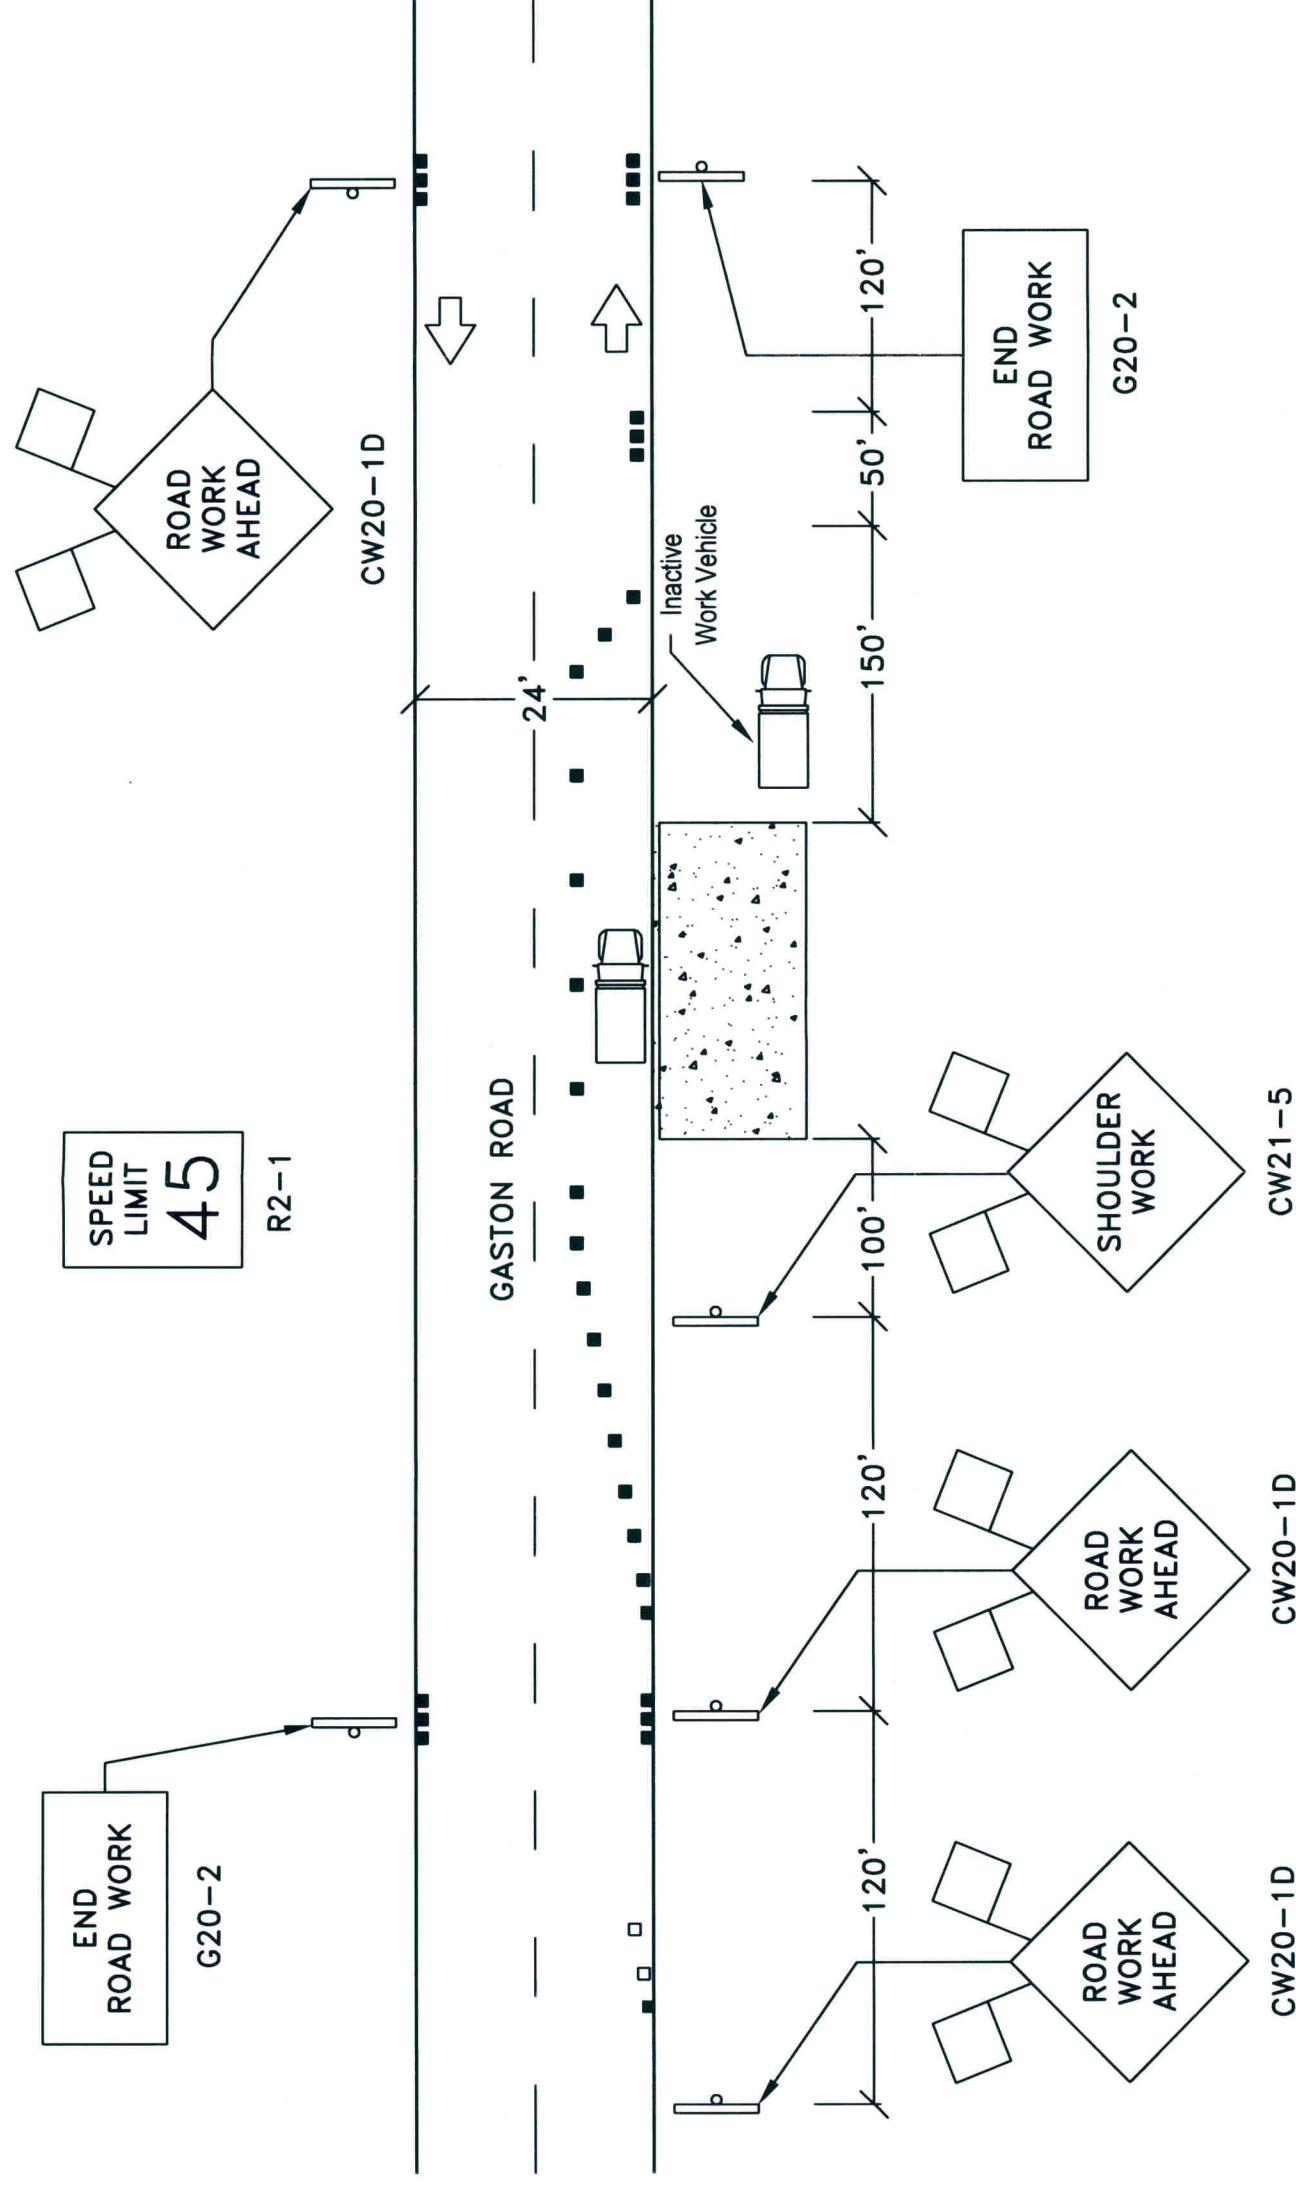

Approved By:

[illegible]

Drawn By: Harrell Taylor	Scale: N.T.S.	Date: 12/03/2012	
JOB# 1112-527			
Notice of Proposed Utility Installation			
Proposed Underground Wireline Installation			
Typical Traffic Control Plan			
3 of 3			W. O.# 58778




Approved By:

Symbol		Description	Revisions	Drawn By: Harrell Taylor	Scale: N.T.S.	Date: 12/03/2012	JOB# 1112-527
UG		(3) 1" PVC conduit encasing Fiber Optic Cable Underground @ a min depth of 60" below existing grade					
●		Existing Utility Pole					
							Notice of Proposed Utility Installation
				Proposed Underground Wireline Crossing			
				Site Plan-UG ROW of Greenbusch Rd			1 of 4
				W. O.# 58777			

MATCH LINE "A"

MATCH LINE "B"

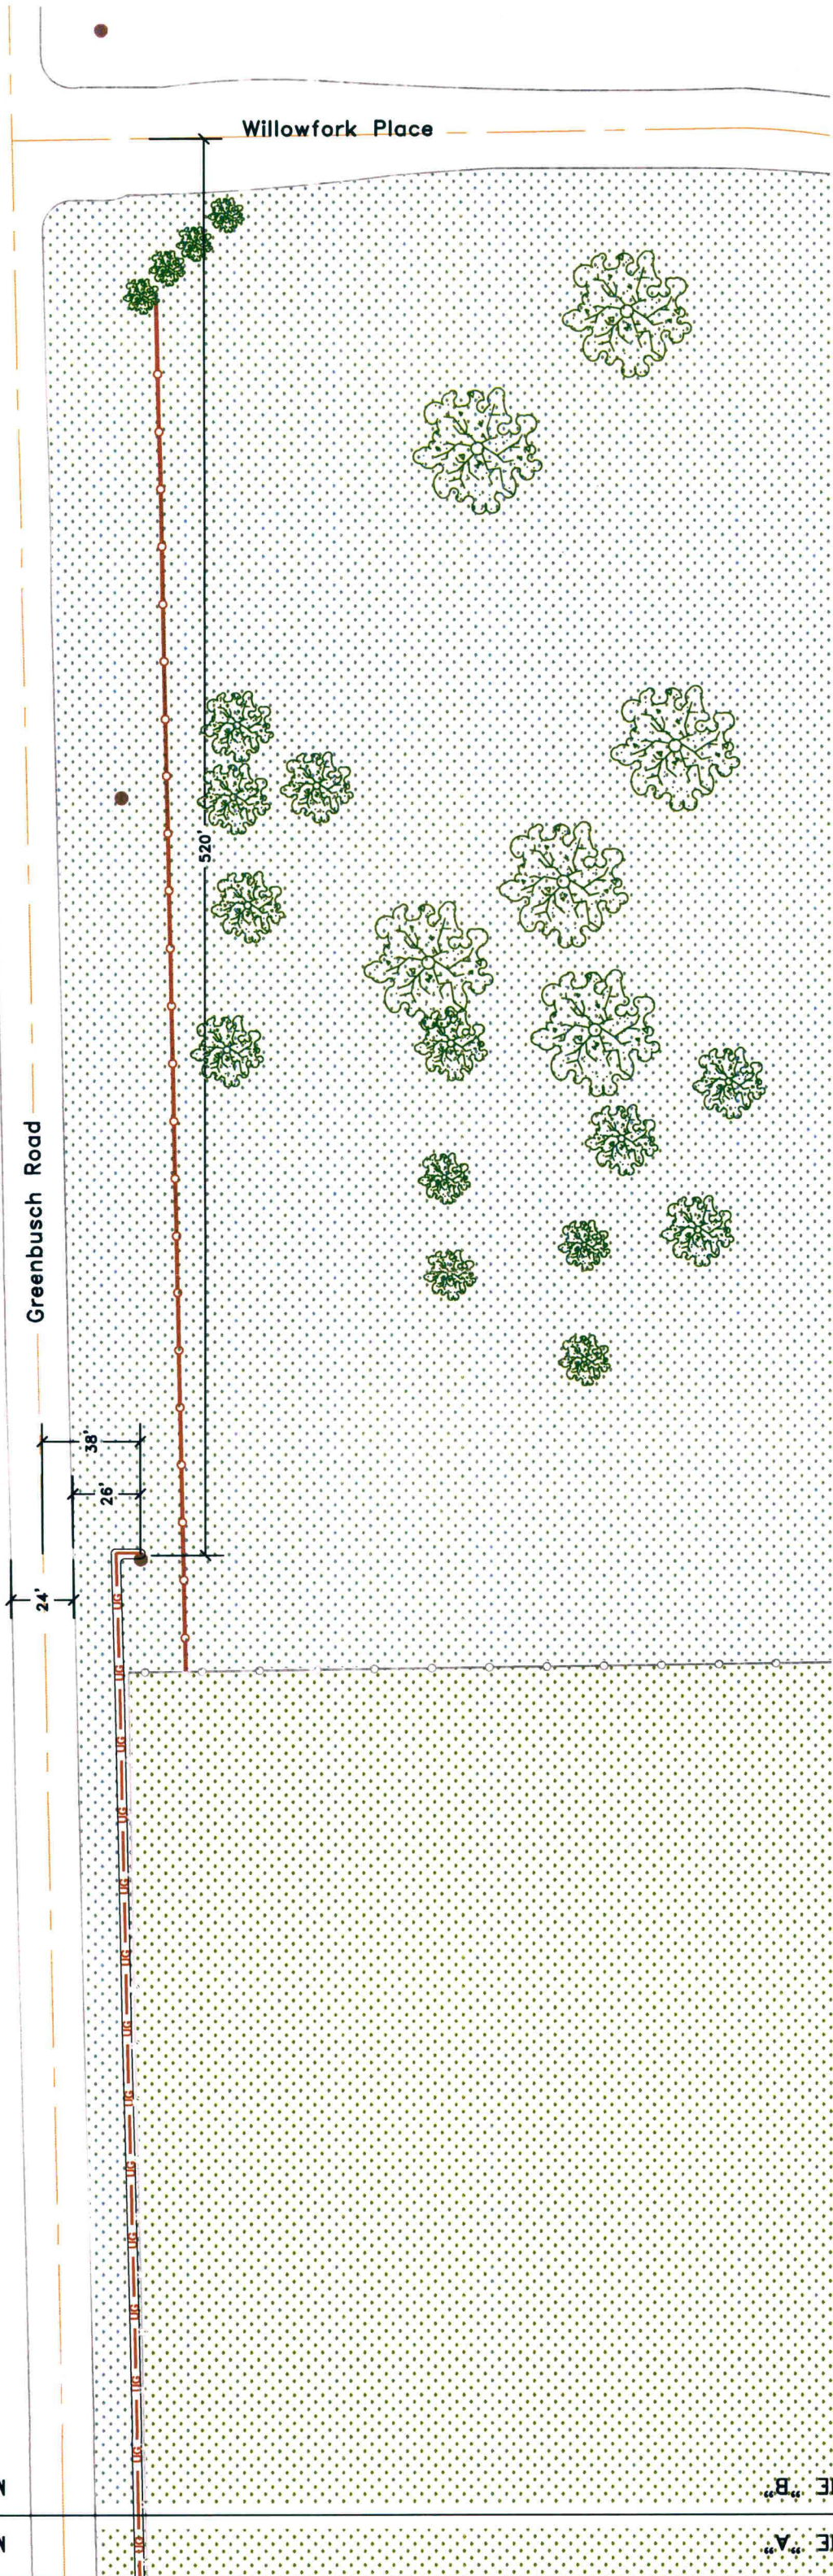

Approved By:

Symbol	Description	Revisions
	(3) 1" PVC conduit encasing Fiber Optic Cable Underground @ a min depth of 60" below existing grade	
	Existing Utility Pole	
		Confidential and Proprietary

Drawn By:
Harrell Taylor

Scale:
N.T.S.

Date:
11/30/2012

Key Map: 484 U

PHONOSCOPE

JOB# 1112-527

Notice of Proposed Utility Installation

Proposed Underground Wireline Crossing

Site Plan-UG ROW of Greenbusch Rd

2 of 4

W. O.# 58777

1) Contractor will need to use parking lane or side of street for equipment, but shall not obstruct flow of traffic or close street without proper notice submitted to the Fort Bend County Engineers for review and approval.

The diagram illustrates a two-lane road construction layout for Greenbusch Road. Key elements include:

- Speed Limit Sign (R2-1):** A rectangular sign with a black border, white background, and black text reading "SPEED LIMIT 45".
- Road Work Ahead Sign (CW20-1D):** A diamond-shaped sign with a black border, white background, and black text reading "ROAD WORK AHEAD".
- End Road Work Sign (G20-2):** A rectangular sign with a black border, white background, and black text reading "END ROAD WORK".
- Shoolder Work Sign (CW21-5):** A diamond-shaped sign with a black border, white background, and black text reading "SHOULDER WORK".
- Work Area:** A rectangular area with a stippled pattern, labeled "TOTAL WORK AREA 1160 Ft".
- Inactive Work Vehicle:** A vehicle icon positioned within the work area.
- Dimensions:** Distances are marked along the road: 120' between signs, 100' between the shoulder work sign and the work area, and 120' between the end road work sign and the work area.
- Labels:** "GREENBUSCH ROAD" is written vertically along the road, and "CW20-1D" is written near the road work ahead sign.


Approved By:

[illegible]

Date: 12/03/2012



W. O.# 58777

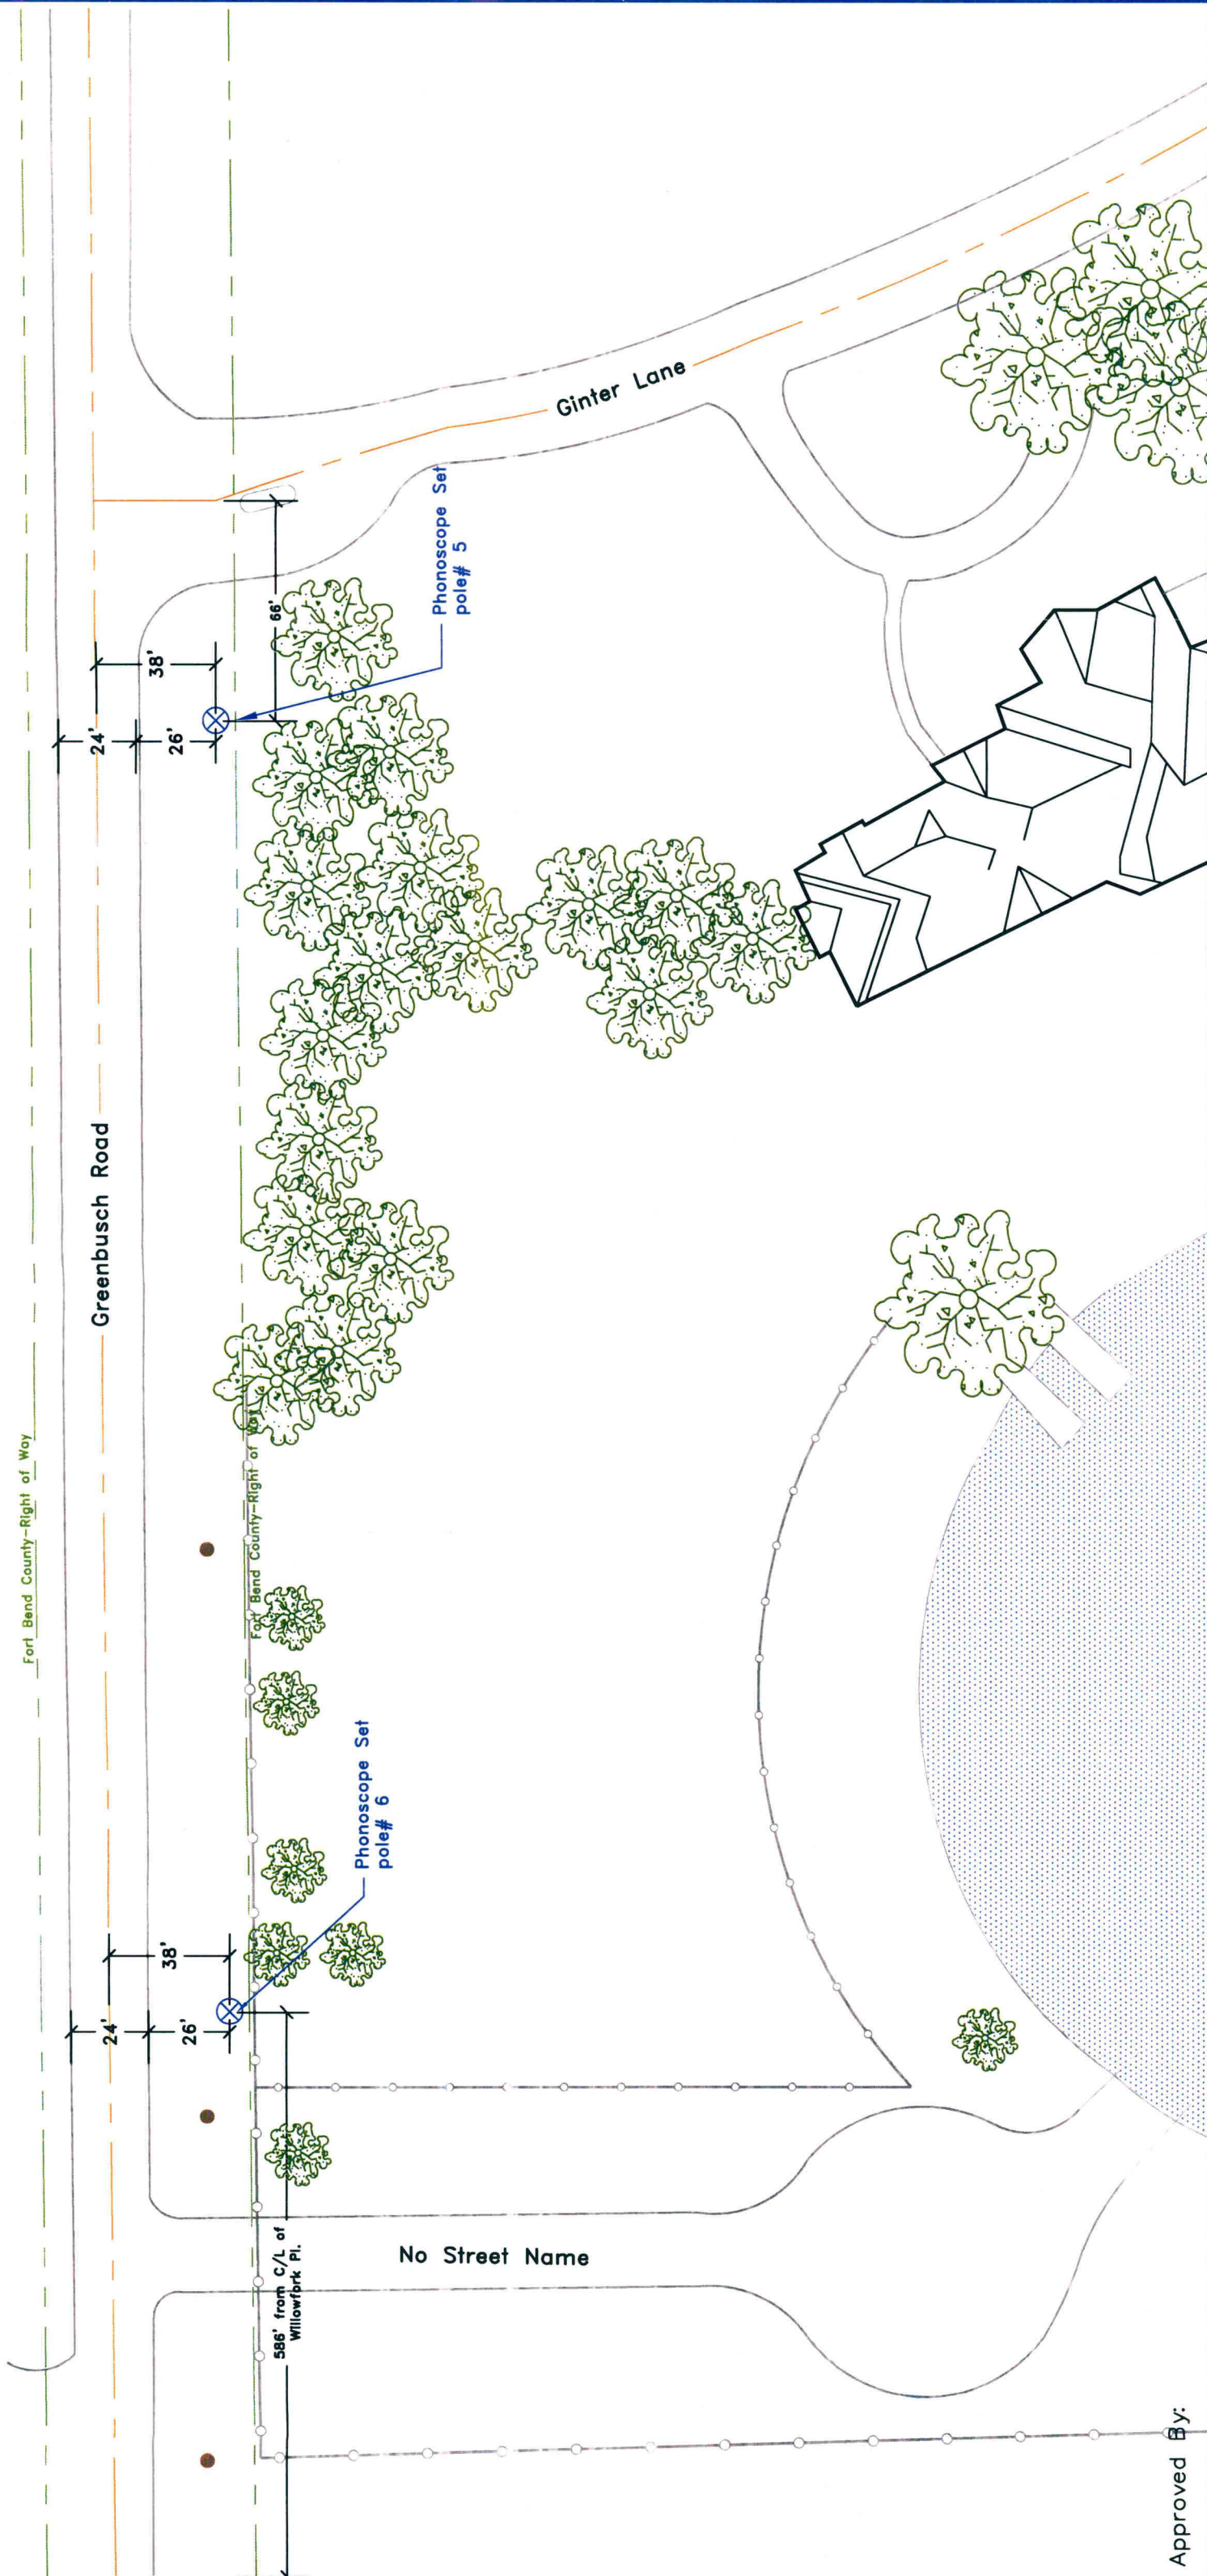

Approved By:


Symbol	Description	Revisions
⊗	Phonscope Set Pole	
●	Existing Utility Pole	
		Confidential and Proprietary

Drawn By: Harrell Taylor	Scale: N.T.S.	Date: 11/27/2012
-----------------------------	------------------	---------------------




Key Map: 484 V

JOB# 1112-527
Notice of Proposed Utility Installation
Proposed Setting of (6) Utility Poles
Site Plan- Set (2) poles along Greenbusch Rd
1 of 7
W. O.# 58776

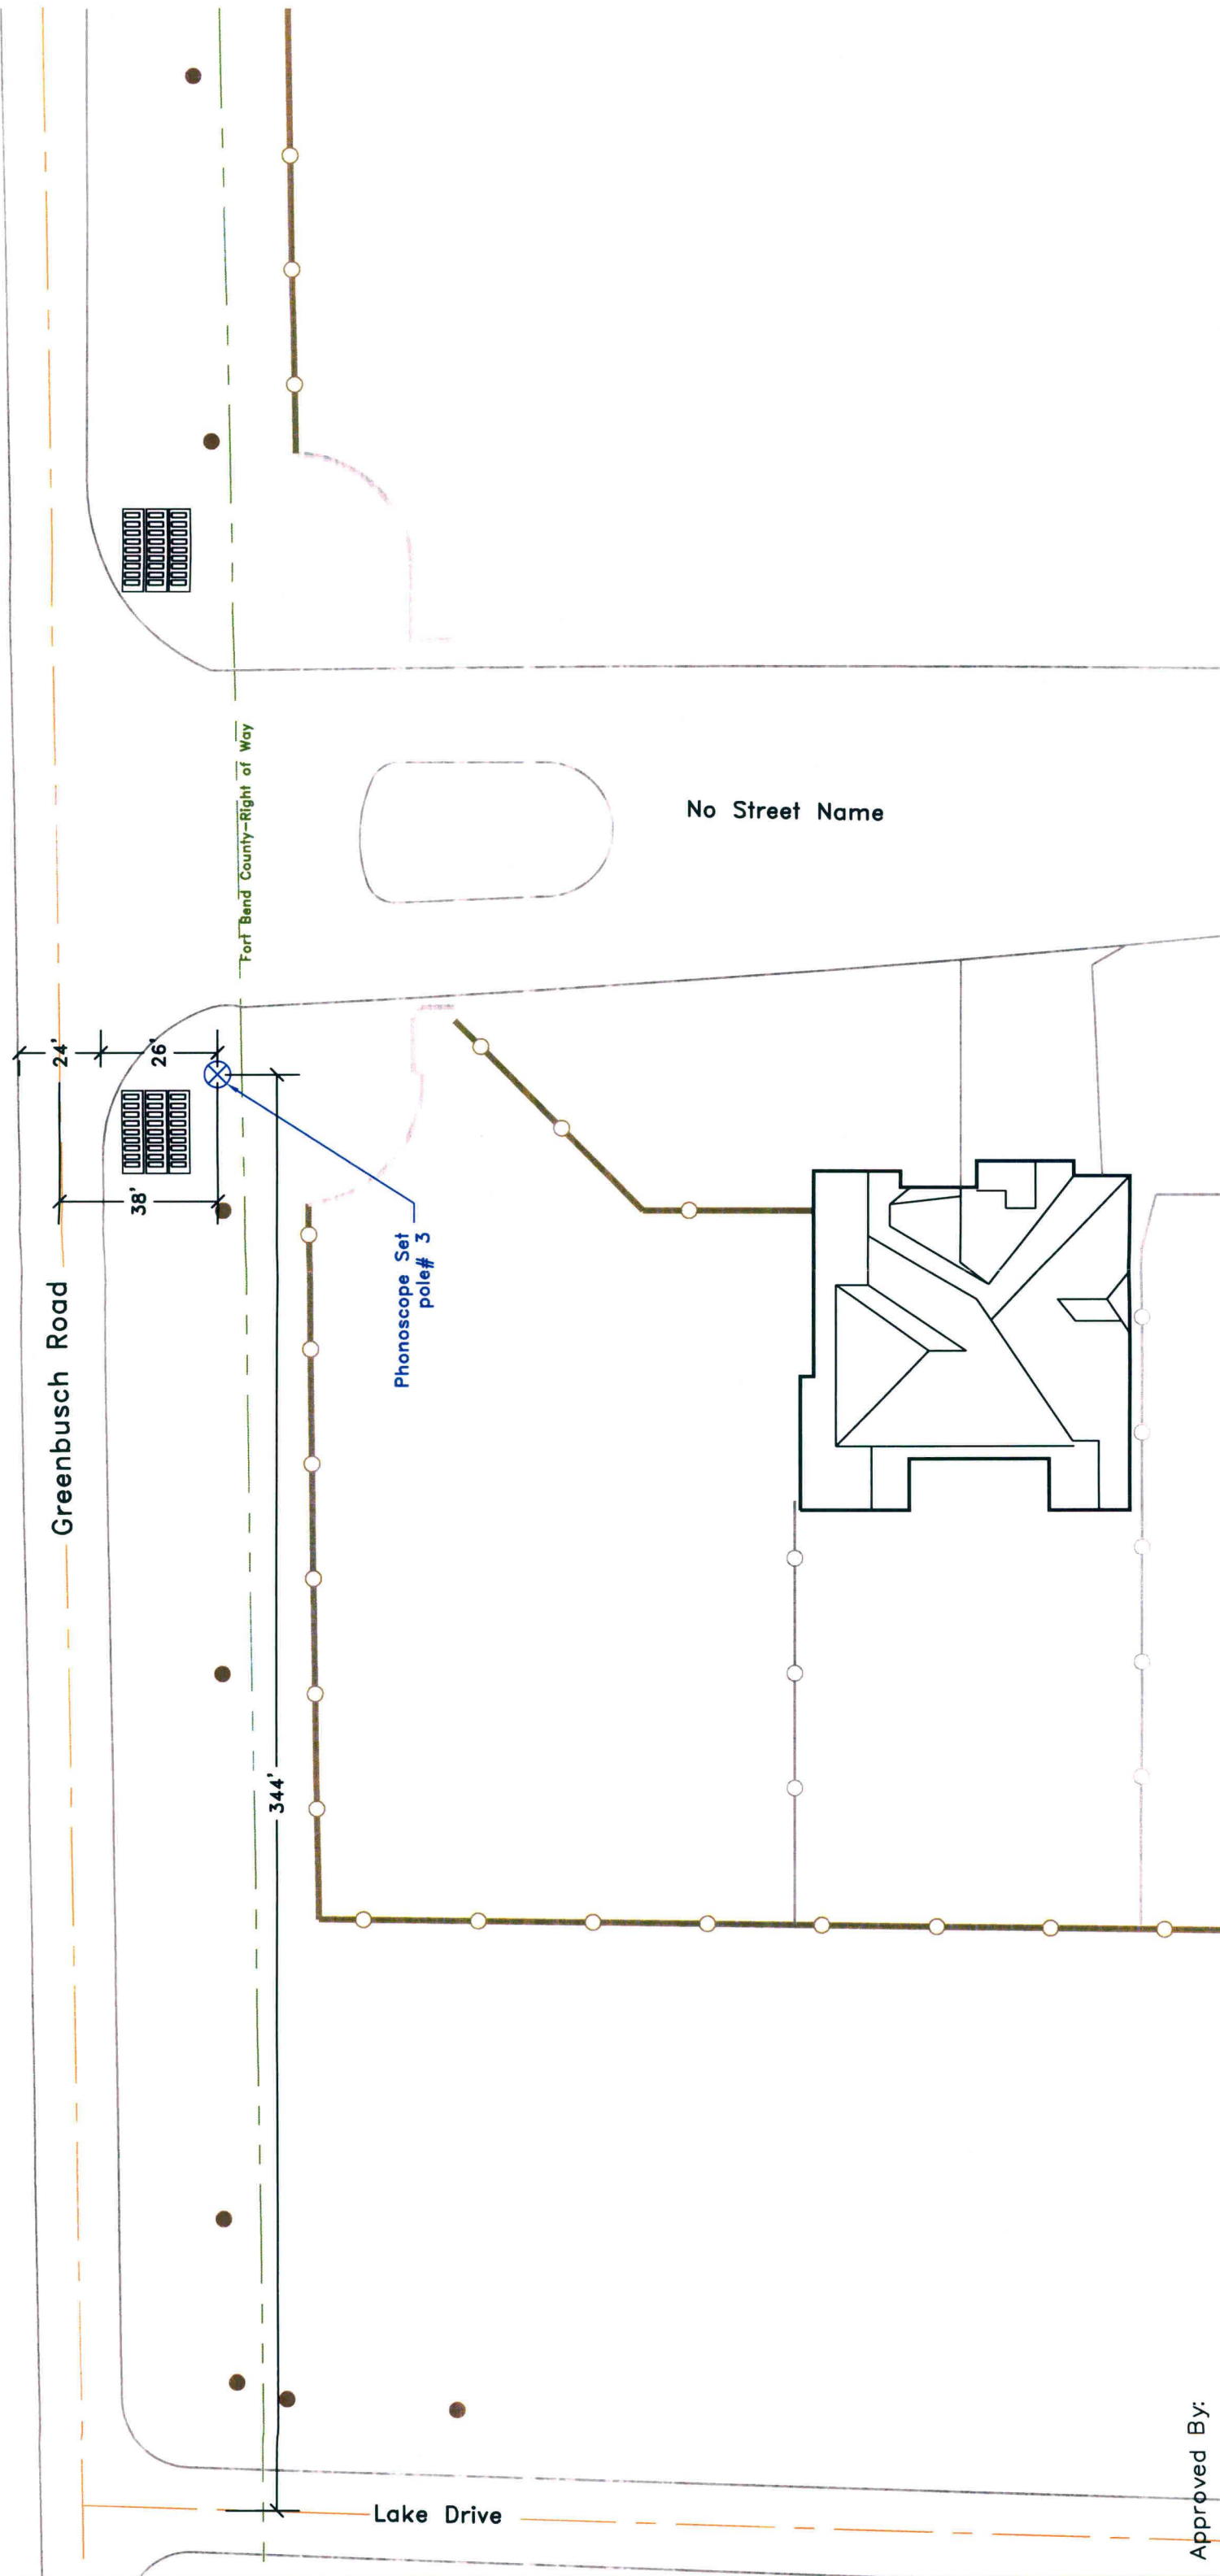

Approved By:

[illegible]

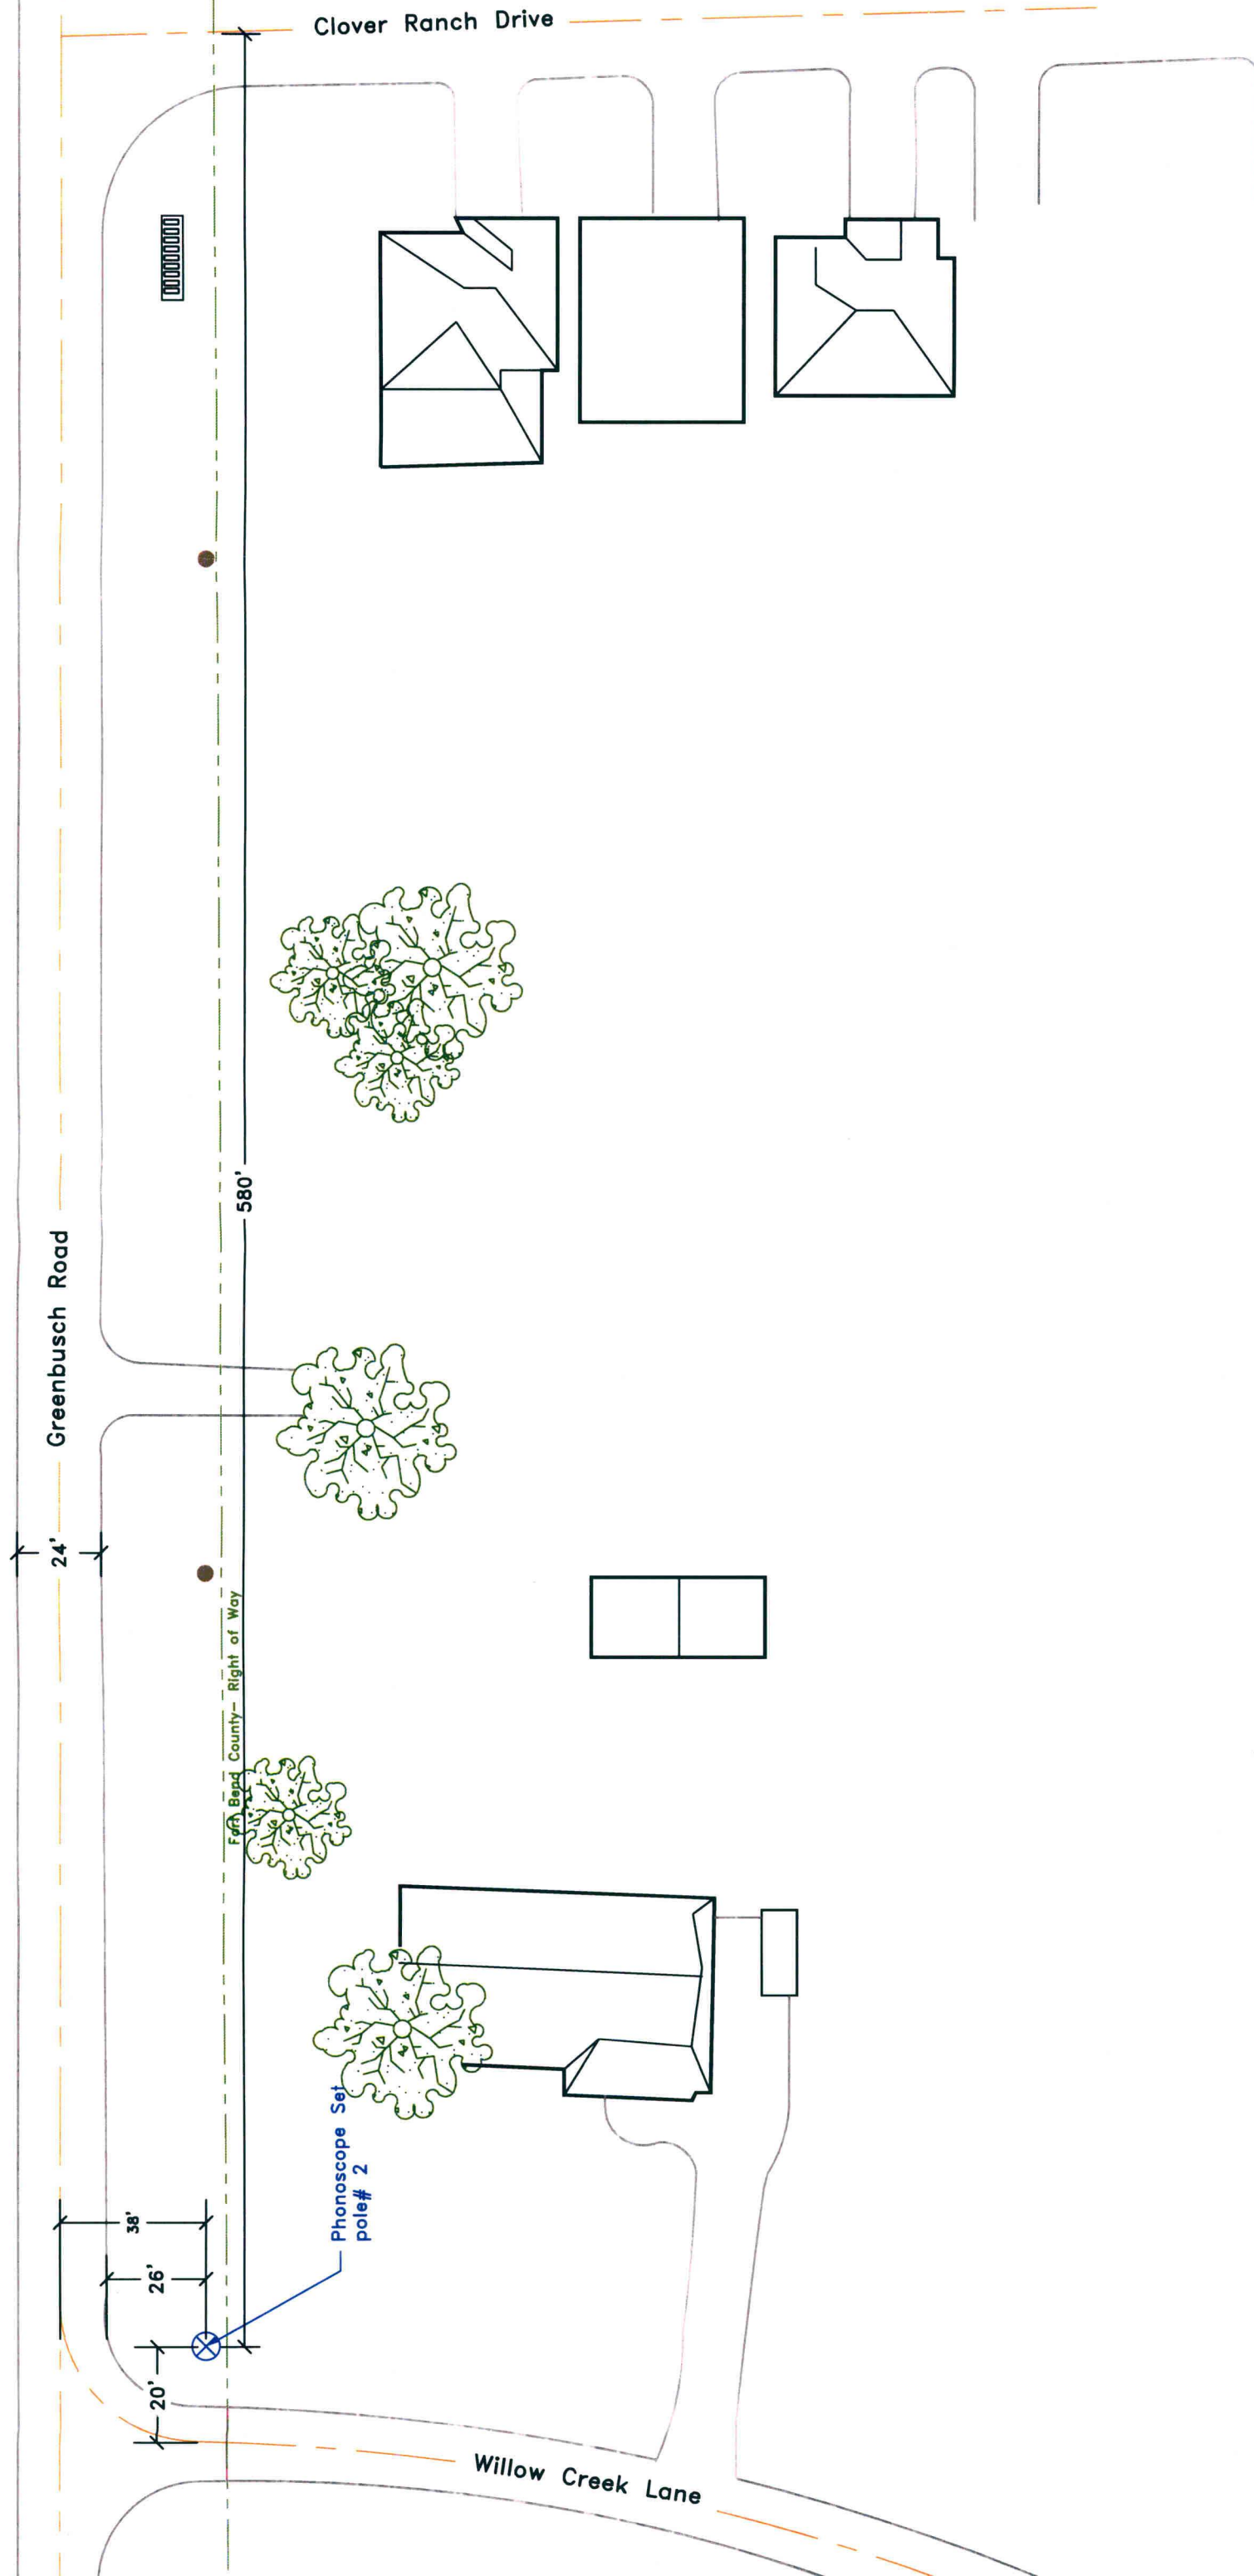

Approved By:

Symbol	Description	Revisions
⊗	Phonoscope Set Pole	
●	Existing Utility Pole	
		Confidential and Proprietary



Key Map: 484 R

Drawn By:
Harrell Taylor

Scale:
N.T.S.

Date: 11/28/2012



PHONOSCOPE

JOB# 1112-527

Notice of Proposed Utility Installation

Proposed Setting of (6) Utility Poles

Site Plan- Set (1) Pole along Greenbusch Rd

4 of 7

W. O. # 58776

Saddlespur Lane

Greenbusch Road

Westheimer Parkway

Set Bend County- Right of Way

Phonoscope Set pole# 1

Parking Area

Parking Area

Parking Area

Approved By:

Symbol	Description
⊗	Phonoscope Set Pole
●	Existing Utility Pole

Revisions

Drawn By: Harrell Taylor

Scale: N.T.S.

Date: 11/28/2012

JOB# 1112-527



PHONOSCOPE

Notice of Proposed Utility Installation

Proposed Setting of (6) Utility Poles

Site Plan- Set (1) Pole along Greenbusch Rd

5 of 7

W. O. # 58776




Key Map: 484 R

Confidential and Proprietary

General Notes:

- 1) Surface to be restored to its original condition in compliance with Fort Bend County Standards.
- 2) Traffic Control Plan (1-1c) standards to be used as noted on page 7 (If Necessary).
- 3) Contractor shall provide and install Traffic Control Devices in conformance with Part VI of the Texas Manual on Uniform Traffic Control Devices. (TMUTCD- Latest Edition with Revisions) during construction.
- 4) No Lanes shall be blocked during construction.

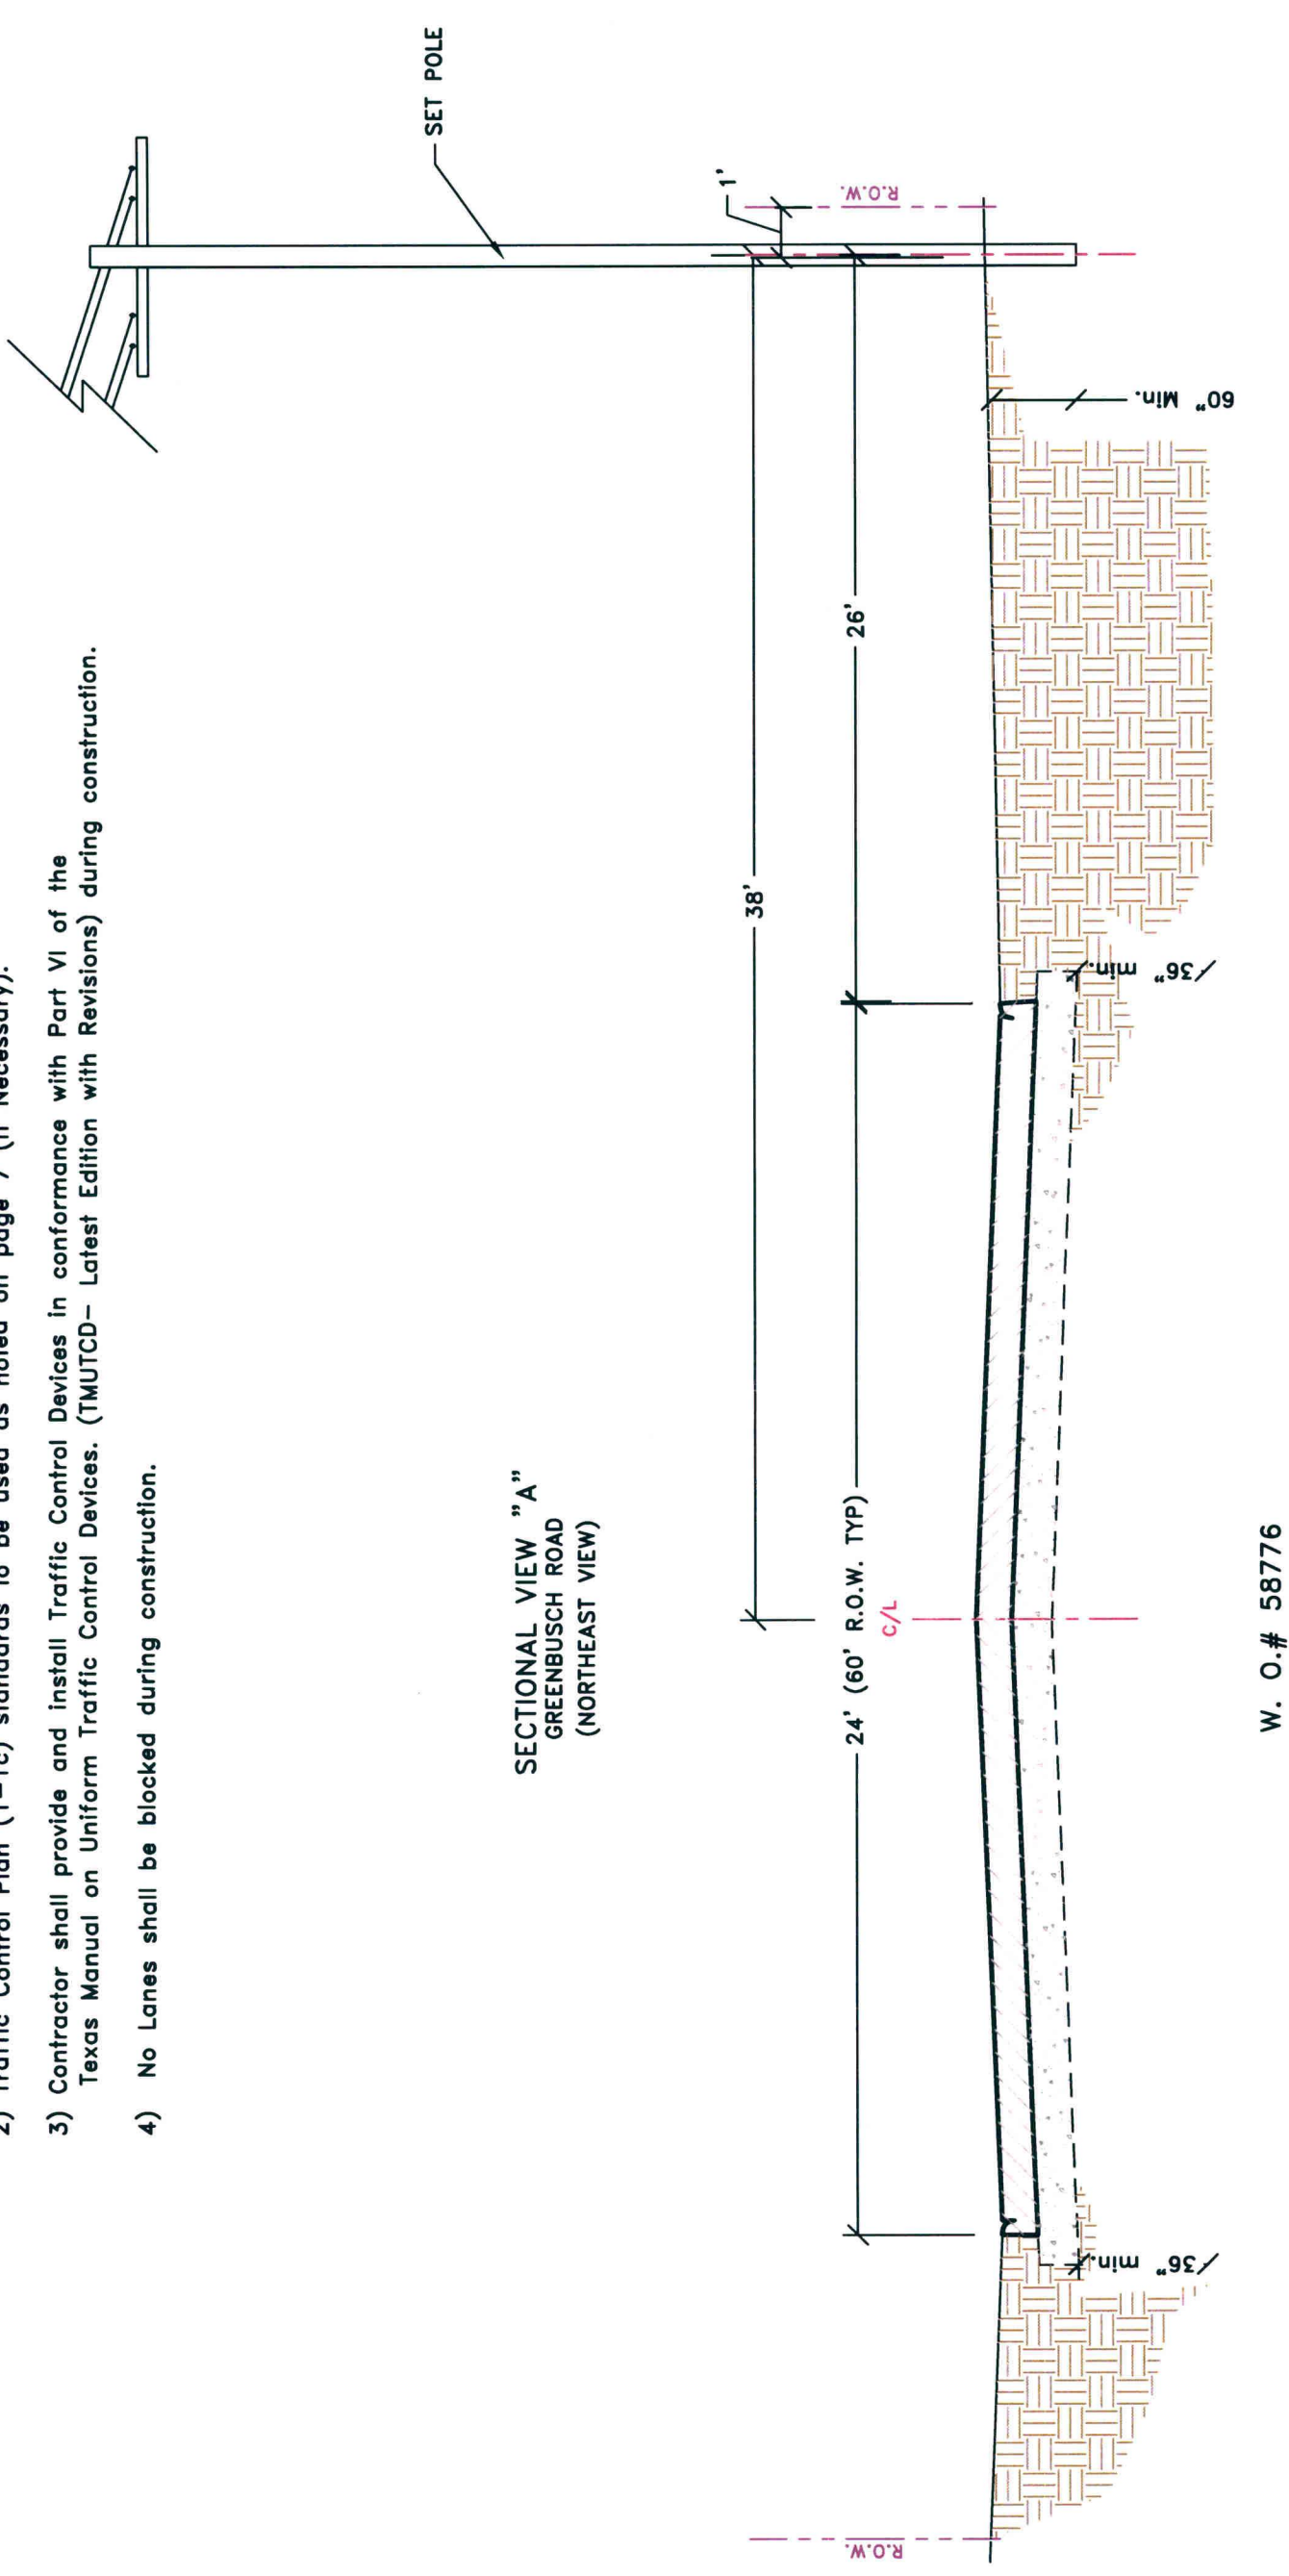

Approved By:

[illegible]

Drawn By: Harrell Taylor	Scale: N.T.S.	Date: 12/03/2012
-----------------------------	------------------	---------------------



PHONOSCOPE




Key Map: 484 R, & V

JOB# 1112-527

Notice of Proposed Utility Installation
Proposed Setting of Utility Poles (6)
Cross Section/ Profile—Along Greenbush
6 of 7
W. O. #

General Notes:

- 1) Contractor will need to use parking lane or side of street for equipment, but shall not obstruct flow of traffic or close street without proper notice submitted to the Fort Bend County Engineers for review and approval.

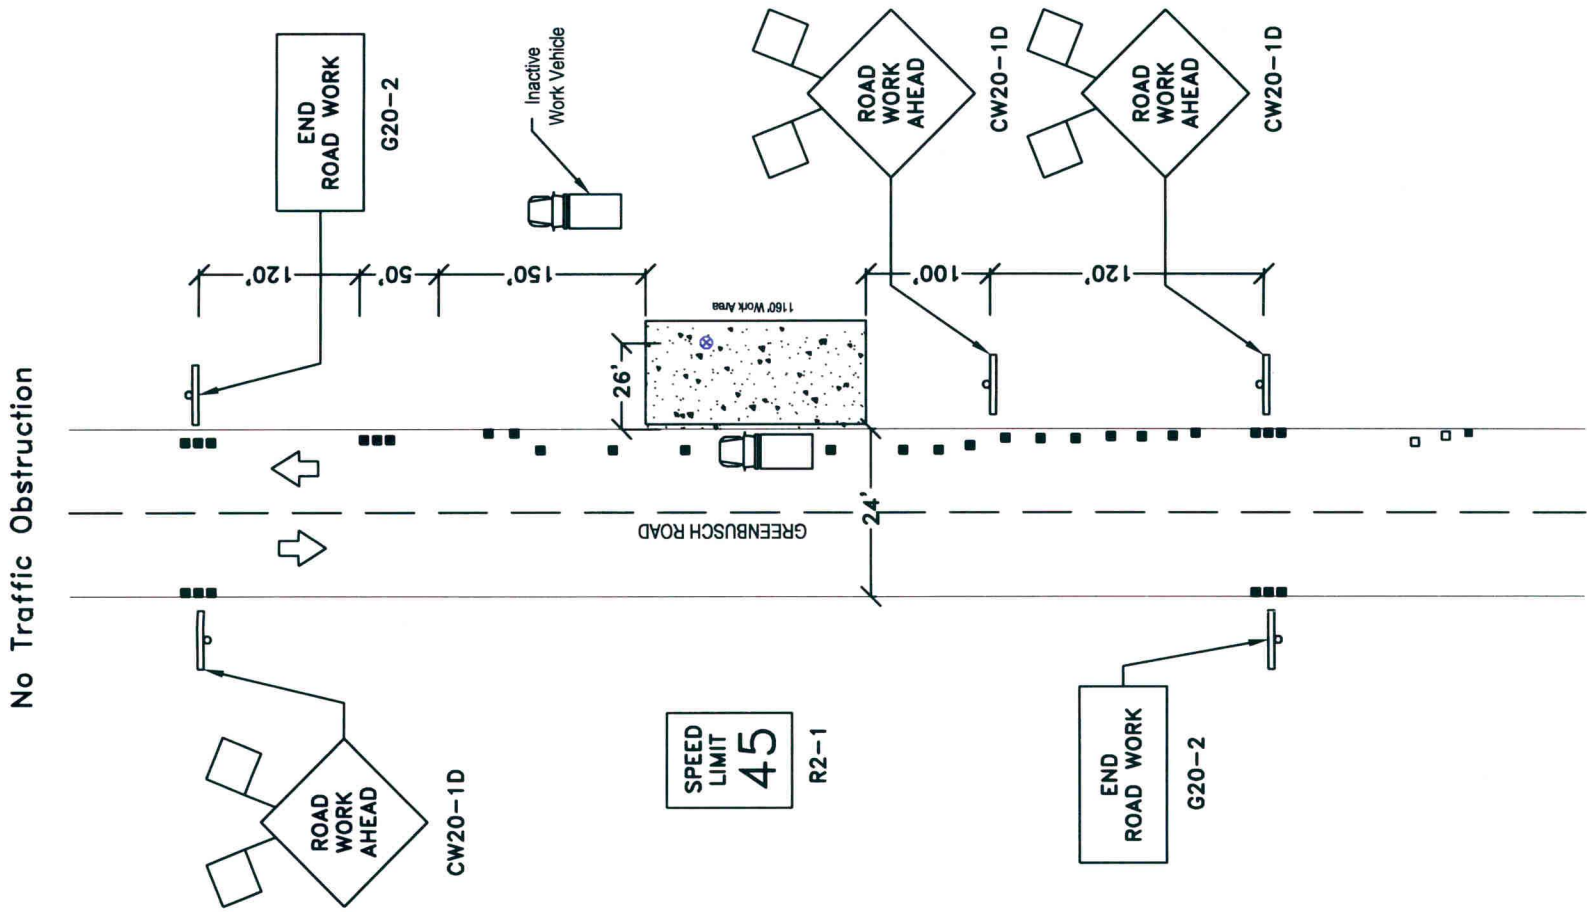

Approved By:

Symbol	Description	Revisions
⊗	Phonoscope Set Pole	Revised by: H. Taylor 10/10/2008
		Confidential and Proprietary

Drawn By: Harrell Taylor

Scale: N.T.S.

Date: 12/03/2012

Key Map: 484 R, V

PHONOSCOPE