

REVIEW BY FORT BEND COUNTY COMMISSIONERS COURT

On this 27th day of October, 2015, Commissioners Court came on to be heard and reviewed the accompanying notice of Phonoscope Light Wave, Inc Job Location 27602 Westridge Creek Ln under Tamarron Pkwy, Katy, TX 77494 Date 10/15/2015 Bond No. 103827669, Permit No. 2015-3618 to make use of certain Fort Bend County property subject to, "A Revised Order Regulating the Laying, Construction, Maintenance, and Repair of Buried Cables, Conduits, and Pole Lines, In, Under, Across or Along Roads, Streets, Highways, and Drainage Ditches in Fort Bend County, Texas, Under the Jurisdiction of the Commissioners Court of Fort Bend County, Texas," as passed by the Commissioners Court of Fort Bend County, Texas the 3rd day of August, 1987, recorded in Volume _____ of the Minutes of the Commissioners Court of Fort Bend County, Texas, to the extent that such order is not inconsistent with Article 1436a, Vernon's Texas Civil Statutes. Upon Motion of Commissioner Meyers, seconded by Commissioner Patterson, duly put and carried, it is ORDERED, ADJUDGED AND DECREED that said notice of said above purpose is hereby acknowledged by the Commissioners Court of Fort Bend County, Texas, and that said notice be placed on record according to the regulation order thereof.

Notes:


1. Evidence of review by the Commissioners Court must be kept on the job site and failure to do so constitutes grounds for job shutdown.
2. Written notices are required:
 - a. 48 hours in advance of construction start up, and
 - b. when construction is completed and ready for final inspection
 Mail notices to: Permit Administrator
 Fort Bend County Engineering
 301 Jackson Street
 Richmond, Texas 77469
 281-633-7500
3. This permit expires one (1) year from date of permit if construction has not commenced.

By: Rich J Stangle, PE, PTOE
Fort Bend County Engineer

Presented to Commissioners Court and approved.
Recorded in Volume 10-27-15
Minutes of Commissioners Court

By: N/A
Drainage District Engineer/Manager

Clerk of Commissioners Court
By: Panda Willos
Deputy

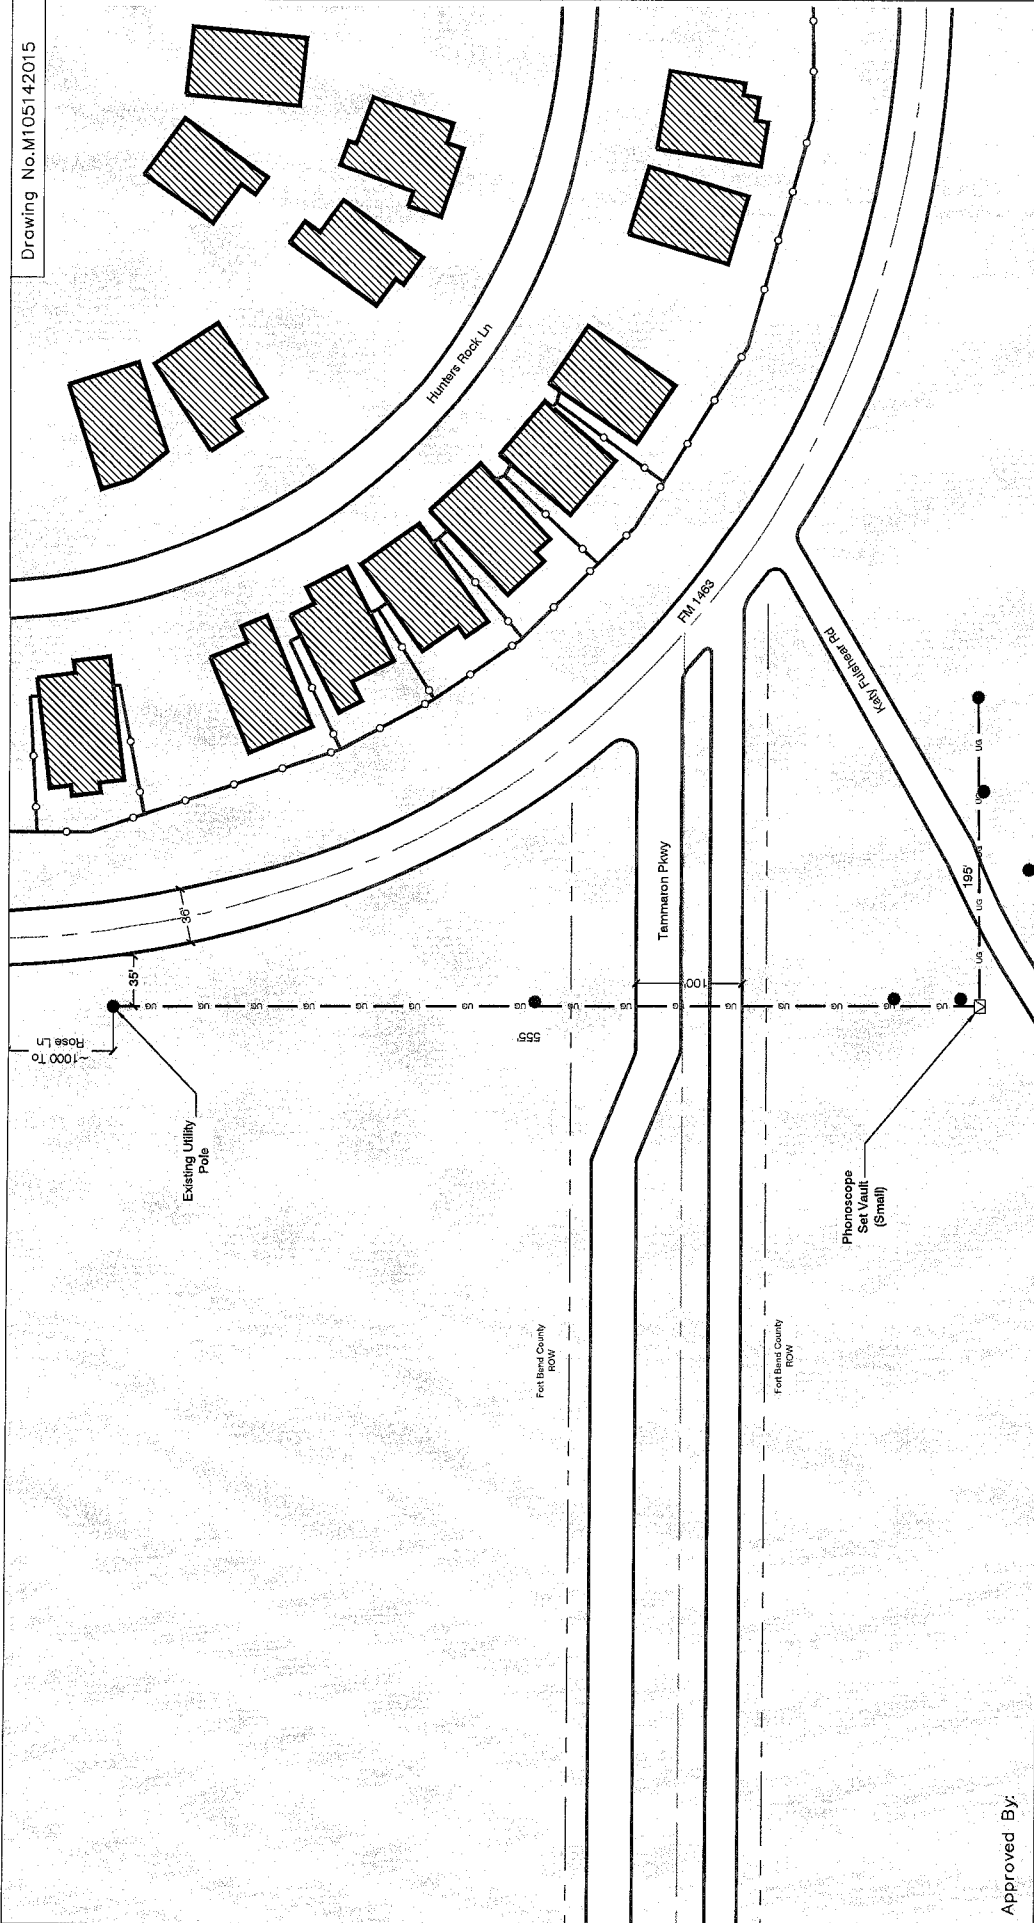

Job #0615-495

Notice Of Proposed Utility Installation

Proposed Underground Wireline Crossing

Site Plan

Page 1 of 2

W.O.#76881

Drawn By: Mohammed Al Qaysi

Scale: N.T.S.

Date: 10/14/2015

PHONOSPHERE LIGHTWAVE

Key Map # 484 S

Revisions

Symbol	Description
3 (1") PVC Conduits Encasing Fiber Optic Cable Underground	
Existing Utility Pole	
Phonoscope Set Vault (Small, 30" L * 17" W * 17" D)	


Approved By:

Symbol	Description
3 (1") PVC Conduits Encasing Fiber Optic Cable Underground	
Existing Utility Pole	
Phonoscope Set Vault (Small, 30" L * 17" W * 17" D)	

General Notes:

- 1) Surface to be restored to its original condition in compliance with Fort Bend County Standards.
- 2) Contractors shall provide and install traffic control devices in conformance with part VI of Texas manual on Uniform Traffic Control Devices (TMUTCD—Latest Edition with Revisions) during construction.
- 3) No Lanes shall be blocked 7am-9am and 3pm-6:30pm Monday thru Friday.

PROFILE SECTIONAL DETAIL Tammaron Pkwy

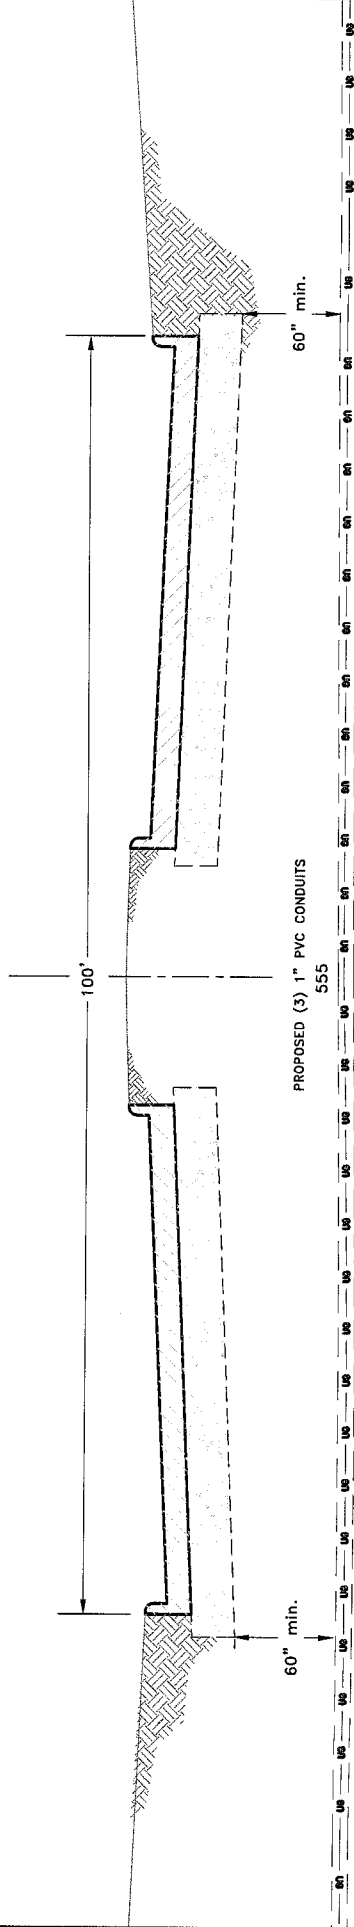

Approved By:

Symbol	Description	Revisions
(3) 1" PVC Conduit Encasing Fiber Optic Cable Underground		

Drawn By: Mohammed Al Qayati	Scale: N.T.S.	Date: 10/14/2015	
Notice Of Proposed Utility Installation Proposed Underground Wireline Crossing Profile			