

**REVIEW BY FORT BEND COUNTY COMMISSIONERS COURT**

On this 27th day of October, 2015, Commissioners Court came on to be heard and reviewed the accompanying notice of Phonoscope Light Wave, Inc Job Location 27602 Westridge Creek Lane , Katy , TX 77494 Date 10/15/2015 Bond No. 103827669, Permit No. 2015-3620 to make use of certain Fort Bend County property subject to, "A Revised Order Regulating the Laying, Construction, Maintenance, and Repair of Buried Cables, Conduits, and Pole Lines, In, Under, Across or Along Roads, Streets, Highways, and Drainage Ditches in Fort Bend County, Texas, Under the Jurisdiction of the Commissioners Court of Fort Bend County, Texas," as passed by the Commissioners Court of Fort Bend County, Texas the 3rd day of August, 1987, recorded in Volume \_\_\_\_\_ of the Minutes of the Commissioners Court of Fort Bend County, Texas, to the extent that such order is not inconsistent with Article 1436a, Vernon's Texas Civil Statutes. Upon Motion of Commissioner Meyers, seconded by Commissioner Patterson, duly put and carried, it is ORDERED, ADJUDGED AND DECREED that said notice of said above purpose is hereby acknowledged by the Commissioners Court of Fort Bend County, Texas, and that said notice be placed on record according to the regulation order thereof.

Notes:

1. Evidence of review by the Commissioners Court must be kept on the job site and failure to do so constitutes grounds for job shutdown.
2. Written notices are required:
  - a. 48 hours in advance of construction start up, and
  - b. when construction is completed and ready for final inspection
 Mail notices to: Permit Administrator  
 Fort Bend County Engineering  
 301 Jackson Street  
 Richmond, Texas 77469  
 281-633-7500
3. This permit expires one (1) year from date of permit if construction has not commenced.

By: Rich J. Strangle, PE, PTOE  
For County Engineer

Presented to Commissioners Court and approved.  
Recorded in Volume 10-27-15  
Minutes of Commissioners Court


By: N/A  
Drainage District Engineer/Manager

Clerk of Commissioners Court

By: Donda White  
Deputy



Drawing No. M107142015

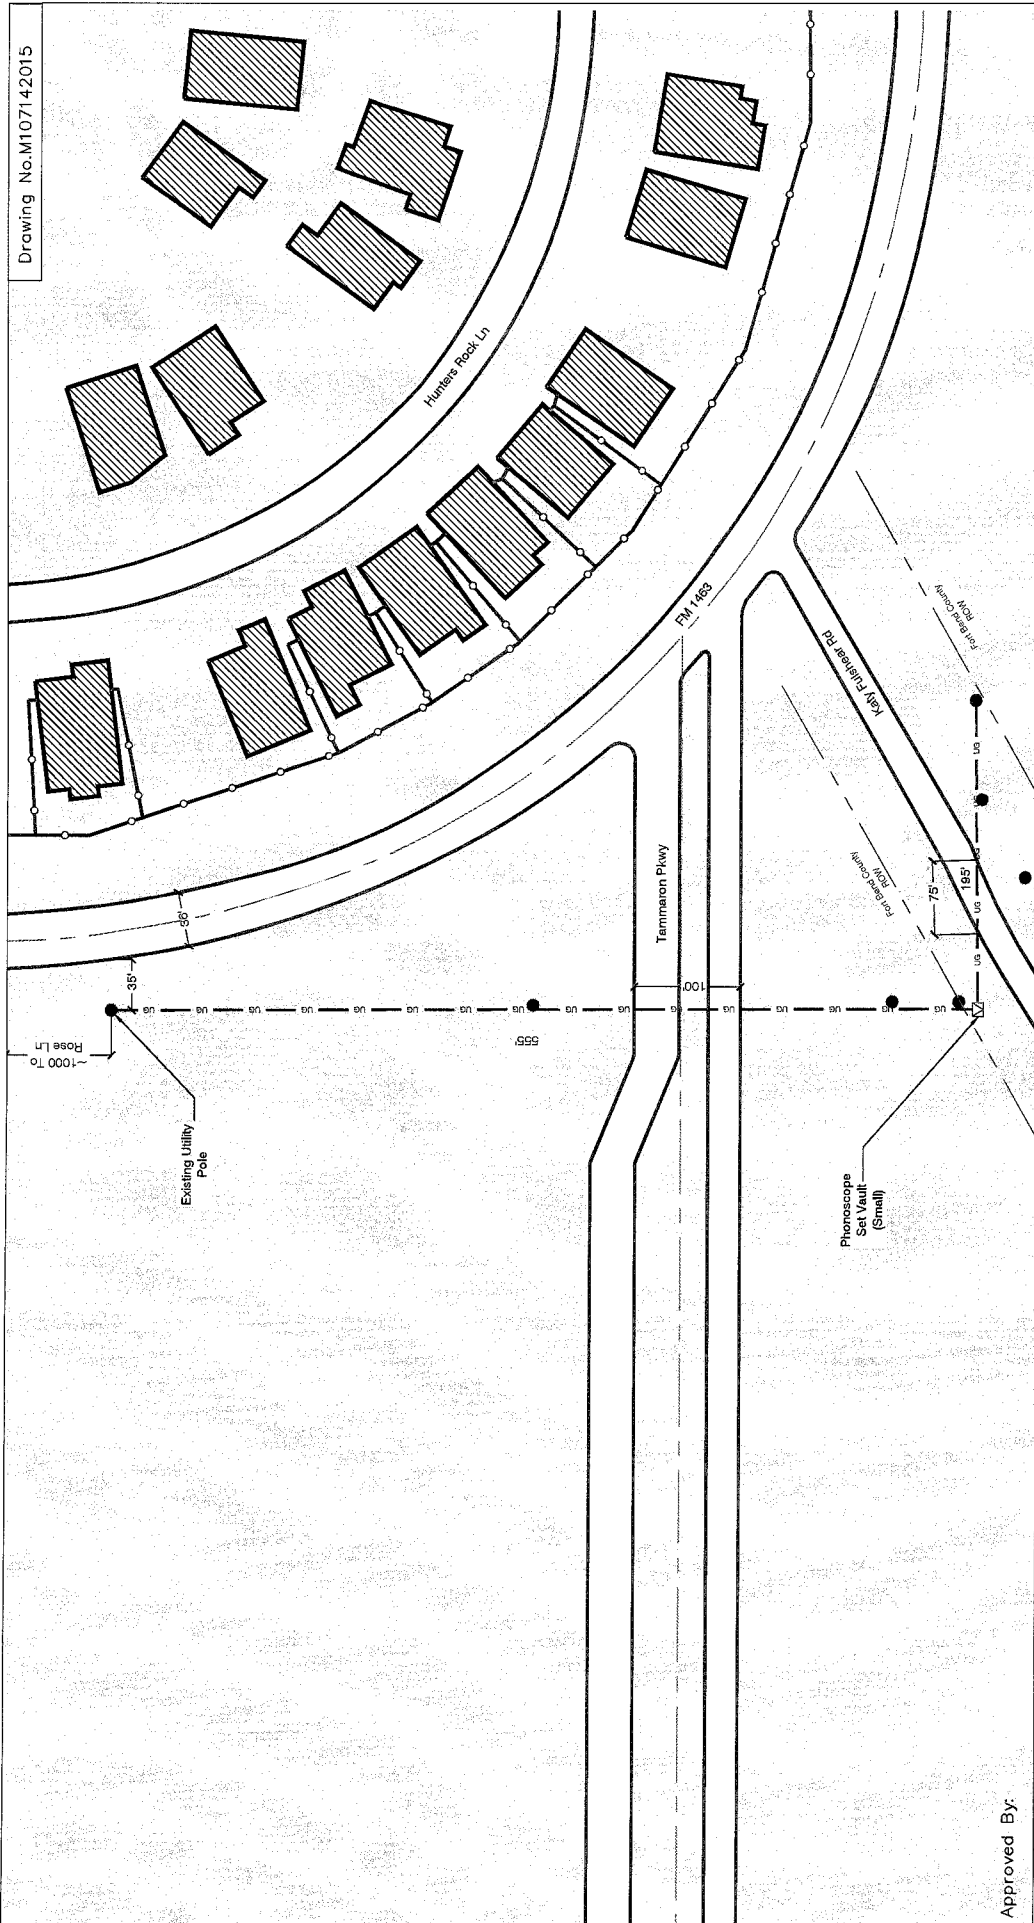

Approved By:

Symbol	Description	Revisions
UG	3 (1") PVC Conduits Encasing Fiber Optic Cable Underground	
●	Existing Utility Pole	
☒	Phoscope Set Vault (Small 30" L * 17" W * 17" D)	


Drawn By: Mohammed Al Qaysi  
 Scale: N.T.S.  
 Date: 10/14/2015

Key Map # 484 S

Job #0615--495  
 Notice Of Proposed Utility Installation  
 Proposed Underground Wireline Crossing  
 Site Plan  
 Page 1 of 2  
 W.O.#76882

**General Notes:**

- 1) Surface to be restored to its original condition in compliance with Fort Bend County Standards.
- 2) Contractors shall provide and install traffic control devices in conformance with part VI of Texas manual on Uniform Traffic Control Devices (TMUTCD—Latest Edition with Revisions) during construction.
- 3) No Lanes shall be blocked 7am–9am and 3pm–6:30pm Monday thru Friday.

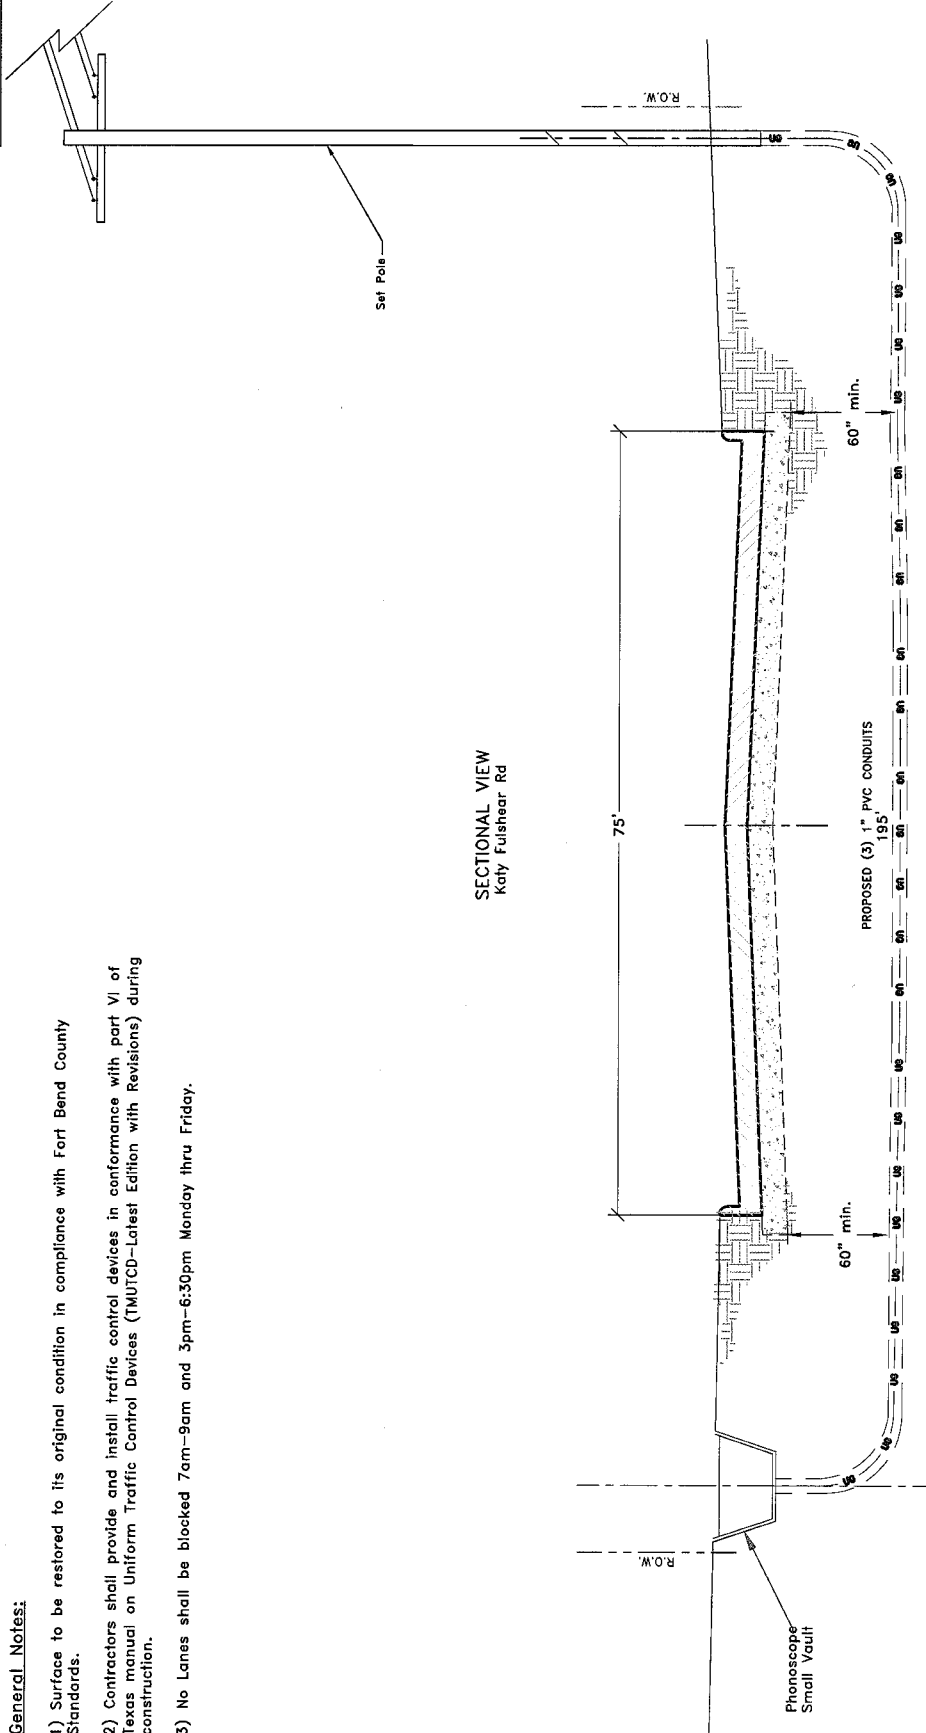

SECTIONAL VIEW  
Katy Fulstear Rd

Approved By:

Symbol	Description	Revisions
---	(3) 1" PVC Conduit Encasing Fiber Optic Cable Underground	

Drawn By: Mohammed Al Qaysi  
Scale: N.T.S.  
Date: 10/14/2015

Key Map # 484 S

Job #0615-495

Notice Of Proposed Utility Installation  
Proposed Underground Wireline Crossing  
Profile  
Page 2 of 2  
W.O#76882