

REVIEW BY FORT BEND COUNTY COMMISSIONERS COURT

On this 5th day of January, 2016, Commissioners Court came on to be heard and reviewed the accompanying notice of Phonoscope Light Wave, Inc Job Location 4686 Sienna Pkwy, Missouri City, TX 77459 Date 12/21/2015 Bond No. 103827669, Permit No. 2015-4728 to make use of certain Fort Bend County property subject to, "A Revised Order Regulating the Laying, Construction, Maintenance, and Repair of Buried Cables, Conduits, and Pole Lines, In, Under, Across or Along Roads, Streets, Highways, and Drainage Ditches in Fort Bend County, Texas, Under the Jurisdiction of the Commissioners Court of Fort Bend County, Texas," as passed by the Commissioners Court of Fort Bend County, Texas the 3rd day of August, 1987, recorded in Volume _____ of the Minutes of the Commissioners Court of Fort Bend County, Texas, to the extent that such order is not inconsistent with Article 1436a, Vernon's Texas Civil Statutes. Upon Motion of Commissioner Morrison, seconded by Commissioner Patton, duly put and carried, it is ORDERED, ADJUDGED AND DECREED that said notice of said above purpose is hereby acknowledged by the Commissioners Court of Fort Bend County, Texas, and that said notice be placed on record according to the regulation order thereof.

Notes:


1. Evidence of review by the Commissioners Court must be kept on the job site and failure to do so constitutes grounds for job shutdown.
2. Written notices are required:
 - a. 48 hours in advance of construction start up, and
 - b. when construction is completed and ready for final inspection
 Mail notices to: Permit Administrator
 Fort Bend County Engineering
 301 Jackson Street
 Richmond, Texas 77469
 281-633-7500
3. This permit expires one (1) year from date of permit if construction has not commenced.

By: Rick J. Stangle, PE, PTOE
FOR County Engineer



Presented to Commissioners Court and approved.
Recorded in Volume 1-05-16
Minutes of Commissioners Court

By: N/A
Drainage District Engineer/Manager

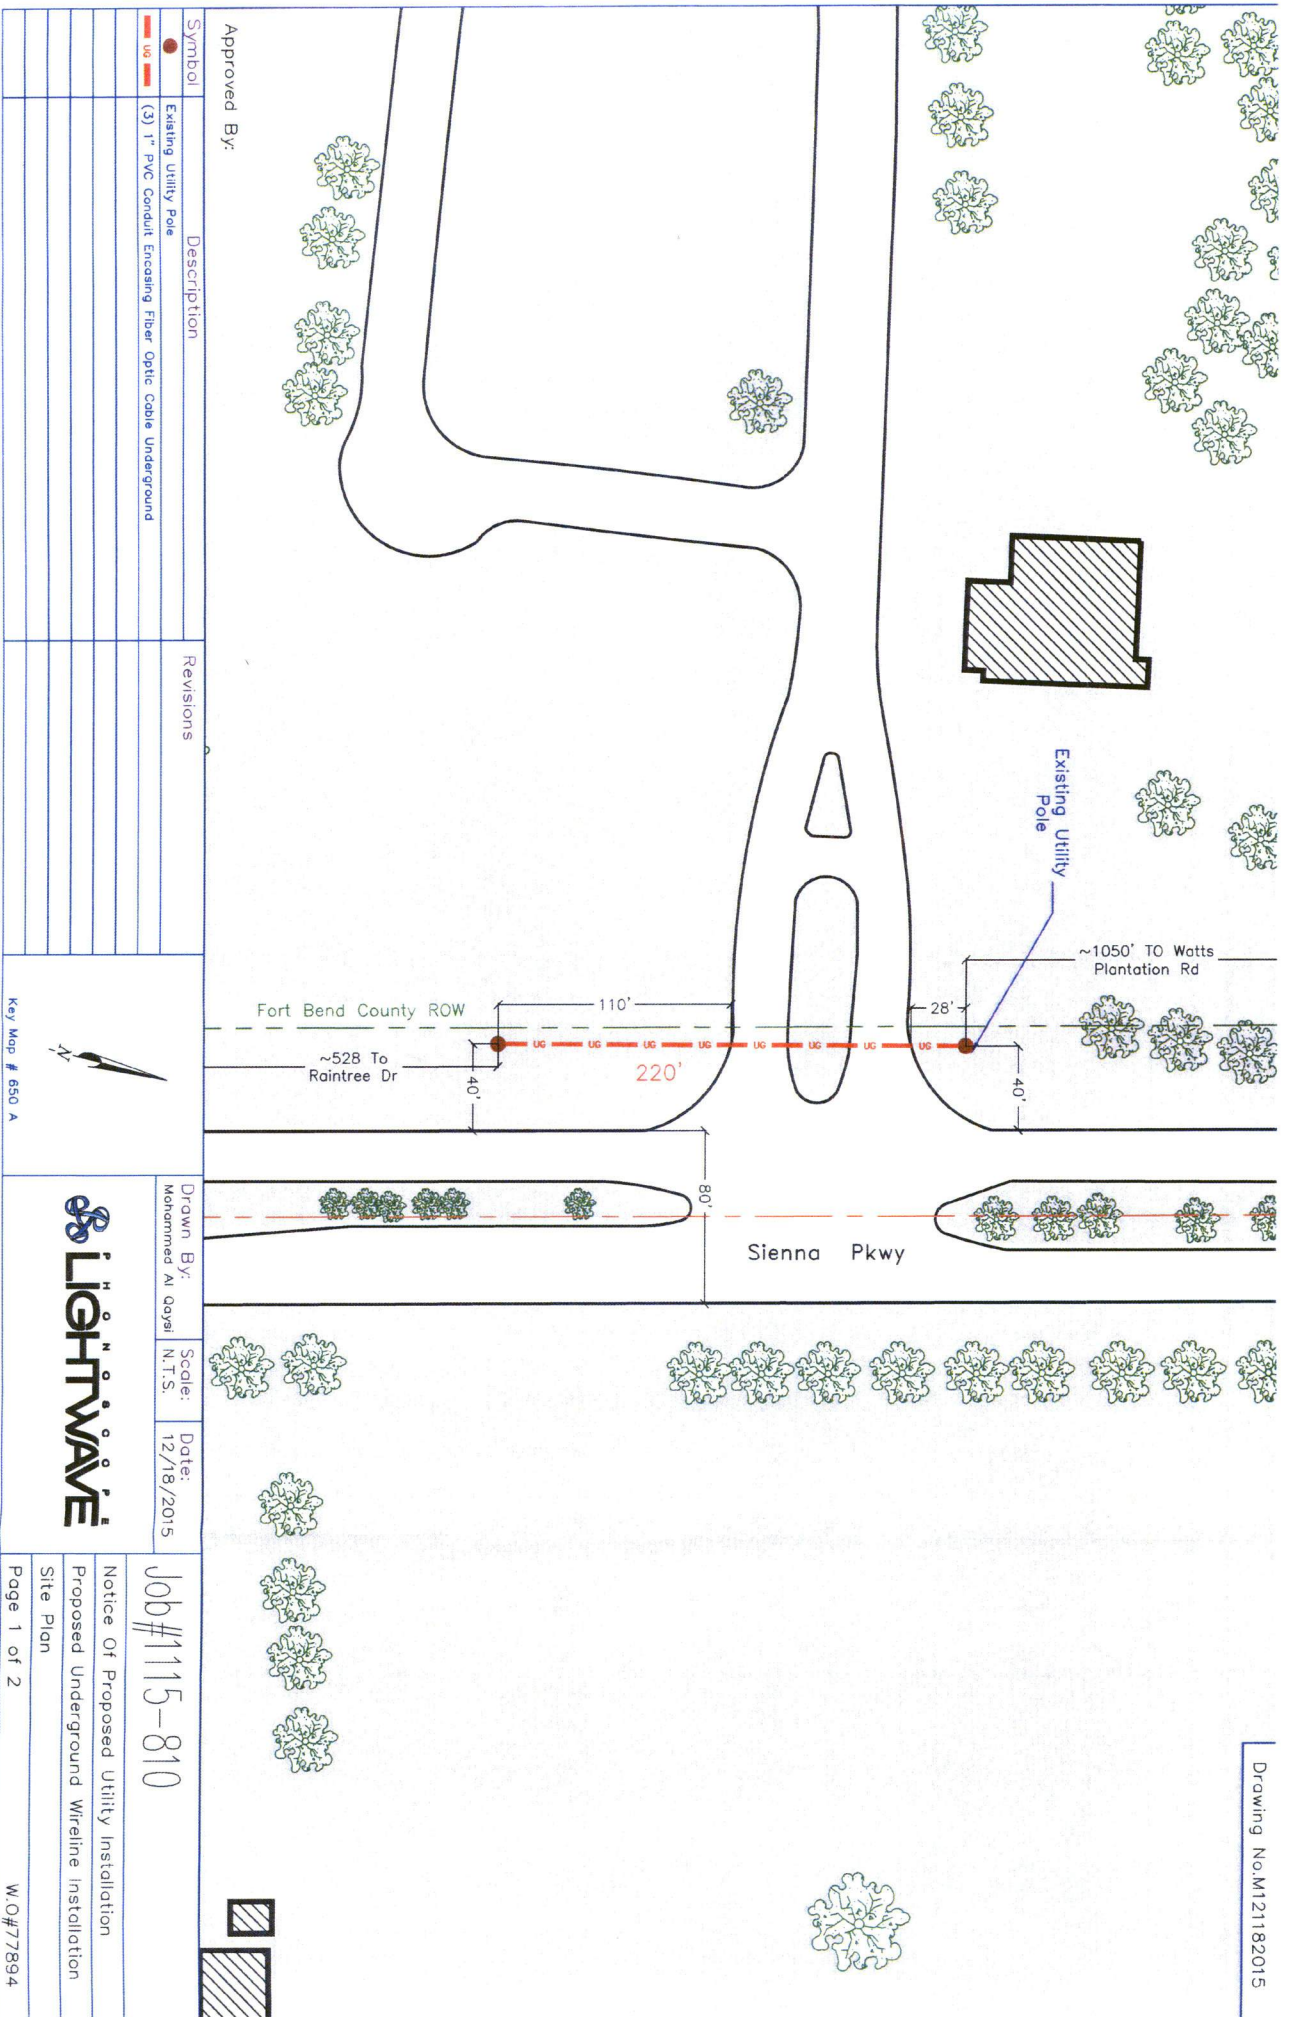Clerk of Commissioners Court
By: Aronda Wallis
Deputy




Approved By:

Symbol	Description	Revisions
	Existing Utility Pole	
	(3) 1" PVC Conduit Encasing Fiber Optic Cable Underground	

Key Map # 650 A



Drawn By: Mohammed Al qaysi
 Scale: N.T.S.
 Date: 12/18/2015




Job #1115-810
 Notice Of Proposed Utility Installation
 Proposed Underground Wireline Installation
 Site Plan
 Page 1 of 2
 W.O.#77894

General Notes:

- 1) Surface to be restored to its original condition in compliance with Fort Bend County Standards.
- 2) Contractors shall provide and install traffic control devices in conformance with part VI of Texas manual on Uniform Traffic Control Devices (TMUTCD-Latest Edition with Revisions) during construction.
- 3) No Lanes shall be blocked 7am-9am and 4pm-6:30pm Monday thru Friday.

SECTIONAL DETAIL Sienna Pkwy

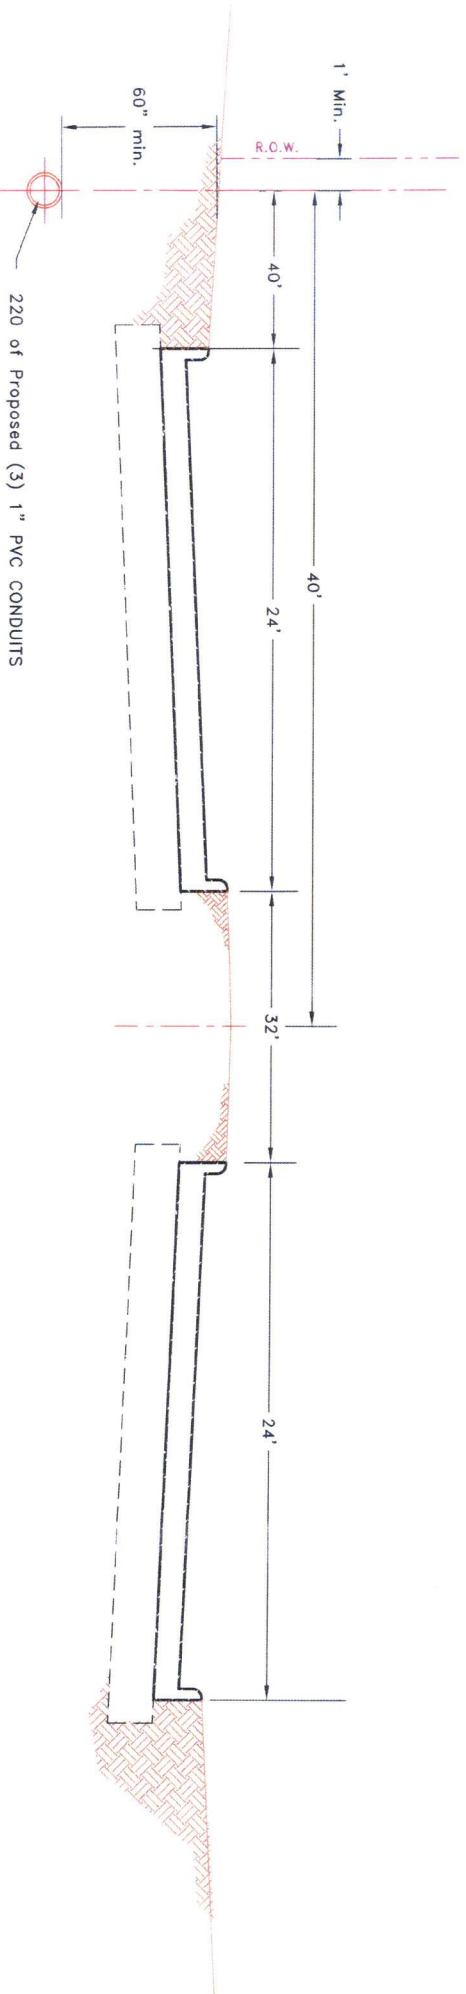

Approved By:

Symbol	Description	Revisions	 Key Map # 850 A			
	(3) 1" PVC Conduit Encasing Fiber Optic Cable Underground				Drawn By:	Scale:
			Mohammed Al Qayssi	N.T.S.	12/18/2015	