

REVIEW BY FORT BEND COUNTY COMMISSIONERS COURT

9F

On this 03 day of JUNE, 2014, Commissioners Court came on to be heard and reviewed the accompanying notice of CROWN CASTLE INTERNATIONAL

Job Location SEE ATTACHEMENT

Dated 05/21/14 BOND No. KO8871589, Permit No. 84582 to make use of certain Fort Bend County property subject to, "A Revised Order Regulating the Laying, Construction, Maintenance, and Repair of Buried Cables, Conduits, and Pole Lines, In, Under, Across or Along Roads, Streets, Highways, and Drainage Ditches in Fort Bend County, Texas, Under the Jurisdiction of the Commissioners Court of Fort Bend County, Texas," as passed by the Commissioners Court of Fort Bend County, Texas, date the 3rd day of August, 1987, recorded in Volume _____ of the Minutes of the Commissioners Court of Fort Bend County, Texas, to the extent that such order is not inconsistent with Article 1436a, Vernon's Texas Civil Statutes. Upon Motion of Commissioner Meyers, seconded by Commissioner Patterson, duly put and carried, it is ORDERED, ADJUGED AND DECREED that said notice of said above purpose is hereby acknowledged by the Commissioners Court of Fort Bend County, Texas, and that said notice be placed on record according to the regulation order thereof.

Notes:

1. Evidence of review by the Commissioners Court must be kept on the job site and failure to do so constitutes grounds for job shutdown.
2. Written notices are required:
 - a. 48 hours in advance of construction start up, and
 - b. When construction is completed and ready for final inspection

Mail notices to: Permit Administrator
Fort Bend County Engineering
301 JACKSON STREET
RICHMOND, Texas 77469
281-633-7500

3. This permit expires one (1) year from date of permit if construction has not commenced.

By

[Signature]
County Engineer

By

[Signature]
Drainage District Engineer/Manager

Presented to Commissioners Court and approved.

Recorded in Volume 6-3-14
Minutes of Commissioners Court.

Clerk of Commissioners Court

By [Signature]
Deputy

COUNTY OF FORT BEND

Engineering Department

301 JACKSON STREET
RICHMOND, Texas 77469

Johnny Ortega
Permit Administrator

1124 Blume Road
Phone: (281) 633-7500

PERMIT APPLICATION REVIEW FORM FOR CABLE, CONDUIT, AND POLE LINE ACTIVITY IN FORT BEND COUNTY

PERMIT NO. 10-582

The following "Notice of Proposed Cable, Conduit, and/or Pole Line activity in Fort Bend County" and accompanying attachments have been reviewed and the notice conforms to appropriate regulations set by Commissioner's Court of Fort Bend County, Texas.

- X (1) Complete Application Form.
- X a. Name of road, street, and/or drainage ditch affected.
- X b. Vicinity map showing course of direction.
- X c. Plans and specifications.

- X (2) Bond:
- District Attorney, approval when applicable.
- X Perpetual bond currently posted.
- No. K08871589
- Amount \$50,000.00
- Performance bond submitted.
- No.
- Amount
- Cashier's Check.
- No.
- Amount

- (3) Verbal permission given for emergencies, to start construction before approved in Commissioner's Court.

 Precinct Engineer Acknowledgment


 Date

 Precinct Commissioner Acknowledgment

 Date

- (4) 
- Drainage District Approval when applicable

We have reviewed this project and agree it meets minimum requirements.

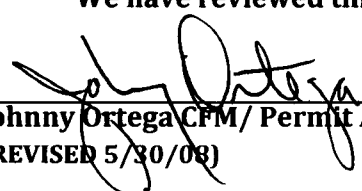
Johnny Ortega CFM/ Permit Administrator
(REVISED 5/30/08)

05/16/2014
Date

**NOTICE OF PROPOSED CABLE, CONDUIT AND/OR POLE LINE ACTIVITY
IN, UNDER, ACROSS OR ALONG ROADS, STREETS, HIGHWAYS AND DRAINAGE DITCHES
IN FORT BEND COUNTY**

APPLICANT'S JOB NO. 130605
 PERMIT No. 84502 PCT. No. 3
 BOND No. KO 88 71589

Formal notice is hereby given that Crown Castle International
 proposes to lay, construct, maintain and/or repair cable, conduit and/or pole line, in, under,
 across, or along roads, streets, highways and drainage ditches in Fort Bend County, as follows:

In, Under, or Across Roads and/or Drainage Ditches

Road or Ditch Name	: Distance & Direction From : Nearest Intersection	: Length of : Crossing	: Type of Construction : Bored: Jacked: Driven: Cased
N/A	:	:	:
:	:	:	:
:	:	:	:

Along Roads and/or Drainage Ditches

Road or Ditch Name	: Distance & Direction From : Nearest Intersection	: To :	: Distance :
See Attached	:	:	:
:	:	:	:
:	:	:	:

General Description

 
Installing 20 new utility poles with ground equipment for cell antenna node.

The Location and description of the proposed installation and appurtenances is more fully shown on the attached detail drawings. The laying, construction, maintenance and/or repair of the proposed installation shall be subject to "A Revised Order Regulating the Laying, Construction, Maintenance and/or Repair of Cables, Conduits, and/or Pole Lines, In, Under, Across, or Along Roads, Streets, Highways and Drainage Ditches in Fort Bend County, Texas, Under the Jurisdiction of the Commissioners Court of Fort Bend County, Texas," as passed by Commissioners Court of Fort Bend County, Texas, dated the 3rd. day of August, 1987, recorded in Volume 639 of the Minutes of the Commissioners Court of Fort Bend County, Texas.

Written notices are required: 1) 48 hours in advance of start of construction and
 2) when construction is complete and ready for final inspection.

Mail to: Permit Administrator/Fort Bend County Engineering
 P.O. Box 1449, Rosenberg, TX 77471.

Violation of requirements shall constitute grounds for job shut down.

COMPANY NAME: Shift Companies
 AGENT and/or OWNER

 (Signature)
 NAME & TITLE Chris Myers - Principal
 (Please Print)
 DATE 10.23.13
 ADDRESS 7333 E Monte Vista Rd
 (Street/P.O. Box)
Scottsdale AZ 85257
 City State Zip
 TELEPHONE NO: 602.432.0610
 (accessible 24 hrs/day, 7 days/week)

**Does project
comply with Fort
Bend County
Outdoor Lighting
Ordinance?**

Yes (☒)

No (☐)

Attachment

Peek Road

Springwalk Drive

Ivy Terrace Circle

Dillion Creek Lane

Willow Fork Drainage Ditch

Fry Road

S Fry Road

Bridgehaven Drive

Seven Meadow Pkwy

Cinco Ranch Blvd

Katy-Gaston Rd

Briarlilly Lane

Claircrest

Evening Canyon Lane

Blackwood Bridge Lane

Shady Walk Lane


Gaston Rd

Boxfield Lane

Enchanted Meadow Lane

CROWN CASTLE

PROJECT NAME: VERIZON - CINCO RANCH
 PROJECT ADDRESS: PEEK RD., S. OF FRY RD.
 PROJECT TYPE: WOOD POWER POLE
 HUB AREA: CINCO RANCH, TX
 NODE #(s): CCR-006-01
 COORDINATES: LAT: 29.711834, LONG: -95.763636

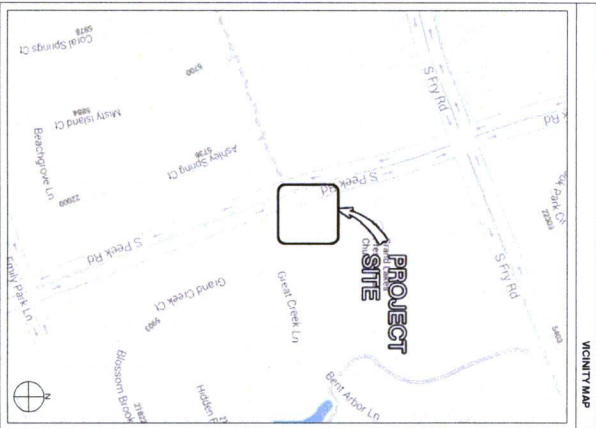

PROJECT TEAM	
ARCHITECT CROWN CASTLE Address: 2701 E. MONTE VISTA RD. HOUSTON, TX 77057 Phone Number: 281-463-4013 Fax Number: 281-463-4013 Contact: BRUCE POTTER	STRUCTURAL GENERAL CONTRACTOR Address: 2701 E. MONTE VISTA RD. HOUSTON, TX 77057 Phone Number: 281-463-4013 Fax Number: 281-463-4013 Contact: BRUCE POTTER
PROJECT MANAGER CROWN CASTLE Address: 1200 MAGNOLIA DR. HOUSTON, TX 77057 Phone Number: 281-463-4013 Fax Number: 281-463-4013 Contact: BRUCE POTTER	GENERAL CONTRACTOR Company: T.B.O. Address: 200 HOUSTON, TX 77057 Phone Number: 281-463-4013 Fax Number: 281-463-4013 Contact: BRUCE POTTER

PROJECT SUMMARY	
PROJECT NAME: VERIZON - CINCO RANCH	APPLICANT: CROWN CASTLE Address: 1200 MAGNOLIA DR. HOUSTON, TX 77057 Phone Number: 281-463-4013 Fax Number: 281-463-4013 Contact: BRUCE POTTER
PROJECT AREA: CINCO RANCH, TX	CONTRACT: BRUCE POTTER
DESCRIPTION: WOOD POWER POLE PORT BEND COUNTY ENGINEERING DEPT. 1101 BLAKE RD. HOUSTON, TX 77057 Phone Number: 281-463-4013 Fax Number: 281-463-4013 Contact: BRUCE POTTER	CODES: 2009 INTERNATIONAL BUILDING CODE (IBC) 2009 NATIONAL ELECTRICAL CODE (NEC) 2009 NATIONAL FIRE PROTECTION ASSOCIATION (NFPA) 701 2009 NATIONAL ELECTRICAL SAFETY CODE (NEC) 2009 NATIONAL ELECTRICAL SAFETY CODE (NEC)
HANDICAPPED REQUIREMENTS: FACILITY IS HANDICAPPED AND NOT FOR HANDICAPPED ACCESS REQUIREMENTS ARE NOT APPLICABLE.	SET MAP AREA: 500'
BLINDING REQUIREMENTS: FACILITY HAS NO BLINDING REQUIREMENTS.	
POWER COMPANY: CROWN CASTLE Address: 1200 MAGNOLIA DR. HOUSTON, TX 77057 Phone Number: 281-463-4013 Fax Number: 281-463-4013 Contact: BRUCE POTTER	

Sheet #	Sheet Description	Page
T1.1	TITLE SHEET	1
T1.2	GENERAL NOTES	2
T1.3	EQUIPMENT SPECIFICATIONS	3
T1.4	WET PAVEMENT AND ANTI-TURN PLAN	4
T1.5	CONSTRUCTION DETAILS	5
T1.6	CONSTRUCTION DETAILS	6
T1.7	CONSTRUCTION DETAILS	7
T1.8	CONSTRUCTION DETAILS	8
T1.9	CONSTRUCTION DETAILS	9
T1.10	CONSTRUCTION DETAILS	10
T1.11	CONSTRUCTION DETAILS	11
T1.12	CONSTRUCTION DETAILS	12
T1.99	CONSTRUCTION DETAILS	99
T1.100	CONSTRUCTION DETAILS	100

CROWN CASTLE 1200 MAGNOLIA DR. HOUSTON, TX 77057 Tel: 281-463-4013		SHIFT SHIFT Companies, LLC 1200 MAGNOLIA DR. HOUSTON, TX 77057 Tel: 281-463-4013	
RECORD DRAWING ISSUE DATE: 4/11/14		RECORD DRAWING DRAFTING ONLY	
THIS DRAWING IS COPYRIGHTED AND IS THE PROPERTY OF CROWN CASTLE. IT IS NOT TO BE REPRODUCED OR TRANSMITTED IN ANY FORM OR BY ANY MEANS, ELECTRONIC OR MECHANICAL, INCLUDING PHOTOCOPYING, RECORDING, OR BY ANY INFORMATION STORAGE AND RETRIEVAL SYSTEM, WITHOUT THE WRITTEN PERMISSION OF THE OWNER.		THIS DRAWING IS COPYRIGHTED AND IS THE PROPERTY OF SHIFT COMPANIES, LLC. IT IS NOT TO BE REPRODUCED OR TRANSMITTED IN ANY FORM OR BY ANY MEANS, ELECTRONIC OR MECHANICAL, INCLUDING PHOTOCOPYING, RECORDING, OR BY ANY INFORMATION STORAGE AND RETRIEVAL SYSTEM, WITHOUT THE WRITTEN PERMISSION OF THE OWNER.	
PROJECT NAME: VERIZON - CINCO RANCH		PROJECT ADDRESS: PEEK RD., S. OF FRY RD.	
NODE ADDRESS: NODE #CCR-006-01		PROJECT TYPE: WOOD POWER POLE	
HUB AREA: CINCO RANCH, TX		PROJECT MANAGER: BRUCE POTTER	
SHEET JOB NUMBER: 120603		SHEET NUMBER: 1 OF 8	
SHEET TITLE: TITLE SHEET		CASE #: 120603	
SHEET NUMBER: 1 OF 8		PLAN CHECK #: 120603	

		CROWN CASTLE 1500 AVONDALE DRIVE SUITE 1000 AVONDALE, FL 33420	
RECORD DRAWING ISSUE DATE: 4/11/14			
RECORD DRAWING DRAFTING ONLY			
SHIFT			
Shift Company, LLC 7001 WEST WINDYBROOK DRIVE SUITE 100 WEST WINDYBROOK, IL 60085-4003			
THIS DRAWING IS COPYRIGHTED AND IS THE SOLE PROPERTY OF THE OWNER. IT IS NOT TO BE REPRODUCED, COPIED, OR TRANSMITTED IN ANY FORM OR BY ANY MEANS, ELECTRONIC OR MECHANICAL, INCLUDING PHOTOCOPYING, RECORDING, OR BY ANY INFORMATION STORAGE AND RETRIEVAL SYSTEM, WITHOUT THE WRITTEN PERMISSION OF THE OWNER.			
RELEASE			
DATE: 4/11/14		SIGNATURE:	
1/1/2013		181 CITY SQUARE,	
12/1/14		CENTERPOINT TOWER,	
REVISIONS			
NO. DATE		COMMENT	
1/1/15		FIRST COMMISSION	
4/1/14		CENTERPOINT RELOCATION	
PROJECT NAME			
VERIZON - CINCO RANCH			
MOB ADDRESS			
NODE #:CCR-006-01			
PEER RD. S. OF FRY RD.			
AREA			
CINCO RANCH, TX			
SHIFT JOB NUMBER:		IN HOUSE	
1209603		DRAWN BY: RA CHECKED BY: CM	
SHEET TITLE			
GENERAL NOTES ABBREVIATIONS AND SYMBOLS			
SHEET NUMBER:		PAGE:	
1/12		2 OF 8	

ION-M7P/17P - Product Specification

ION-M7P/17P - Product Specification

Universal Input: 40V Output: 10V Power: 10W Frequency: 100Hz Temperature: 100°C Humidity: 100% Pressure: 100kPa Acceleration: 10g Rotation: 1000rpm Speed: 10m/s Position: 10mm Angle: 10° Force: 10N Torque: 10Nm Flow: 10L/min Pressure: 10MPa Temperature: 1000°C Humidity: 1000% Pressure: 1000kPa Acceleration: 1000g Rotation: 10000rpm Speed: 100m/s Position: 100mm Angle: 100° Force: 100N Torque: 100Nm Flow: 100L/min Pressure: 100MPa Temperature: 10000°C Humidity: 10000% Pressure: 10000kPa Acceleration: 10000g Rotation: 100000rpm Speed: 1000m/s Position: 1000mm Angle: 1000° Force: 1000N Torque: 1000Nm Flow: 1000L/min Pressure: 1000MPa Temperature: 100000°C Humidity: 100000% Pressure: 100000kPa Acceleration: 100000g Rotation: 1000000rpm Speed: 10000m/s Position: 10000mm Angle: 10000° Force: 10000N Torque: 10000Nm Flow: 10000L/min Pressure: 10000MPa Temperature: 1000000°C Humidity: 1000000% Pressure: 1000000kPa Acceleration: 1000000g Rotation: 10000000rpm Speed: 100000m/s Position: 100000mm Angle: 100000° Force: 100000N Torque: 100000Nm Flow: 100000L/min Pressure: 100000MPa Temperature: 10000000°C Humidity: 10000000% Pressure: 10000000kPa Acceleration: 10000000g Rotation: 100000000rpm Speed: 1000000m/s Position: 1000000mm Angle: 1000000° Force: 1000000N Torque: 1000000Nm Flow: 1000000L/min Pressure: 1000000MPa Temperature: 100000000°C Humidity: 100000000% Pressure: 100000000kPa Acceleration: 100000000g Rotation: 1000000000rpm Speed: 10000000m/s Position: 10000000mm Angle: 10000000° Force: 10000000N Torque: 10000000Nm Flow: 10000000L/min Pressure: 10000000MPa Temperature: 1000000000°C Humidity: 1000000000% Pressure: 1000000000kPa Acceleration: 1000000000g Rotation: 10000000000rpm Speed: 100000000m/s Position: 100000000mm Angle: 100000000° Force: 100000000N Torque: 100000000Nm Flow: 100000000L/min Pressure: 100000000MPa Temperature: 10000000000°C Humidity: 10000000000% Pressure: 10000000000kPa Acceleration: 10000000000g Rotation: 100000000000rpm Speed: 1000000000m/s Position: 1000000000mm Angle: 1000000000° Force: 1000000000N Torque: 1000000000Nm Flow: 1000000000L/min Pressure: 1000000000MPa Temperature: 100000000000°C Humidity: 100000000000% Pressure: 100000000000kPa Acceleration: 100000000000g Rotation: 1000000000000rpm Speed: 10000000000m/s Position: 10000000000mm Angle: 10000000000° Force: 10000000000N Torque: 10000000000Nm Flow: 10000000000L/min Pressure: 10000000000MPa Temperature: 1000000000000°C Humidity: 1000000000000% Pressure: 1000000000000kPa Acceleration: 1000000000000g Rotation: 10000000000000rpm Speed: 100000000000m/s Position: 100000000000mm Angle: 100000000000° Force: 100000000000N Torque: 100000000000Nm Flow: 100000000000L/min Pressure: 100000000000MPa Temperature: 10000000000000°C Humidity: 10000000000000% Pressure: 10000000000000kPa Acceleration: 10000000000000g Rotation: 100000000000000rpm Speed: 1000000000000m/s Position: 1000000000000mm Angle: 1000000000000° Force: 1000000000000N Torque: 1000000000000Nm Flow: 1000000000000L/min Pressure: 1000000000000MPa Temperature: 100000000000000°C Humidity: 100000000000000% Pressure: 100000000000000kPa Acceleration: 100000000000000g Rotation: 1000000000000000rpm Speed: 10000000000000m/s Position: 10000000000000mm Angle: 10000000000000° Force: 10000000000000N Torque: 10000000000000Nm Flow: 10000000000000L/min Pressure: 10000000000000MPa Temperature: 1000000000000000°C Humidity: 1000000000000000% Pressure: 1000000000000000kPa Acceleration: 1000000000000000g Rotation: 10000000000000000rpm Speed: 100000000000000m/s Position: 100000000000000mm Angle: 100000000000000° Force: 100000000000000N Torque: 100000000000000Nm Flow: 100000000000000L/min Pressure: 100000000000000MPa Temperature: 10000000000000000°C Humidity: 10000000000000000% Pressure: 10000000000000000kPa Acceleration: 10000000000000000g Rotation: 100000000000000000rpm Speed: 1000000000000000m/s Position: 1000000000000000mm Angle: 1000000000000000° Force: 1000000000000000N Torque: 1000000000000000Nm Flow: 1000000000000000L/min Pressure: 1000000000000000MPa Temperature: 100000000000000000°C Humidity: 100000000000000000% Pressure: 100000000000000000kPa Acceleration: 100000000000000000g Rotation: 1000000000000000000rpm Speed: 10000000000000000m/s Position: 10000000000000000mm Angle: 10000000000000000° Force: 10000000000000000N Torque: 10000000000000000Nm Flow: 10000000000000000L/min Pressure: 10000000000000000MPa Temperature: 1000000000000000000°C Humidity: 1000000000000000000% Pressure: 1000000000000000000kPa Acceleration: 1000




SCALE: N.T.S.

700 MHz Dual Band Omni Antenna

	Antenna 1	Antenna 2
Dual Band MHz	688-894	1710-2170
Dual Polarization	X	X
HPBW	360°	360°

840 10510 840 10511

 General specifications

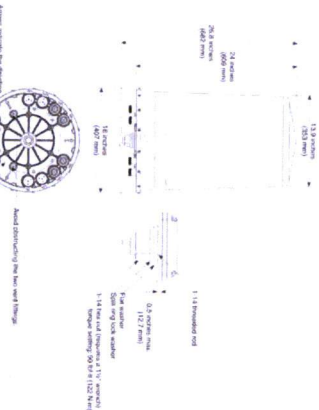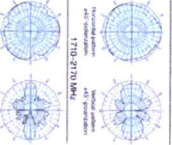[illegible]

ANTENNA SPECIFICATIONS

Author: Inc., Social Director: First Office from 4100, Appleton, CA 95021 (USA) Phone: (415) 779-6600 Fax: (415) 779-3891
Email: corporateaffairs@kaisersteel.com Website: www.kaisersteel.com

Katsunori Ito Saito Densetsu Fied Office (for KSI) Nishiohri (04) 9-562-8164 Phone: (044) 7-79-6000 Fax: (044) 7-79-2071
 E-mail: katsunori@katsunori.co.jp denso@katsunori.co.jp office@katsunori.co.jp

SCALE N.T.S.	12
--------------	----



CROWN
CASTLE

CROWN CASTLE
1220 AUGUSTA DR.,
HOUSTON, TX 77057
PH: 469.343.4401

RECORD DRAWINGS ISSUE DATE: 4.17.14

Shift Companies, LLC
7333 E. MONTE VISTA ROAD
SCOTTSDALE, ARIZONA 85257
PH: 480.264.0829
FAX: 480.264.0163

THIS DRAWING IS COPYRIGHTED AND IS THE SOLE PROPERTY OF THE OWNER. IT IS PRODUCED SOLELY FOR USE BY THE OWNER AND ITS AFFILIATES. REPRODUCTION OR USE OF THIS DRAWING AND/OR THE INFORMATION CONTAINED IN IT IS FORBIDDEN WITHOUT THE WRITTEN PERMISSION OF THE OWNER.

RELEASE	
DATE	SUBMITTAL
11-26-13	1ST CITY SUBMITTAL
1-21-14	CENTERPOINT SUBMITTAL

REVISIONS		
NO.	DATE	COMMENT
	12.11.13	FIBER COORDINATION
	4.17.14	CENTERPOINT RESUBMITAL

PROJECT NAME
VERIZON - CINCO RANCH

NODE #:CCR-006-01
PEEK RD., S. OF FRY RD.

HUB AREA

CINCO RANCH, TX

120603

EQUIPMENT SPECIFICATIONS

SHEET NUMBER


PLOT SCALE: 1:1 @ 24x36; 1:2 @ 11x17

CASE #

KEYNOTE LEGEND			KEYNOTE LEGEND		
KEYNOTE	DESCRIPTION	DETAIL	KEYNOTE	DESCRIPTION	DETAIL
461	PROPOSED SIGNAGE FOR TRAVEL AHEAD IN CONSTRUCTION ZONE	SECTION 1			
462	PROPOSED SIGNAGE FOR TRAVEL AHEAD IN CONSTRUCTION ZONE	SECTION 1	463	PROPOSED SIGNAGE FOR TRAVEL AHEAD IN CONSTRUCTION ZONE	SECTION 1
463	PROPOSED SIGNAGE FOR TRAVEL AHEAD IN CONSTRUCTION ZONE	SECTION 1	464	PROPOSED SIGNAGE FOR TRAVEL AHEAD IN CONSTRUCTION ZONE	SECTION 1
464	PROPOSED SIGNAGE FOR TRAVEL AHEAD IN CONSTRUCTION ZONE	SECTION 1	465	PROPOSED SIGNAGE FOR TRAVEL AHEAD IN CONSTRUCTION ZONE	SECTION 1
465	PROPOSED SIGNAGE FOR TRAVEL AHEAD IN CONSTRUCTION ZONE	SECTION 1	466	PROPOSED SIGNAGE FOR TRAVEL AHEAD IN CONSTRUCTION ZONE	SECTION 1
466	PROPOSED SIGNAGE FOR TRAVEL AHEAD IN CONSTRUCTION ZONE	SECTION 1	467	PROPOSED SIGNAGE FOR TRAVEL AHEAD IN CONSTRUCTION ZONE	SECTION 1
467	PROPOSED SIGNAGE FOR TRAVEL AHEAD IN CONSTRUCTION ZONE	SECTION 1	468	PROPOSED SIGNAGE FOR TRAVEL AHEAD IN CONSTRUCTION ZONE	SECTION 1
468	PROPOSED SIGNAGE FOR TRAVEL AHEAD IN CONSTRUCTION ZONE	SECTION 1	469	PROPOSED SIGNAGE FOR TRAVEL AHEAD IN CONSTRUCTION ZONE	SECTION 1
469	PROPOSED SIGNAGE FOR TRAVEL AHEAD IN CONSTRUCTION ZONE	SECTION 1	470	PROPOSED SIGNAGE FOR TRAVEL AHEAD IN CONSTRUCTION ZONE	SECTION 1

LATITUDE:	29.71834
LONGITUDE:	-95.76959
POLE TYPE:	WOOD POWER POLE
POLE ID #	N/A

 - [illegible]



CROWN CASTLE
 10000 CROWN CASTLE DRIVE
 HOUSTON, TX 77067
 PH 408-343-4401

RECORD DRAWING ISSUE DATE: 4/1/84

RECORD DRAWING DEPARTMENT ONE, X

SHIFT

THE DRAWINGS ARE COPYRIGHTED AND ARE NOT TO BE REPRODUCED OR TRANSMITTED IN ANY FORM OR BY ANY MEANS, ELECTRONIC OR MECHANICAL, INCLUDING PHOTOCOPYING, RECORDING, OR BY ANY INFORMATION STORAGE AND RETRIEVAL SYSTEM, WITHOUT THE WRITTEN PERMISSION OF THE OWNER.



SHIFT COMPANY, LLC
SCOTTISH, ALABAMA 36187
PH: 662-244-0172
FX: 662-244-0163

RELEASE		
DATE	SUBMITTER	
11-24-13	1ST CITY SUBMITTAL	
12-11-14	CENTROPOINT SUBMITTAL	

REVISIONS		
NO.	DATE	COMMENT
	12-11-14	FIBER COORDINATION
	4/17/14	CENTROPOINT SUBMITTAL

PROJECT NAME
VERIZON - CINCO RANCH
MODE ADDRESS
NODE #:CCR-006-01
PEEK RD., S. OF FRY RD.

PLOT AREA	
CINCO RANCH, TX	
SHEET JOB NUMBER	IN HOUSE
120603	DRAWN BY: SA
	CHECKED BY: CA
SHEET TITLE	
SITE PLAN, EQUIPMENT AND ANTENNA PLAN	
SHEET NUMBER	PAGE
A1.2	4 OF 8
PLOT SCALE: 1" = 20' (HORIZ) 1" = 10' (VERT)	

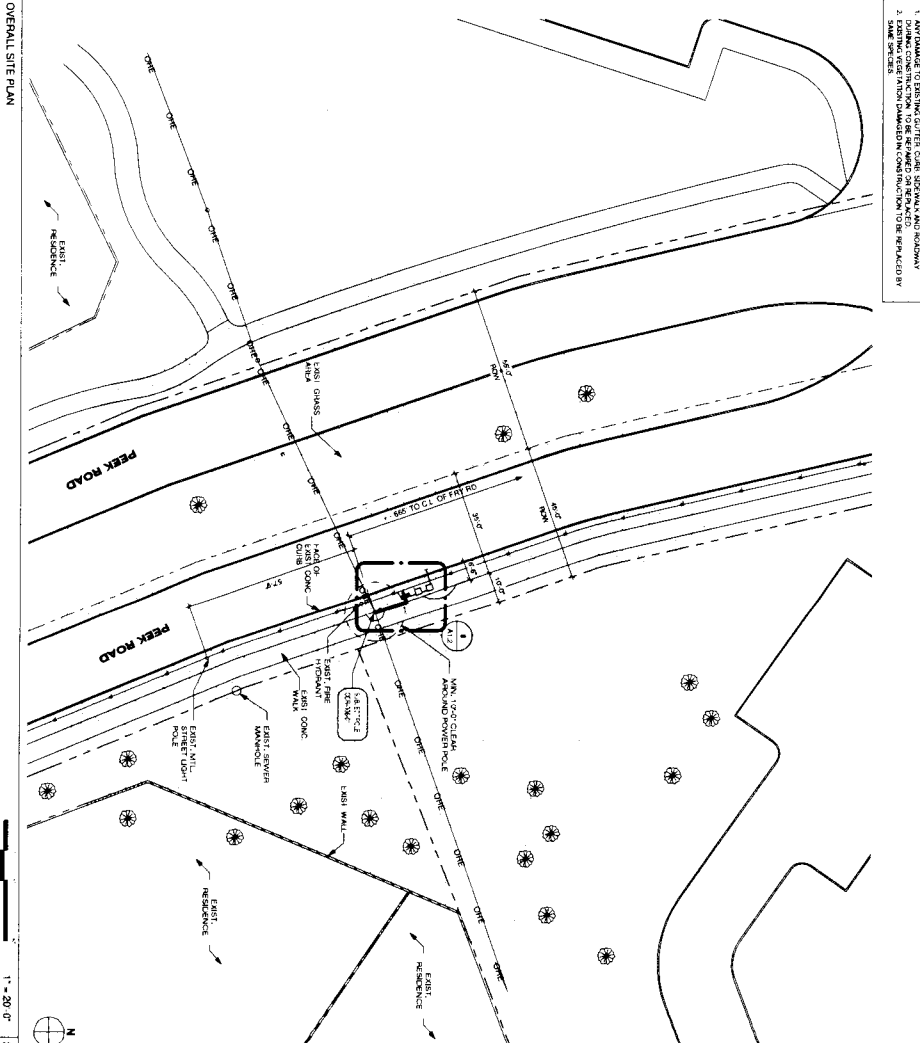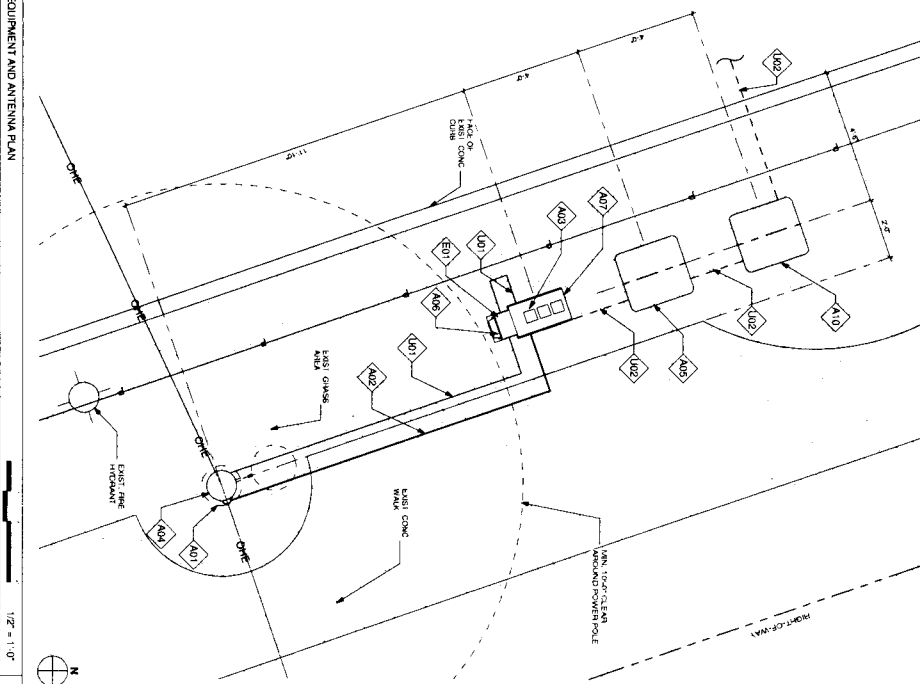



KEYNOTE	DESCRIPTION	DETAIL NUMBER
401	PROPOSED DOWN CASTLE MOUNT AIRFIELD	1001-1
402	PROPOSED DOWN CASTLE MOUNT AIRFIELD	1001-2
403	PROPOSED DOWN CASTLE MOUNT AIRFIELD	1001-3
404	PROPOSED DOWN CASTLE MOUNT AIRFIELD	1001-4
405	PROPOSED DOWN CASTLE MOUNT AIRFIELD	1001-5
406	PROPOSED DOWN CASTLE MOUNT AIRFIELD	1001-6
407	PROPOSED DOWN CASTLE MOUNT AIRFIELD	1001-7
408	PROPOSED DOWN CASTLE MOUNT AIRFIELD	1001-8
409	PROPOSED DOWN CASTLE MOUNT AIRFIELD	1001-9
410	PROPOSED DOWN CASTLE MOUNT AIRFIELD	1001-10
411	PROPOSED DOWN CASTLE MOUNT AIRFIELD	1001-11
412	PROPOSED DOWN CASTLE MOUNT AIRFIELD	1001-12
413	PROPOSED DOWN CASTLE MOUNT AIRFIELD	1001-13
414	PROPOSED DOWN CASTLE MOUNT AIRFIELD	1001-14
415	PROPOSED DOWN CASTLE MOUNT AIRFIELD	1001-15
416	PROPOSED DOWN CASTLE MOUNT AIRFIELD	1001-16
417	PROPOSED DOWN CASTLE MOUNT AIRFIELD	1001-17
418	PROPOSED DOWN CASTLE MOUNT AIRFIELD	1001-18
419	PROPOSED DOWN CASTLE MOUNT AIRFIELD	1001-19
420	PROPOSED DOWN CASTLE MOUNT AIRFIELD	1001-20



PROJECT NAME	VERIZON - CINCO RANCH
NODE ADDRESS	

NODE #:CCR-006-01
PEEK RD., S. OF FRY RD.

CINCO RANCH, TX

120603	DRAWN BY: RA
	CHECKED BY: CM
SHEET TITLE	

SHEET NUMBER

A1.3

PAGE

5 OF 8

PLOT SCALE: 1:1 @ 24x36; 1:2 @ 11x17

CASE #



CROWN CASTLE
2000 AVALON BL.
DALLAS, TEXAS 75241
Tel. (214) 343-4471
Fax (214) 343-4471



 

 



RECORD CRAWLING ISSUE DATE: 4/11/94

RECORD CRAWLING DATING ONLY

100% Guaranteed
 100% Satisfaction
 100% Money Back
 100% Shipping Insurance
 100% International Airplane Delivery

Call: (800) 343-4411

SHIFT

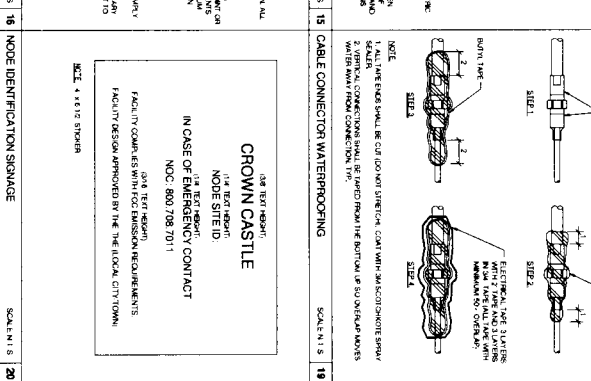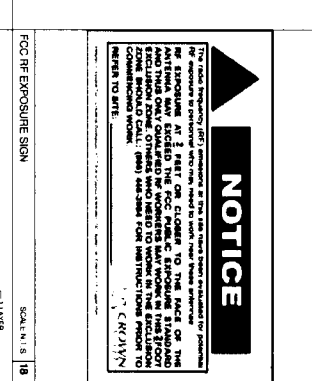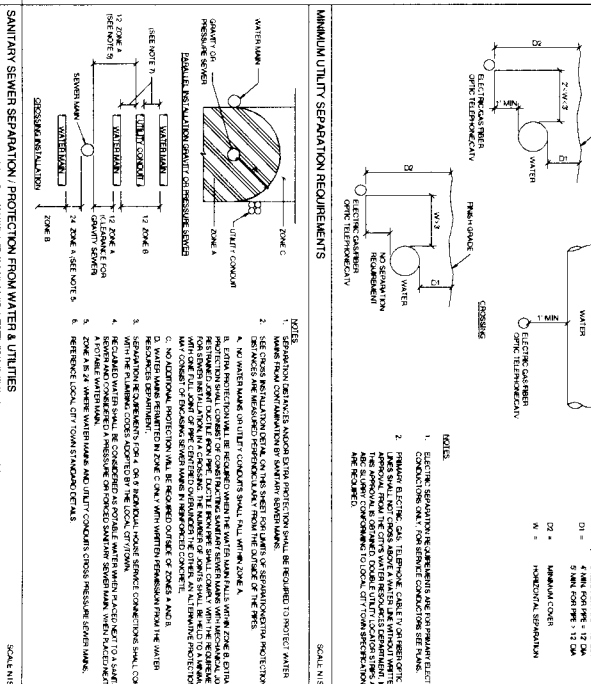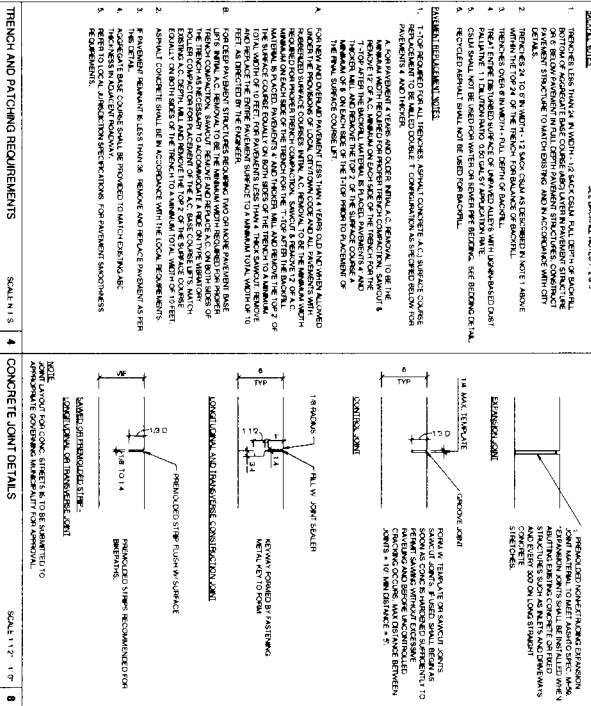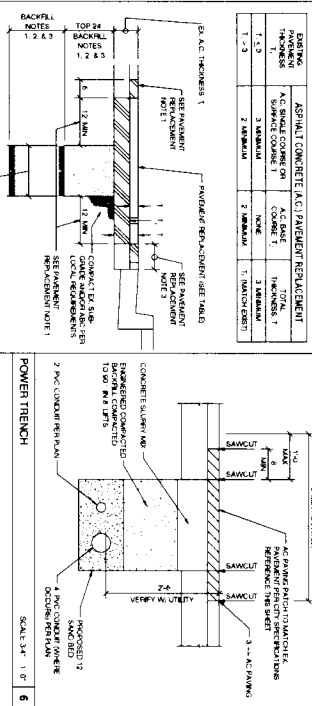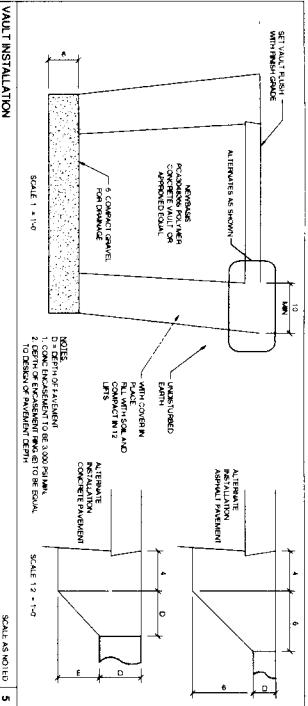

SHIFT

SHIFT COMPANY, LLC
1000 TEXAS AVE
SUITE 1000
DALLAS, TEXAS 75201
TEL: 469.343.4401

THIS DRAWING IS COPYRIGHTED AND IS THE SOLE PROPERTY OF THE OWNER. IT IS NOT TO BE REPRODUCED OR TRANSMITTED IN ANY FORM OR BY ANY MEANS, ELECTRONIC OR MECHANICAL, INCLUDING PHOTOCOPYING, RECORDING, OR BY ANY INFORMATION STORAGE AND RETRIEVAL SYSTEM, WITHOUT THE WRITTEN PERMISSION OF THE OWNER.

NOTICE

THE USER HEREBY AGREES TO HOLD THE ENGINEER HARMLESS FROM AND AGAINST ALL CLAIMS, DAMAGES, LOSSES AND EXPENSES, INCLUDING REASONABLE ATTORNEY'S FEES, THAT MAY BE ASSERTED AGAINST THE ENGINEER BY ANY THIRD PARTY AS A RESULT OF THE USER'S USE OF THIS DRAWING FOR ANY PURPOSE OTHER THAN THAT FOR WHICH IT WAS PREPARED.

PROJECT NAME
VERIZON - CINCO RANCH

PROJECT NUMBER
120863

DATE
12/11/13

DESIGNED BY
J. L. HARRIS

CHECKED BY
J. L. HARRIS




IN CHARGE
J. L. HARRIS



CONSTRUCTION DETAILS

PEEK RD. S. OF FRY RD.

NOTE # CCR-006-01

SCALE 1/2" = 1'-0"

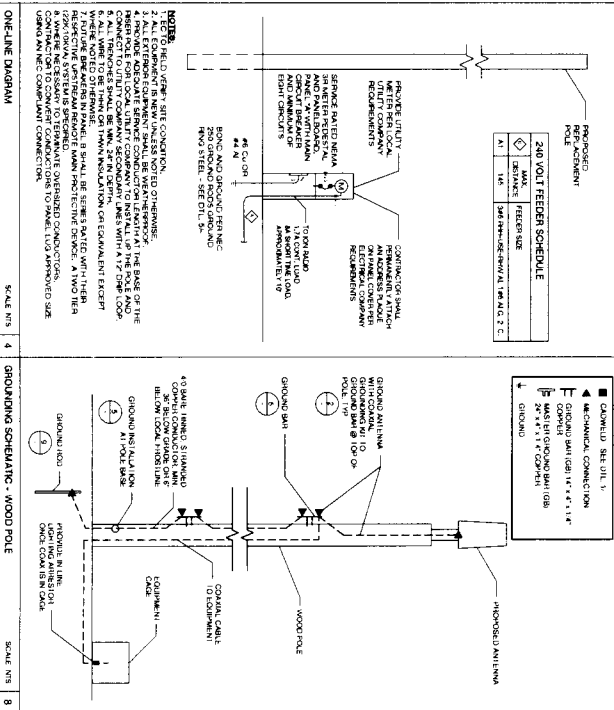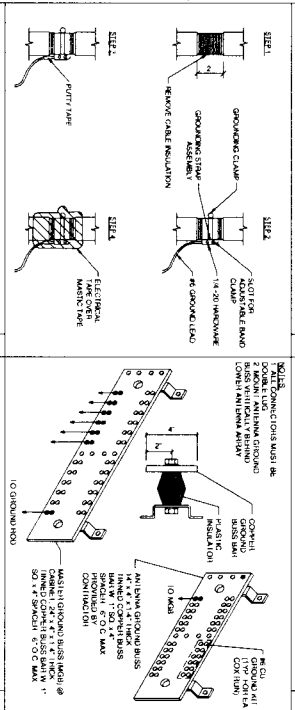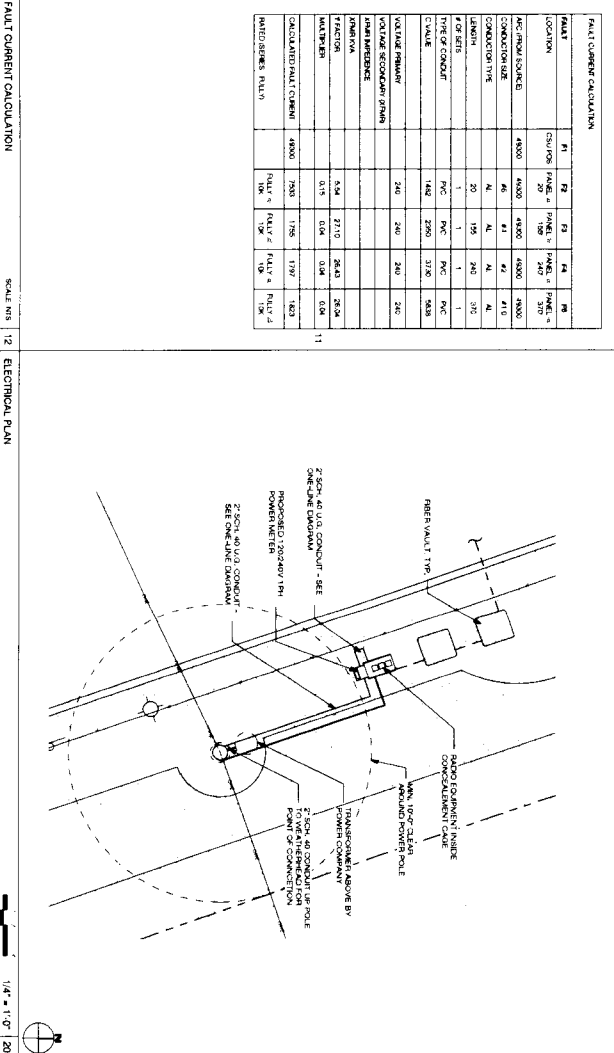[illegible]

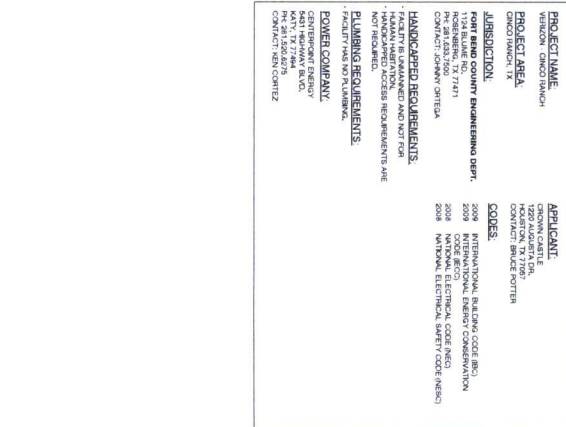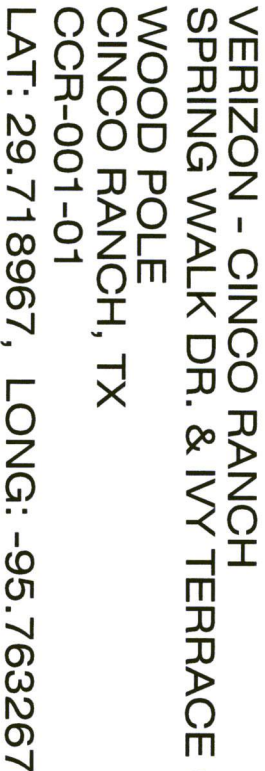

RELEASE	
DATE	SUBMITTAL
11-28-13	1ST CITY SUBMITTAL
4.17.14	PERMIT SUBMITTAL
REVISIONS	
NO.	COMMENT
DATE	
12.11.13	Final Coordination

PROJECT NAME
VERIZON - CINCO RANCHMODE ADDRESS

NODE #:CCR-001-01

SPRING WALK DR. & IVY
TERRACE CIR.

[illegible]CINCO RANCH, TX

SHIFT JOB NUMBER

CHECKED BY: CM

SHEET TITLE

TITLE SHEET

PAGE

T1.1 1 OF 8

CASE #

PLAN CHECK #

THIS DRAWING IS COPYRIGHTED AND IS THE SOLE PROPERTY OF THE OWNER. IT IS PRODUCED SOLELY FOR USE BY THE OWNER AND ITS AFFILIATES. REPRODUCTION OR USE OF THIS DRAWING AND/OR THE INFORMATION CONTAINED IN IT IS FORBIDDEN WITHOUT THE WRITTEN PERMISSION OF THE OWNER.

SHIFT

Shift Companies, LLC
7322 E. MONTE VISTA ROAD
SCOTTSDALE, ARIZONA 85257
ph: 480.264.0023
fax: 480.264.0163

RECORD DRAWINGS ISSUE DATE: 4/17/14



CROWN CASTLE

1500 MAGNOLIA DR.
HOUSTON, TEXAS 77057
PH. 469-344-0001

RECORD DRAWING ISSUE DATE: 4/17/14

SHIFT

SHIFT COMPANIES, LLC
10101 KATY AVENUE, SUITE 100
HOUSTON, TEXAS 77054
PH. 469-344-0001

THIS DRAWING IS COPYRIGHTED AND IS THE SOLE PROPERTY OF THE OWNER. IT IS NOT TO BE REPRODUCED, COPIED, LOANED, OWNED AND ITS VARIATIONS, THE DRAWING AND/OR THE INFORMATION CONTAINED HEREIN IS TO BE KEPT IN STRICTLY CONFIDENTIAL PERMISSION OF THE OWNER.

RECORD DRAWING CHARTING ONLY.

PROJECT NAME
VERIZON - CINCO RANCH

NO. ADDRESS
120803

NOTE #:**CCR-001-01**

SPRING WALK DR. & IVY TERRACE CIR.

HUB AREA

CINCO RANCH, TX

SHEET JOB NUMBER
120803

IN HOUSE
DRAWN BY: MA
CHECKED BY: CM

SHEET TITLE
**GENERAL NOTES
ABBREVIATIONS AND
SYMBOLS**

SHEET NUMBER
2

PAGE
OF 8

NOT SCALE: 1" = 40'-0" 1/2" = 20'-0" 1/4" = 10'-0"

RELEASE	
DATE	REASON
1/14/13	15 CITY SUBMITTAL
4/17/14	REVIEW SUBMITTAL

REVISIONS		
NO.	DATE	COMMENT
1	12/1/13	Final Construction
2	4/17/14	REVISED CONSTRUCTION


PLAN CHECK #

ION-M7P/17P - Product Specification

771012 8

HOUSTON, TX 77067
PH 469.343.4401

RECORD DRAWING ISSUE DATE: 4.17.14

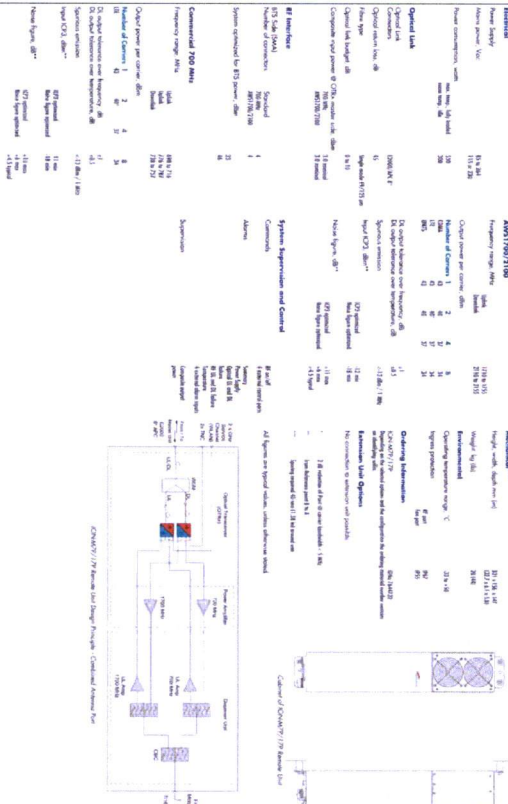


SCALE: N.T.S.	18
---------------	----

SCALA DIVISION

SCALA DIVISION

Dual Band (M-Hz)	638-894	1710-2170
Dual Polarization	X	X
MPEBW	360°	360°

General specifications

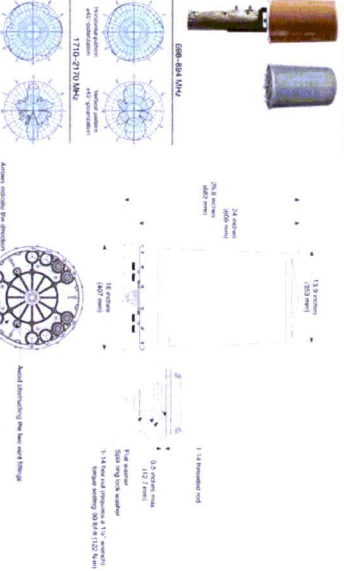[illegible]




Model	U
Serial number	81
Radio type	Q

All specifications are subject to change.

is available at www.kaltrypa-kuon.com

ANTENNA SPECIFICATIONS

John A. Hooton, CMAA, PMP, (408) 255-1100 Fax: (408) 779-3081
hooton@hawaii.rr.com; hooton@hawaii.rr.com

Kalman Inc., 10000 Dundas Street East, Unit 100, Box 6500, Mississauga, ON L4V 1G4, Canada. Phone: (905) 779-0000. Fax: (905) 779-0073.
E-mail: info@kalman.com or info@kalman.com. Internet: www.kalman.com

SCALE: N.T.S.

VERIZON - CINCO RANCH

NODE #:CCR-001-0

STYLING WALK DN. & LVT
TERRACE CIR.

HUB AREA

SHIFT JOB NUMBER

SHEET TITLE

SPECIFICATIONS

T1.3 3 OF 8

PLOT SCALE: 1:1 @ 24"x36"; 1:2 @ 11"x17"

CASE #



Shift Companies, LLC
7233 E. MONTE VISTA ROAD
SCOTTSDALE, ARIZONA 85257
ph: 480.264.0829
fax: 480.264.0163


THE SOLE PROPERTY OF THE OWNER. IT IS PRODUCED SOLELY FOR USE BY THE OWNER AND ITS AFFILIATES. REPRODUCTION OR USE OF THIS DRAWING AND/OR THE INFORMATION CONTAINED IN IT IS FORBIDDEN WITHOUT THE WRITTEN PERMISSION OF THE OWNER.

LATITUDE:	26.71667
LONGITUDE:	-86.76208
POLE TYPE:	WOOD POLE
POLE ID #	NA

CROWN CASTLE
CROWN CASTLE
P.O. BOX 1401
HOUSTON, TX 77002
PH: 409.342.4401



RECORD DRAWINGS ISSUE DATE: 4/11/14




RECORD DRAWING CHARTING ONLY

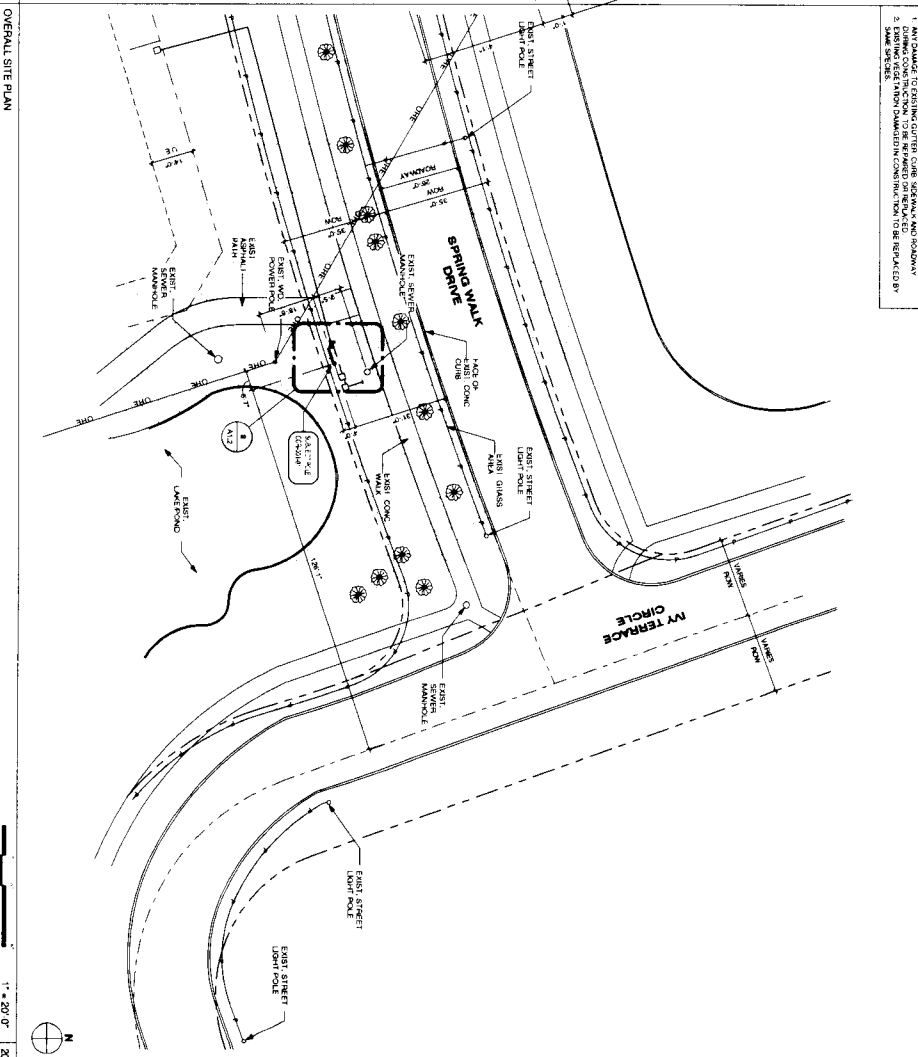

NOTES
1. ANY DAMAGE TO EXISTING GUTTER CURB SIDEWALK AND ROADWAY DURING CONSTRUCTION TO BE REPAIRED OR REPLACED.
2. EXISTING VEGETATION DAMAGED IN CONSTRUCTION TO BE REPLACED BY SAME SPECIES.

SRII COMPANY, LLC		
YOU I OWN WITH ME		
PO BOX 403 LA JOLLA, CA 92033 LA 404-643-6373		
THIS DRAWING IS CONVEYED AND IS THE SOLE PROPERTY OF THE OWNER. IT IS NOT TO BE REPRODUCED OR COPIED IN ANY MANNER WITHOUT THE WRITTEN PERMISSION OF THE OWNER.		
OWNER NAME & ADDRESS: AS SHOWN ON PLAT AND ALL INFORMATION CONTAINED HEREIN IS FOR THE EXCLUSIVE USE OF THE OWNER.		
RELEASE		
DATE	SUBMITTAL	
11/6/13	(1) CITY SUBMITTAL	
4/17/14	PERMITS SUBMITTAL	
REVISIONS		
NO.	DATE	COMMENT
1	12/1/13	Fair Construction
2	4/17/14	KNOWN CORRECTION
PROJECT NAME		
VERIZON - CINCO RANCH		
MODE ADDRESS		
NODE #CCR-001-01		
SPRING WALK DR. & IVY TERRACE CIR.		
HIGH PWA		
CINCO RANCH, TX		
SHEET NO NUMBER		
120603		
DRAWN BY: RA		
CHECKED BY:		
SHEET TITLE		
SITE PLAN, EQUIPMENT AND ANTENNA PLAN		
SHEET NUMBER		
A1.2		
PAGE		
4 OF 8		

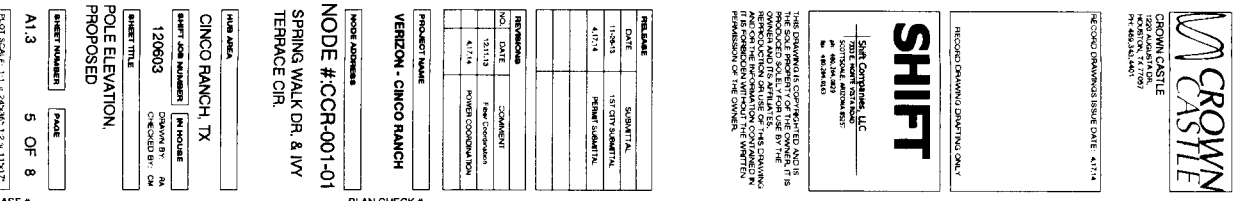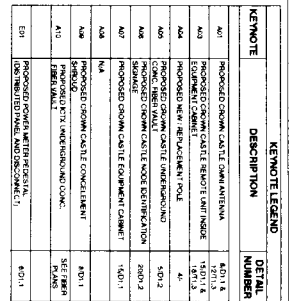

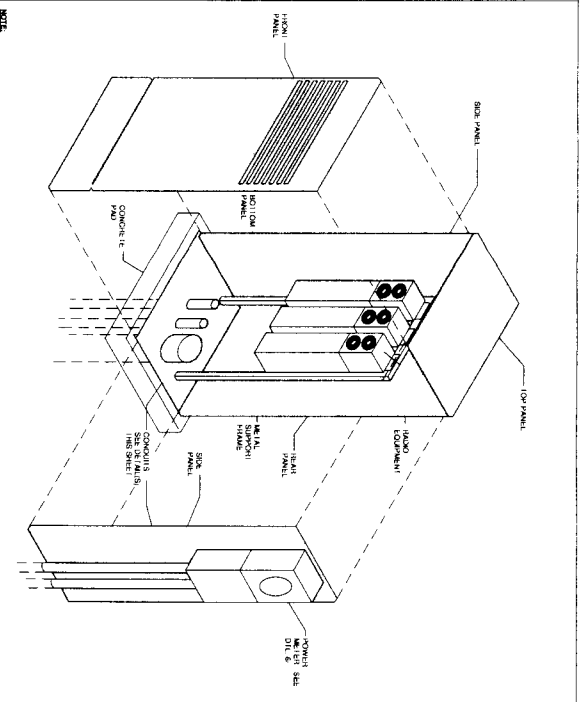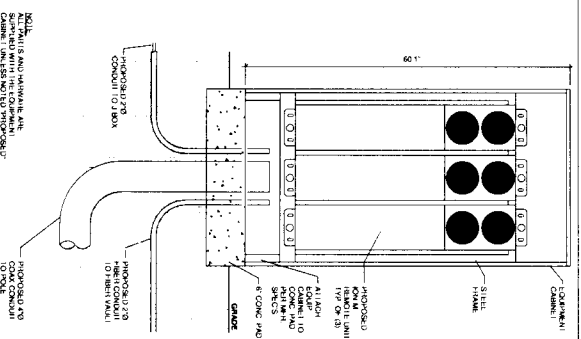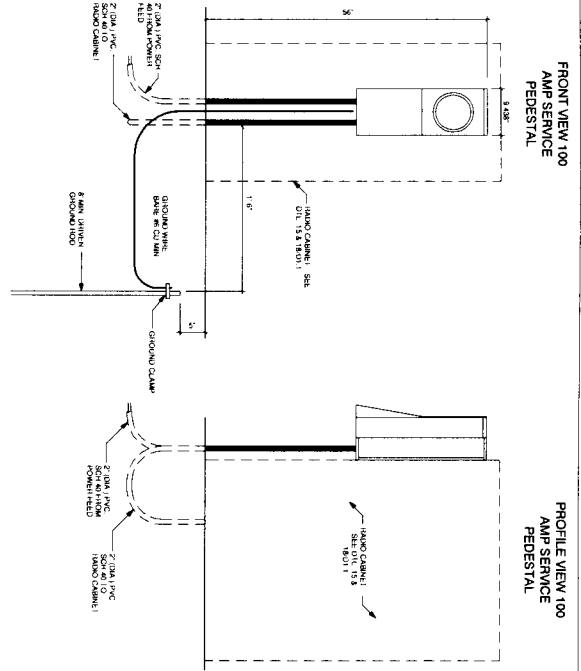

POWER METER - MOUNTED TO RADIO CABINET


SCALE: 1" = 1'-0"

EQUIPMENT CABINET SECTION

SCALE: 1" = 1'-0"

EQUIPMENT ENCLOSURE

SCALE: 1" = 1'-0"

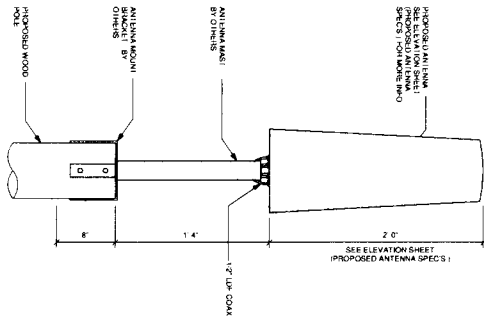

ANTENNA MOUNTING DETAIL

SCALE: 1" = 1'-0"

COCK HANGER DETAIL

SCALE: 1" = 1'-0"

CONDUIT AND POWER RISER DIAGRAM

SCALE: 1" = 1'-0"

CONDUIT ROUTE

SCALE: 1" = 1'-0"

SCALE: 1" = 1'-0"

CROWN CASTLE
1000 N. DALLAS STREET
SUITE 100
DALLAS, TEXAS 75201
TEL: 972.344.4400

RECORD DRAWING ISSUE DATE: 4/17/14

SHIFT
SHIFT COMPANY, LLC
1000 N. DALLAS STREET
SUITE 100
DALLAS, TEXAS 75201
TEL: 972.344.4400

THIS DRAWING IS COPYRIGHTED AND IS THE SOLE PROPERTY OF THE OWNER. IT IS NOT TO BE REPRODUCED OR TRANSMITTED IN ANY FORM OR BY ANY MEANS, ELECTRONIC OR MECHANICAL, INCLUDING PHOTOCOPYING, RECORDING, OR BY ANY INFORMATION STORAGE AND RETRIEVAL SYSTEM, WITHOUT THE WRITTEN PERMISSION OF THE OWNER.

RECORD DRAWING CHARTING ONLY

DATE: 4/17/14
SUBMITTAL: 1ST CITY SUBMITTAL
PROJECT SUBMITTAL: 4/17/14

REVISIONS
NO. DATE COMMENT
1 12/1/13 Final Construction
2 4/17/14 POWER COORDINATION

PROJECT NAME: VERNON - CINCO RANCH

WORK ADDRESS: NODE #CCR-001-01
SPRING WALK DR. & IVY TERRACE CIR.

 
 
SHEET AREA: CINCO RANCH, TX
SHEET JOB NUMBER: IN HOUSE
120603
DESIGNED BY: SA
CHECKED BY: CM

CONSTRUCTION DETAILS

SHEET NUMBER: 6 OF 8
D1.1
PLOT SCALE: 1" = 2'-0" (12" x 18")

CASE #

PLAN CHECK #




REVISIONS	
NO.	DATE
1	12/11/13
2	12/11/13
3	12/11/13
100	12/11/13

SYMBOL	DESCRIPTION
	IRRADIATION
	KEY NOTE
	DETAIL REFERENCE
	ELEVATION REFERENCE
	SECTION REFERENCE
	ELEVATION MARKER
	PROGRAM REFERENCE
	ANTENNA JUNCTION
	NEW NUMBER
	SHEET NUMBER
	SHEET GROUP

RECORD DRAWING ISSUE DATE: 4/17/14

 1220 ADELIA DR
 CINCINNATI, OH 45240
 PH: 402-243-1401



RECORD DRAWING EXPIRATION DATE: 4/17/14

SHIFT

SIN CORPORATION, LLC
 10000 WILSON BLVD
 SUITE 400
 ST. LOUIS, MO 63114

THIS DRAWING IS COPYRIGHTED AND IS THE SOLE PROPERTY OF THE OWNER. IT IS NOT TO BE REPRODUCED OR TRANSMITTED IN ANY FORM OR BY ANY MEANS, ELECTRONIC OR MECHANICAL, INCLUDING PHOTOCOPYING, RECORDING, OR BY ANY INFORMATION STORAGE AND RETRIEVAL SYSTEM, WITHOUT THE WRITTEN PERMISSION OF THE OWNER.

RELEASE	
DATE	SUBMITTAL
1/26/13	13/1075 SUBMITTAL
4/17/14	PERMIT SUBMITTAL

REVISIONS		
NO.	DATE	COMMENT
1	10/15/13	PERMIT CORRECTION
4	4/17/14	NUMBER CORRECTION

PROJECT NAME: VERIZON - CINCO RANCH

PROJECT ADDRESS:

NOTE #: CCR-007-01

LOCATION: DILLON CREEK LN., S. OF SHAMBALA WV.

NAME: ADELA

CINCO RANCH, TX

SHIFT JOB NUMBER: 1206093

SHEET TITLE:

GENERAL NOTES:

ABBREVIATIONS AND SYMBOLS:

SHIFT NUMBER:

IN HOUSE

DESIGNED BY: SA

CHECKED BY: CA

DATE: 2 OF 8


PLAN SCALE: 1" = 40' (AS SHOWN) 1/2" = 20' (NOT SHOWN)

ION-M7P/17P - Product Specification

SCALE: N.T.S.

700 MHz Dual Band Omni Antenna

840 10510 840 10511
700 MHz Dual Band Omni Antenna

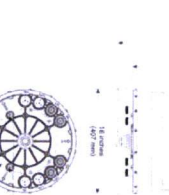

Answers indicate the direction of maximum slope (steep).



Order information:

ISBN:	Description:
000-10301	Power Curbank's post
ISBN 10313	Gray Curbank's post

SCALE: N.T.S. 12

[illegible]

HECK #

1

1

100

1

3

CASE


1



LATITUDE	36.71073
LONGITUDE	-96.79660
POLE TYPE	METAL STAINLESS POLE
POLE ID #	NA

1. PLANT IMPROVED GROUND COVERING: A NATURAL, LIGHT-COLOR, NON-POISONOUS, PERENNIAL, EROSION-CONTROL, SOIL-RETENTION, AND SOIL-CONSERVATION PLANT.
2. EX. LABORATORY PLANTINGS AND ECOLOGICAL WATERSHEDS, REVEGETATION, AND SOIL CONSERVATION. CONSTRUCTION SHALL BE COMPLETED WITH A ONE-MILE RADIUS PERIOD.
3. CONSTRUCTION TO MAINTAIN THE EX. REVEGETATION PLANT TO DECONTAMINATION.
4. SURVEY FOR A SUSTAINABLE, REVEGETATION IN THE CITY OF AFRICA.
5. VIEWER: ALL PROJECTS, REVEGETATION IN THE CITY OF AFRICA.
6. EROSION CONTROL: REVEGETATION IN THE CITY OF AFRICA.

CONSTRUCTION TO MAINTAIN THE EX. REVEGETATION PLANT TO DECONTAMINATION.

GENERAL NOTES

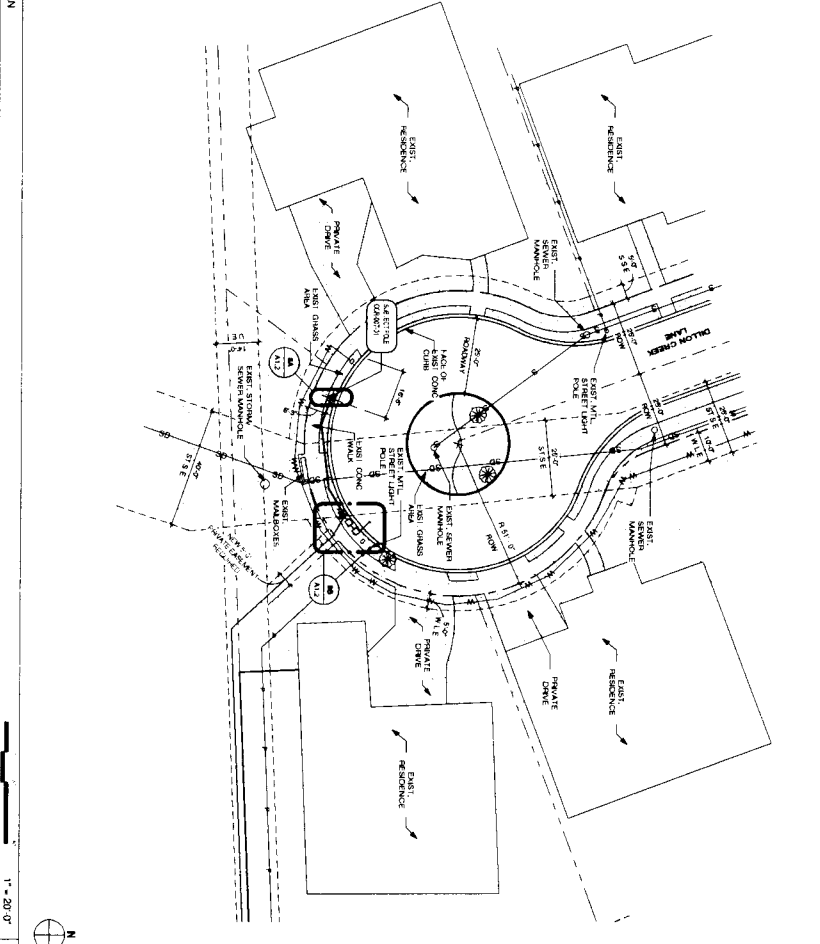[illegible]

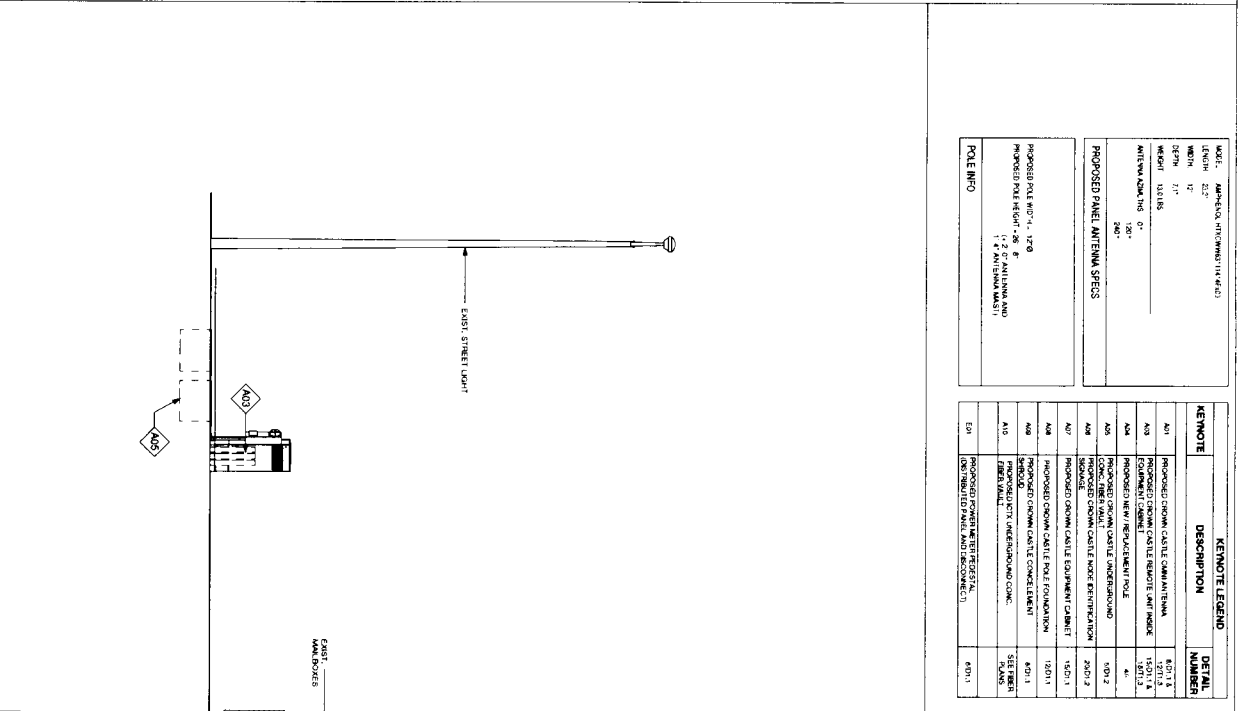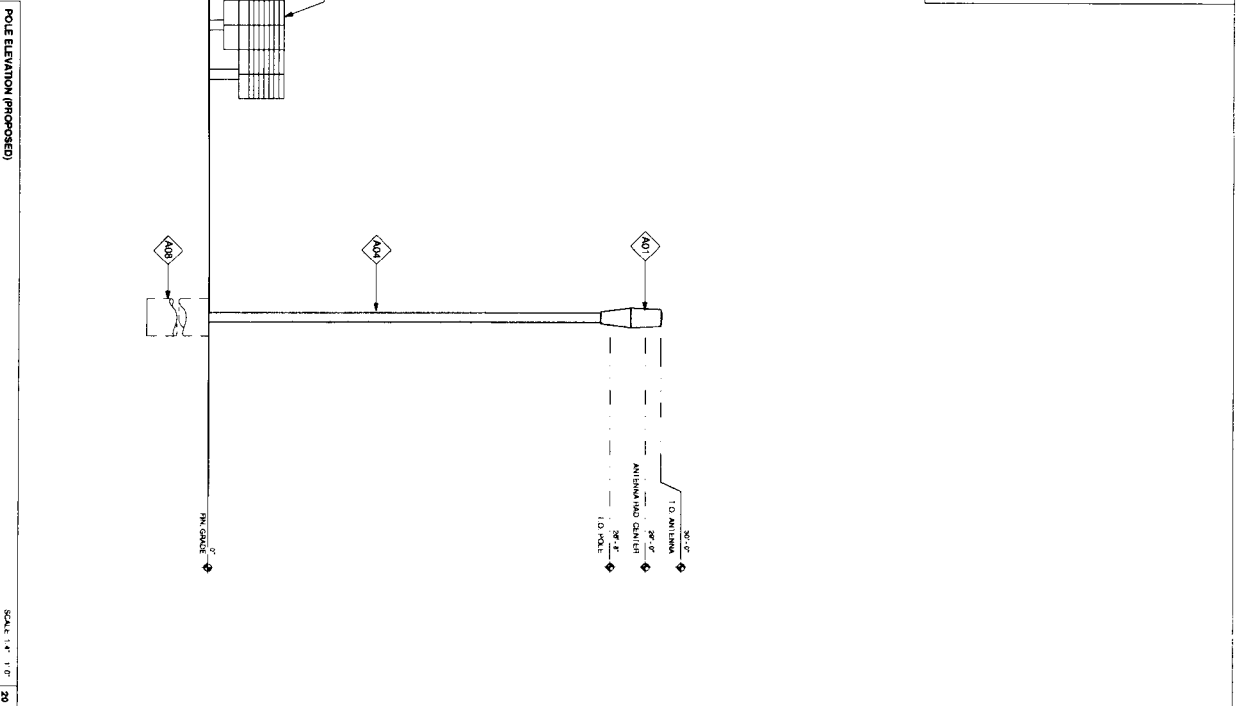[illegible]




SHIFT










Shift Companies, LLC
 1501 E. FRONT STREET
 SCOTTSDALE, ARIZONA 85257
 PH 480.246.0023
 FAX 480.246.0163

RECORD DRAWING'S ISSUE DATE: 4/17/4

CROWN CASTLE
1220 AUGUSTA DR.
HOUSTON, TX 77057
PH: 409.343.4401

PROJECT NAME	VERIZON - CINCO RANCH
MODE ADDRESS	MODE ADDRESS
MODE #	MODE # CCR-007-01
DILLON CREEK LN, S. OF SHAMBALA WY.	
MAIL AREA	MAIL AREA
CINCO RANCH, TX	CINCO RANCH, TX
SHEET JOB NUMBER	SHEET JOB NUMBER
120603	120603
BY HOUSE	BY HOUSE
DRAWN BY: RA	DRAWN BY: RA
CHECKED BY: CM	CHECKED BY: CM
SHEET TITLE	SHEET TITLE
POLE ELEVATION, PROPOSED	
SHEET NUMBER	SHEET NUMBER
A1.3	A1.3
PAGE	PAGE
5 OF 8	5 OF 8
NOT SCALE 1" = 40' DATE 12-24-17	

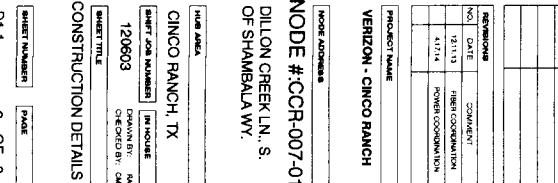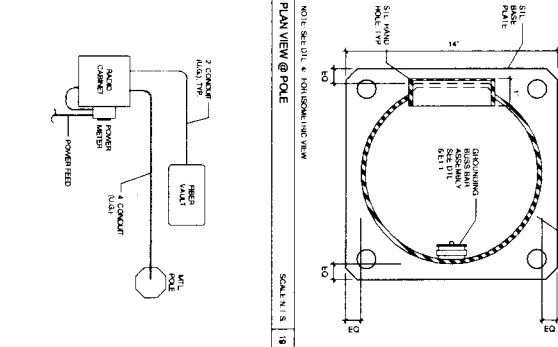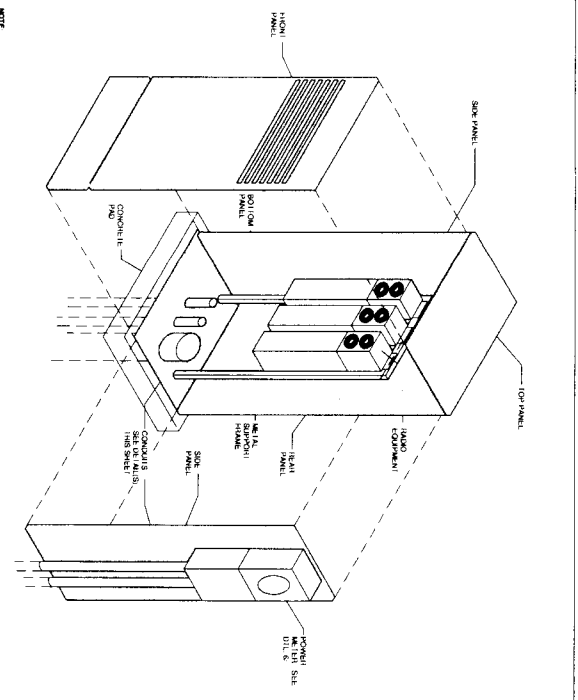

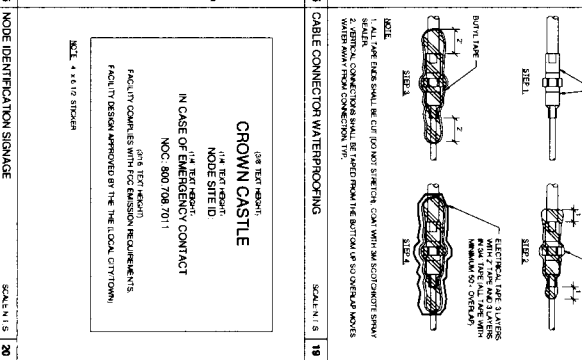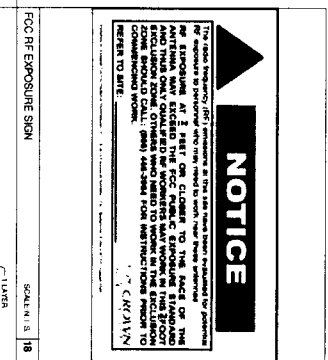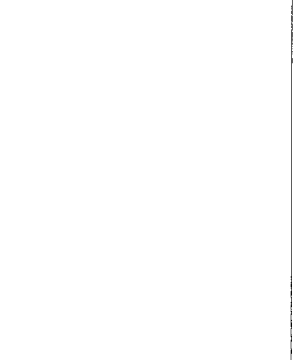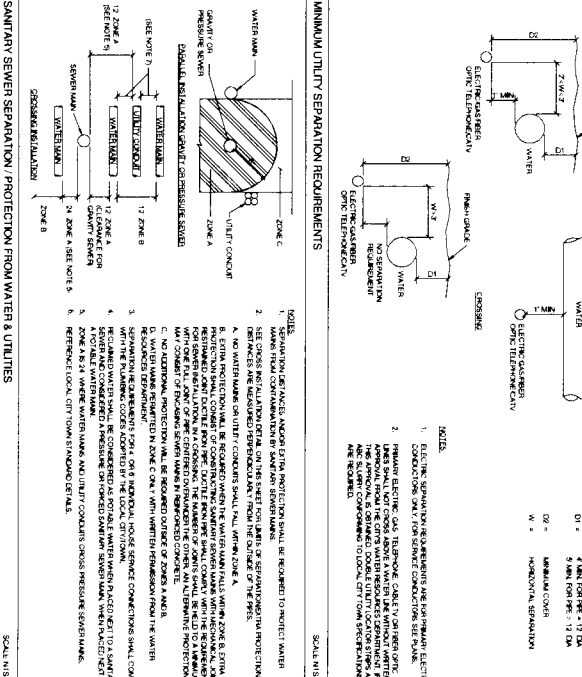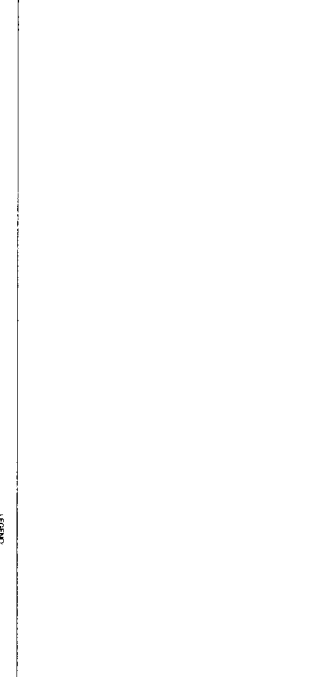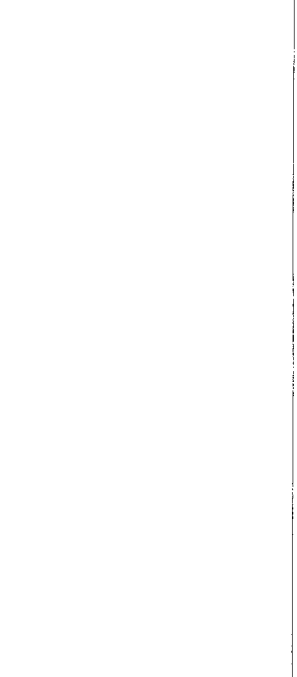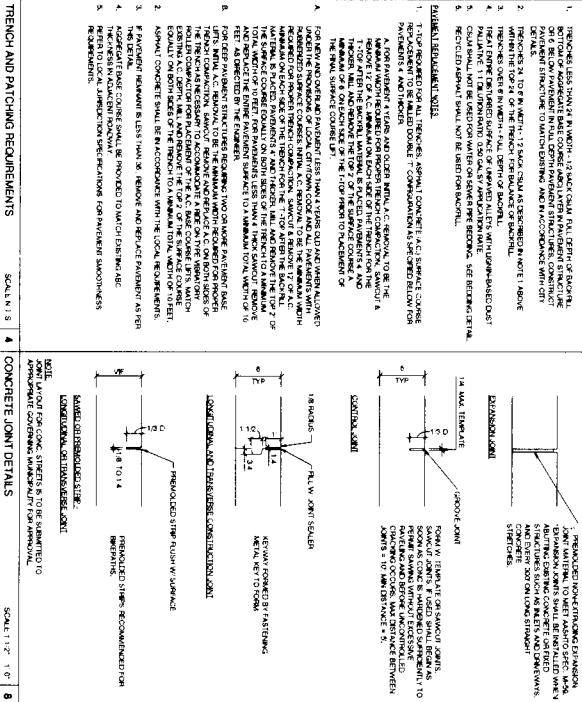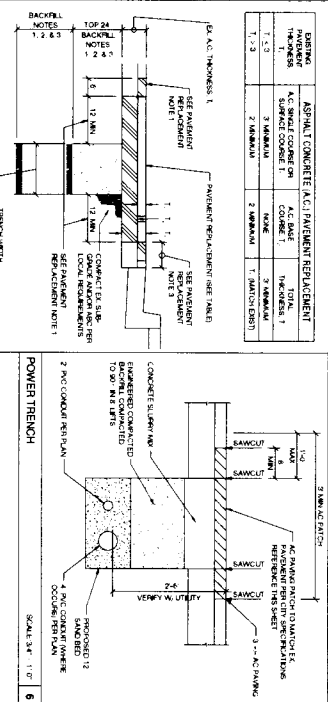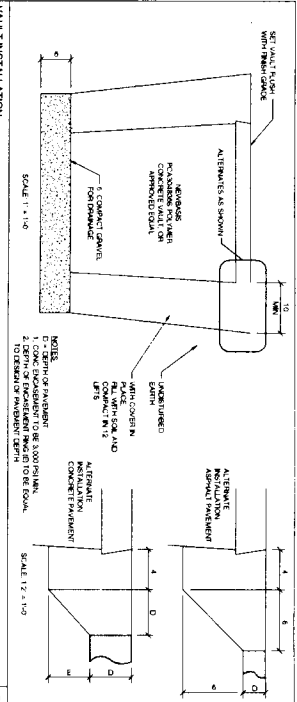

SHIFT

SHIFT DATE: 4/18/14
SHIFT TIME: 12:00 PM - 1:00 PM
SHIFT LOCATION: CINCO RANCH, TX
SHIFT JOB NUMBER: 120003
SHIFT TITLE: CONSTRUCTION DETAILS

PROJECT NAME
VERZON - CINCO RANCH

PROJECT ADDRESS
DILLON CREEK LN., S.
OF SHAMBALE WA.

PROJECT NUMBER
CCR-007-01

PROJECT DATE
4/18/14

PROJECT DRAWN BY
DAVID L. BROWN

PROJECT CHECKED BY
DAVID L. BROWN

PROJECT NAME
VERZON - CINCO RANCH





PROJECT ADDRESS
DILLON CREEK LN., S.
OF SHAMBALE WA.

PROJECT NUMBER
CCR-007-01

PROJECT DATE
4/18/14

PROJECT DRAWN BY
DAVID L. BROWN

PROJECT CHECKED BY
DAVID L. BROWN

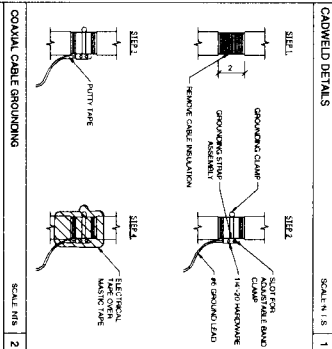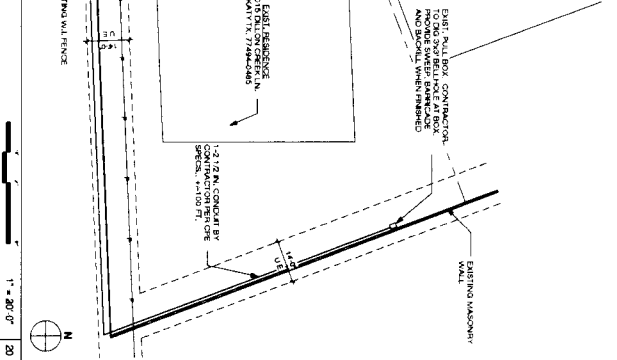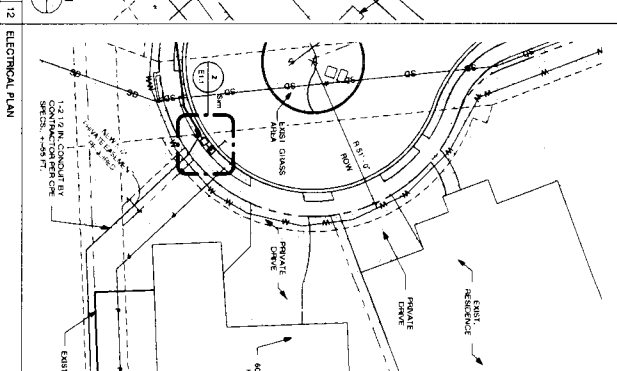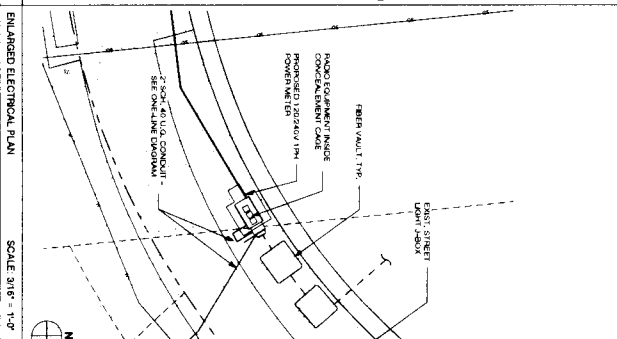[illegible]

THIS DRAWING IS COPYRIGHTED AND IS THE SOLE PROPERTY OF THE OWNER. IT IS PRODUCED SOLELY FOR USE BY THE OWNER AND ITS AFFILIATES. REPRODUCTION OR USE OF THIS DRAWING AND/OR THE INFORMATION CONTAINED IN IT IS FORBIDDEN WITHOUT THE WRITTEN PERMISSION OF THE OWNER.

CHRYSTEN ORO, CL
1220 AUGUSTA DR.
HOUSTON, TX 77067
PH: 409.343.4401

HUB ARIA

120003	CHECKED BY:
SHEET TITLE	

PLOT SCALE: 1:1 @ 24x36; 1:2 @ 11x

CASE